


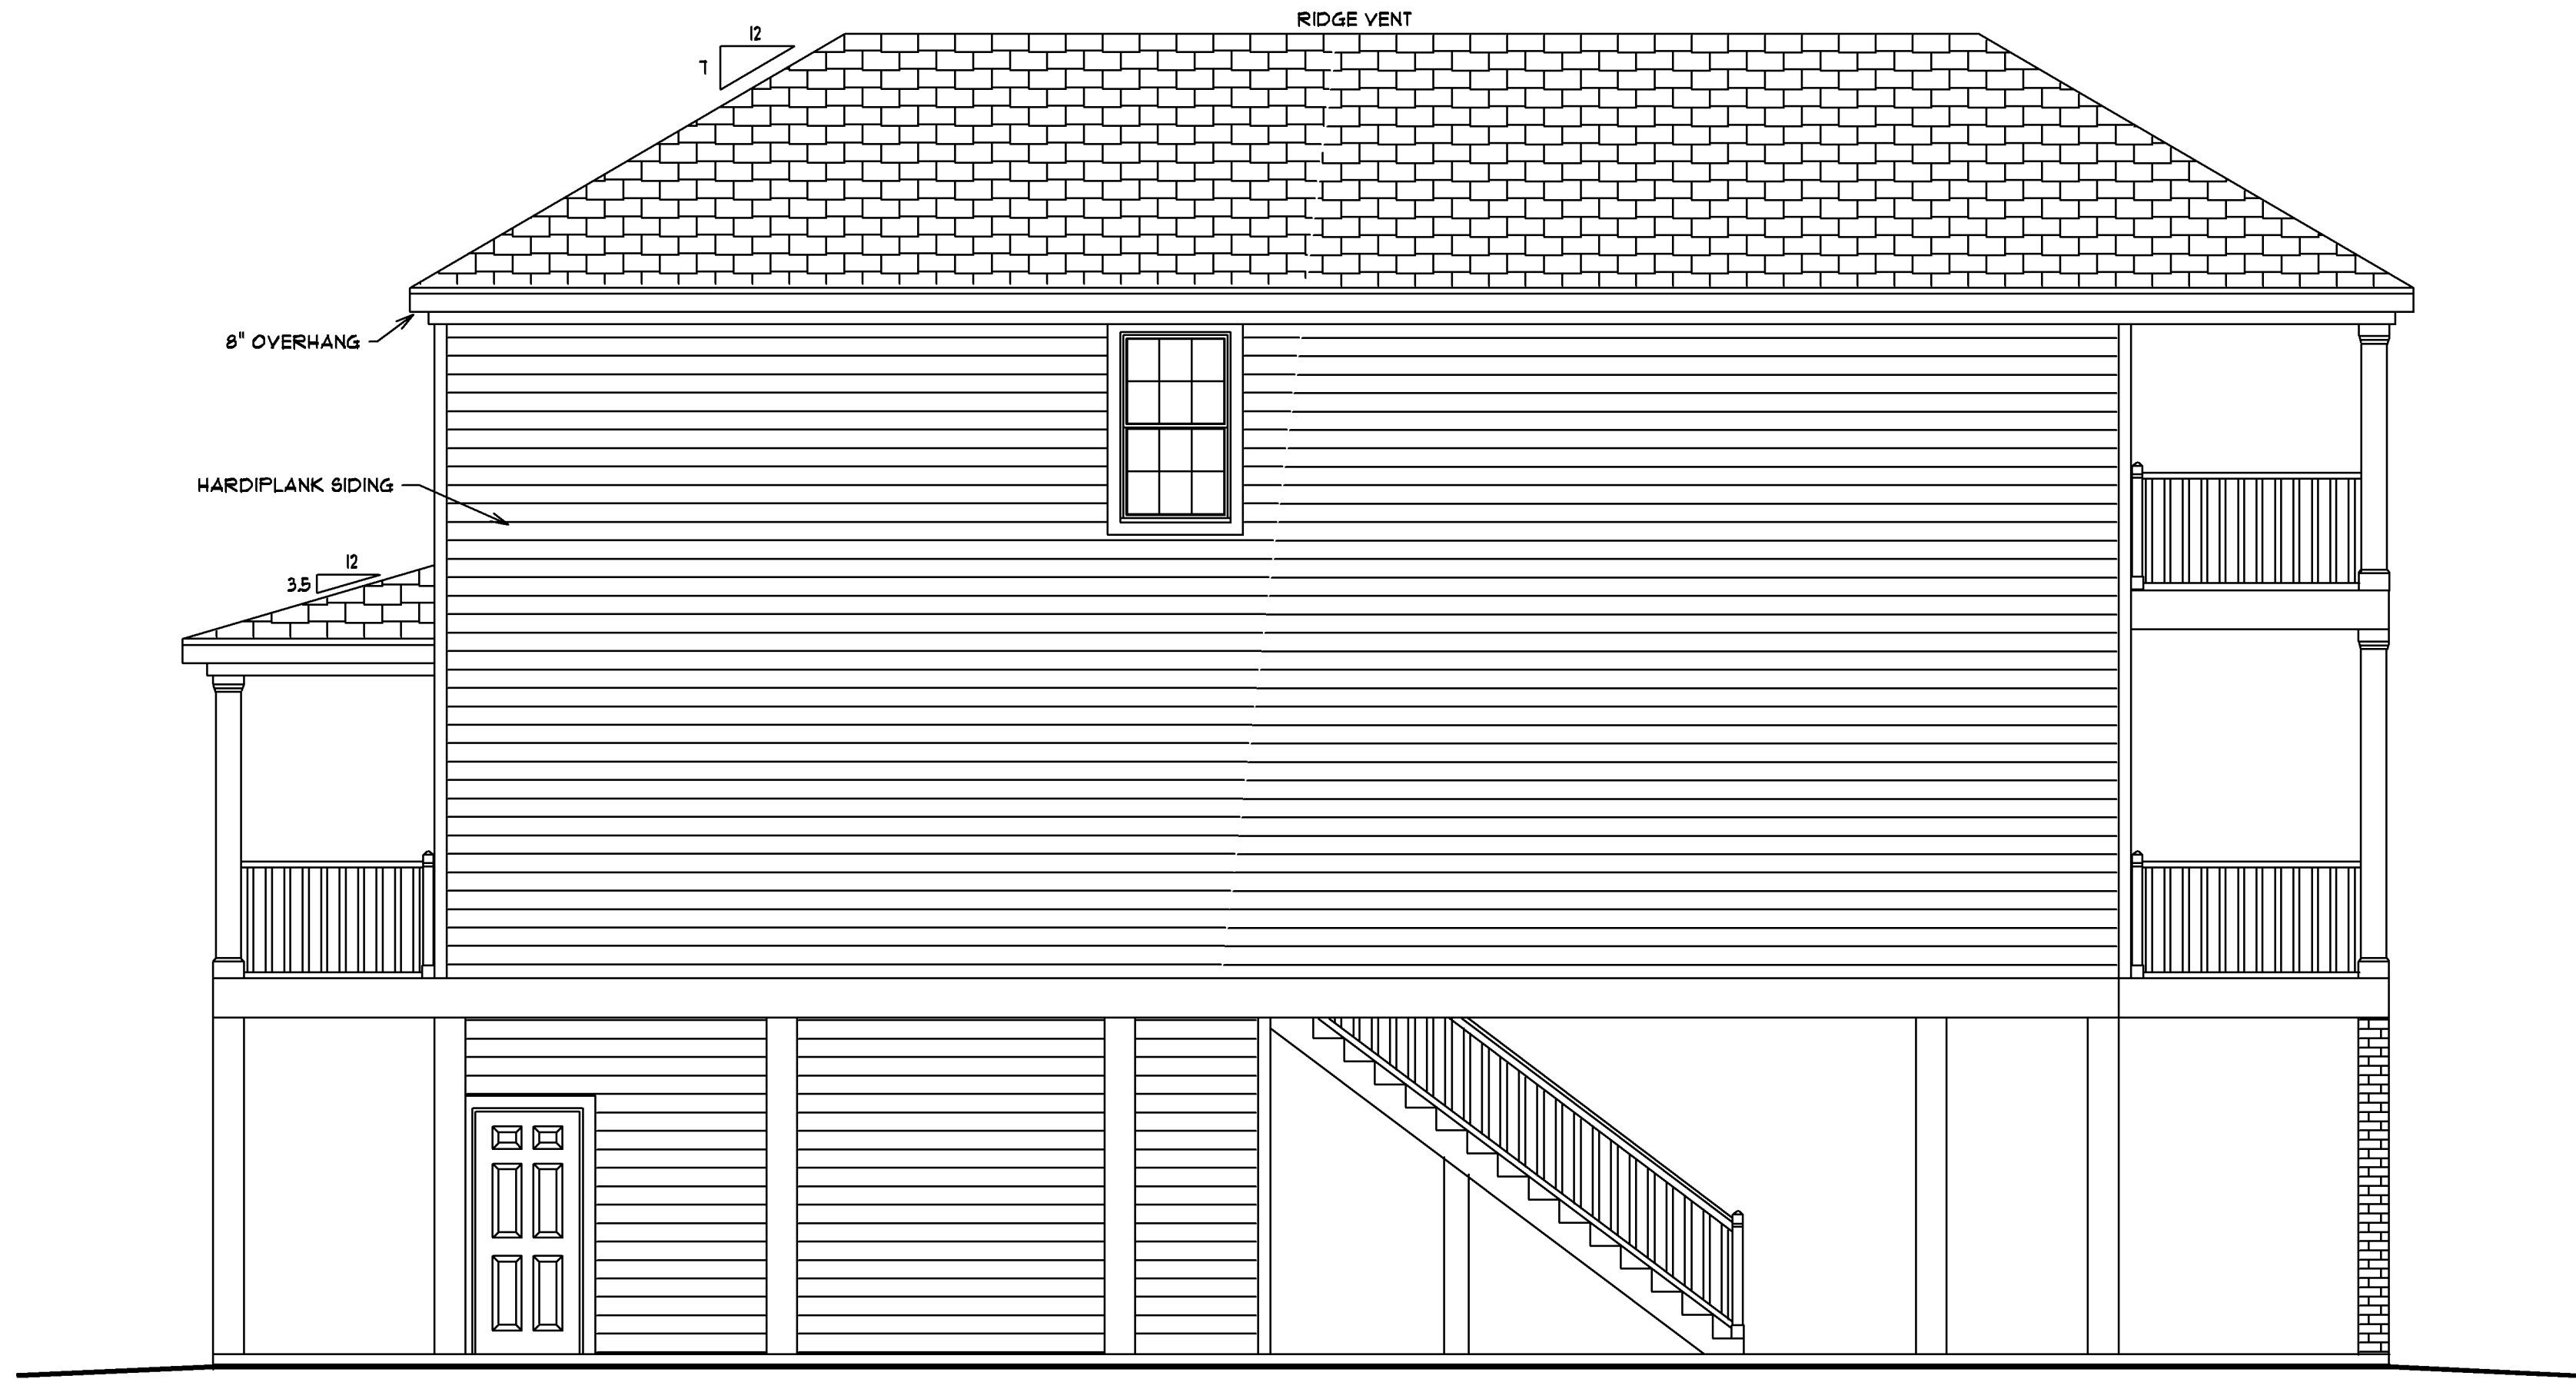


LEFT ELEVATION




RIGHT ELEVATION



FRONT ELEVATION

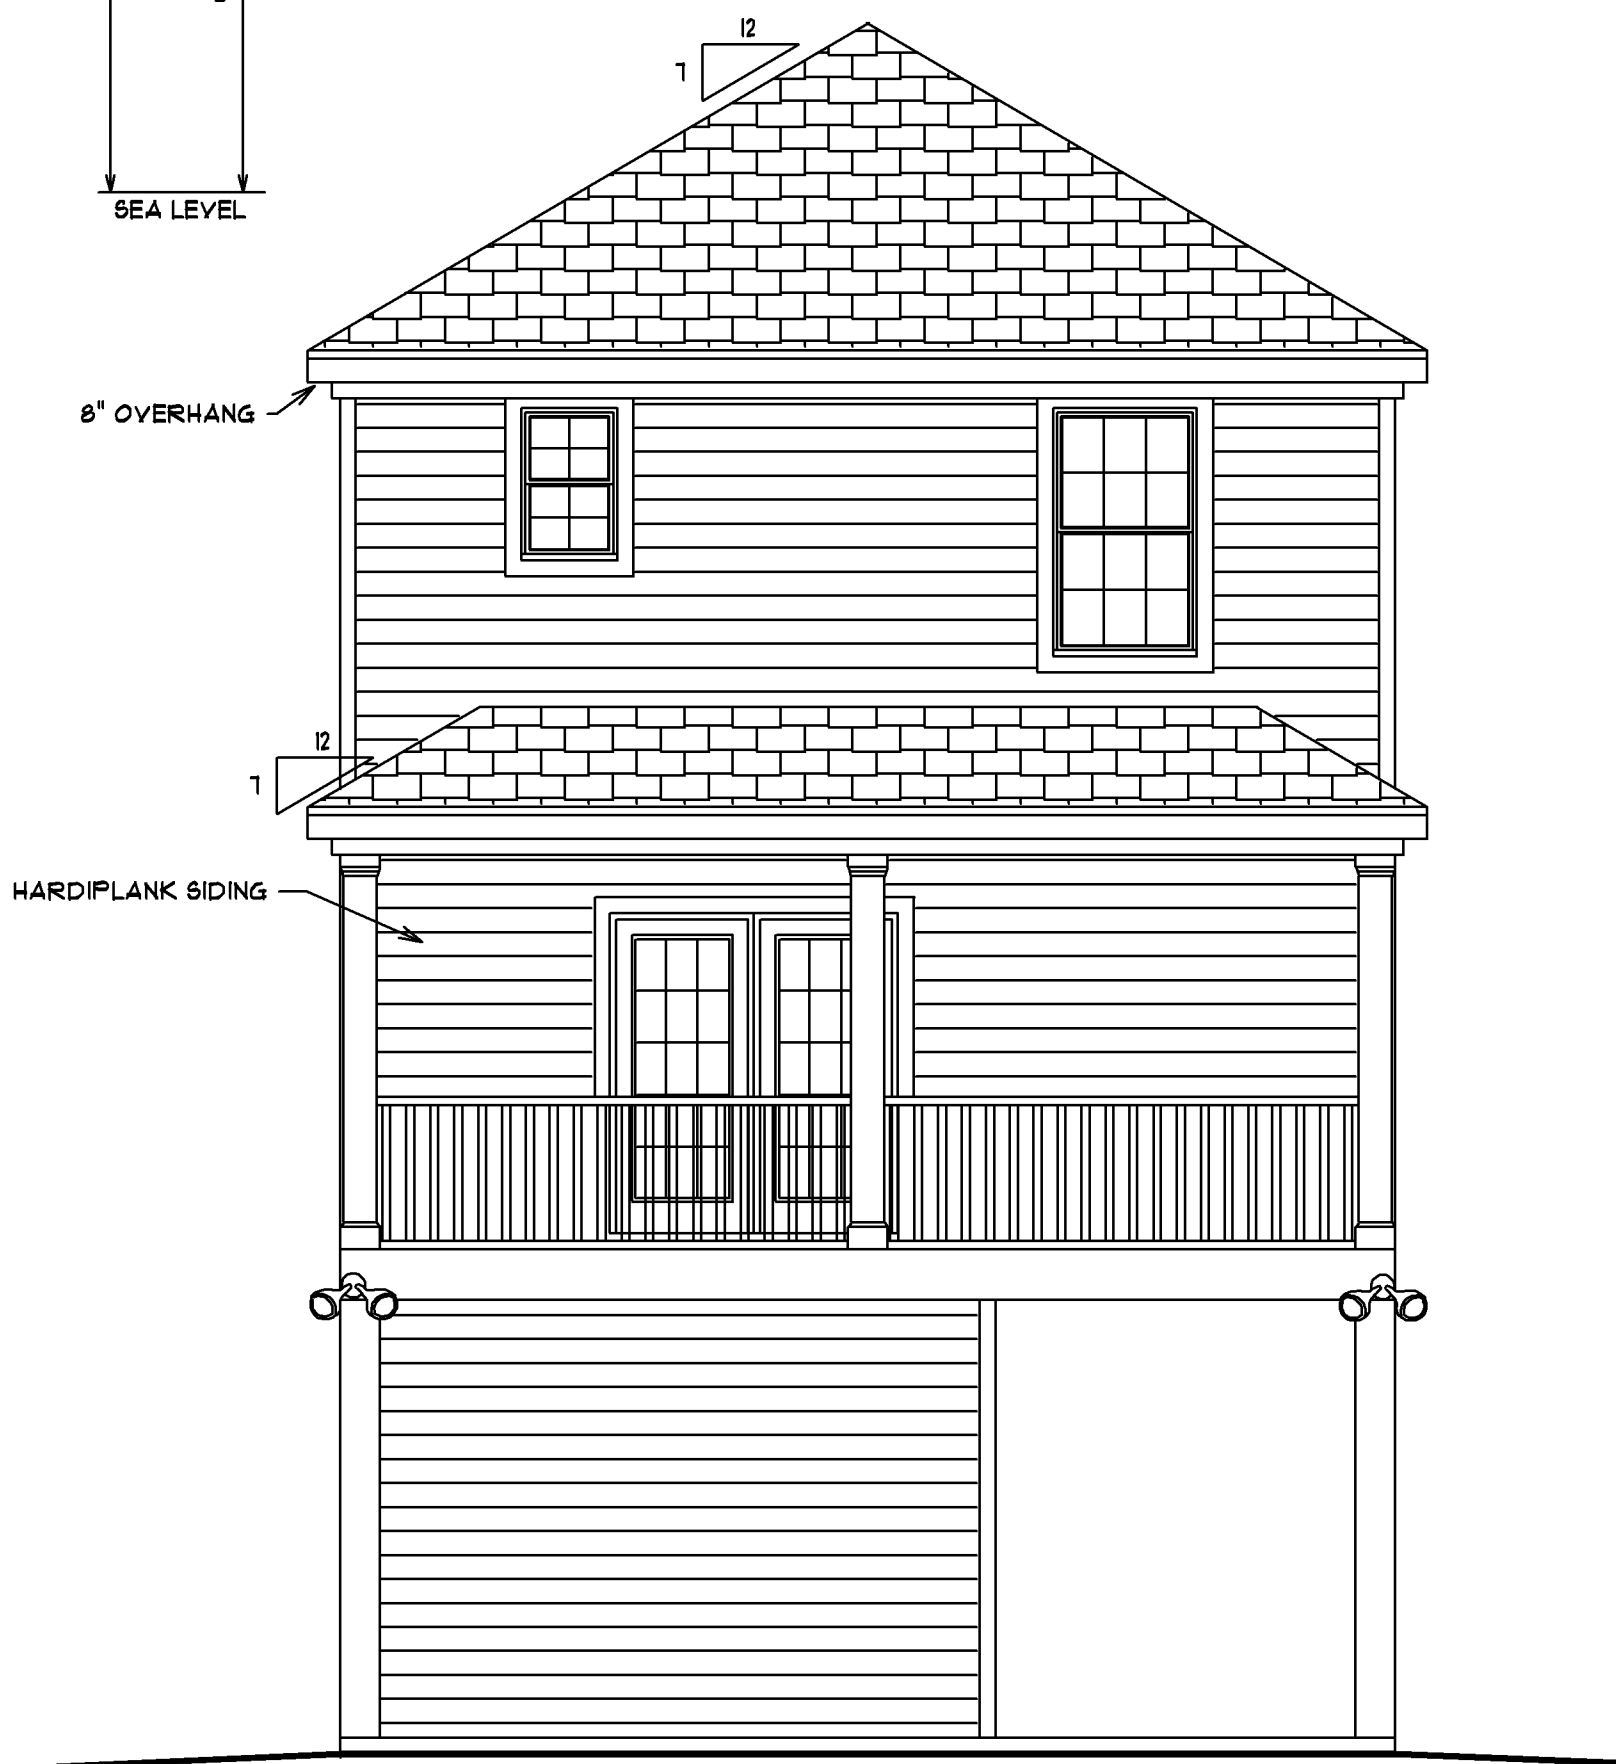

REAR ELEVATION

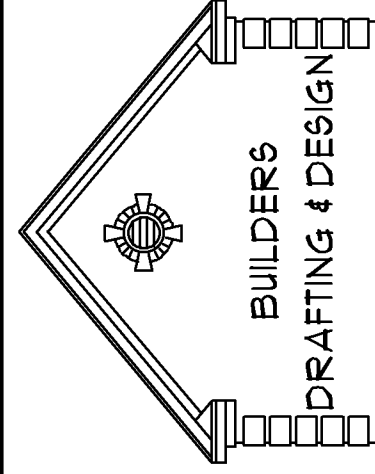

PAULA BURGIN
1341 CROOKED OAK DRIVE
FAULEY'S ISLAND, SC 29565
C: (843) 919-5500
C: (843) 283-3713
BURGINPAULA@AOL.COM

SCALE: 1/4" = 1'0"



DATE: 2/20/23

SHEET #1

ELEVATIONS

JOB LOCATION:
LOT C CALHOUN DRIVE
GARDEN CITY, SC

SQUARE FOOTAGE:	1042
1ST FLOOR HEATED	1019
2ND FLOOR HEATED	2061
TOTAL HEATED SPACE	310
GARAGE	440
COVERED PORCHES	2811
TOTAL UNDER ROOF	

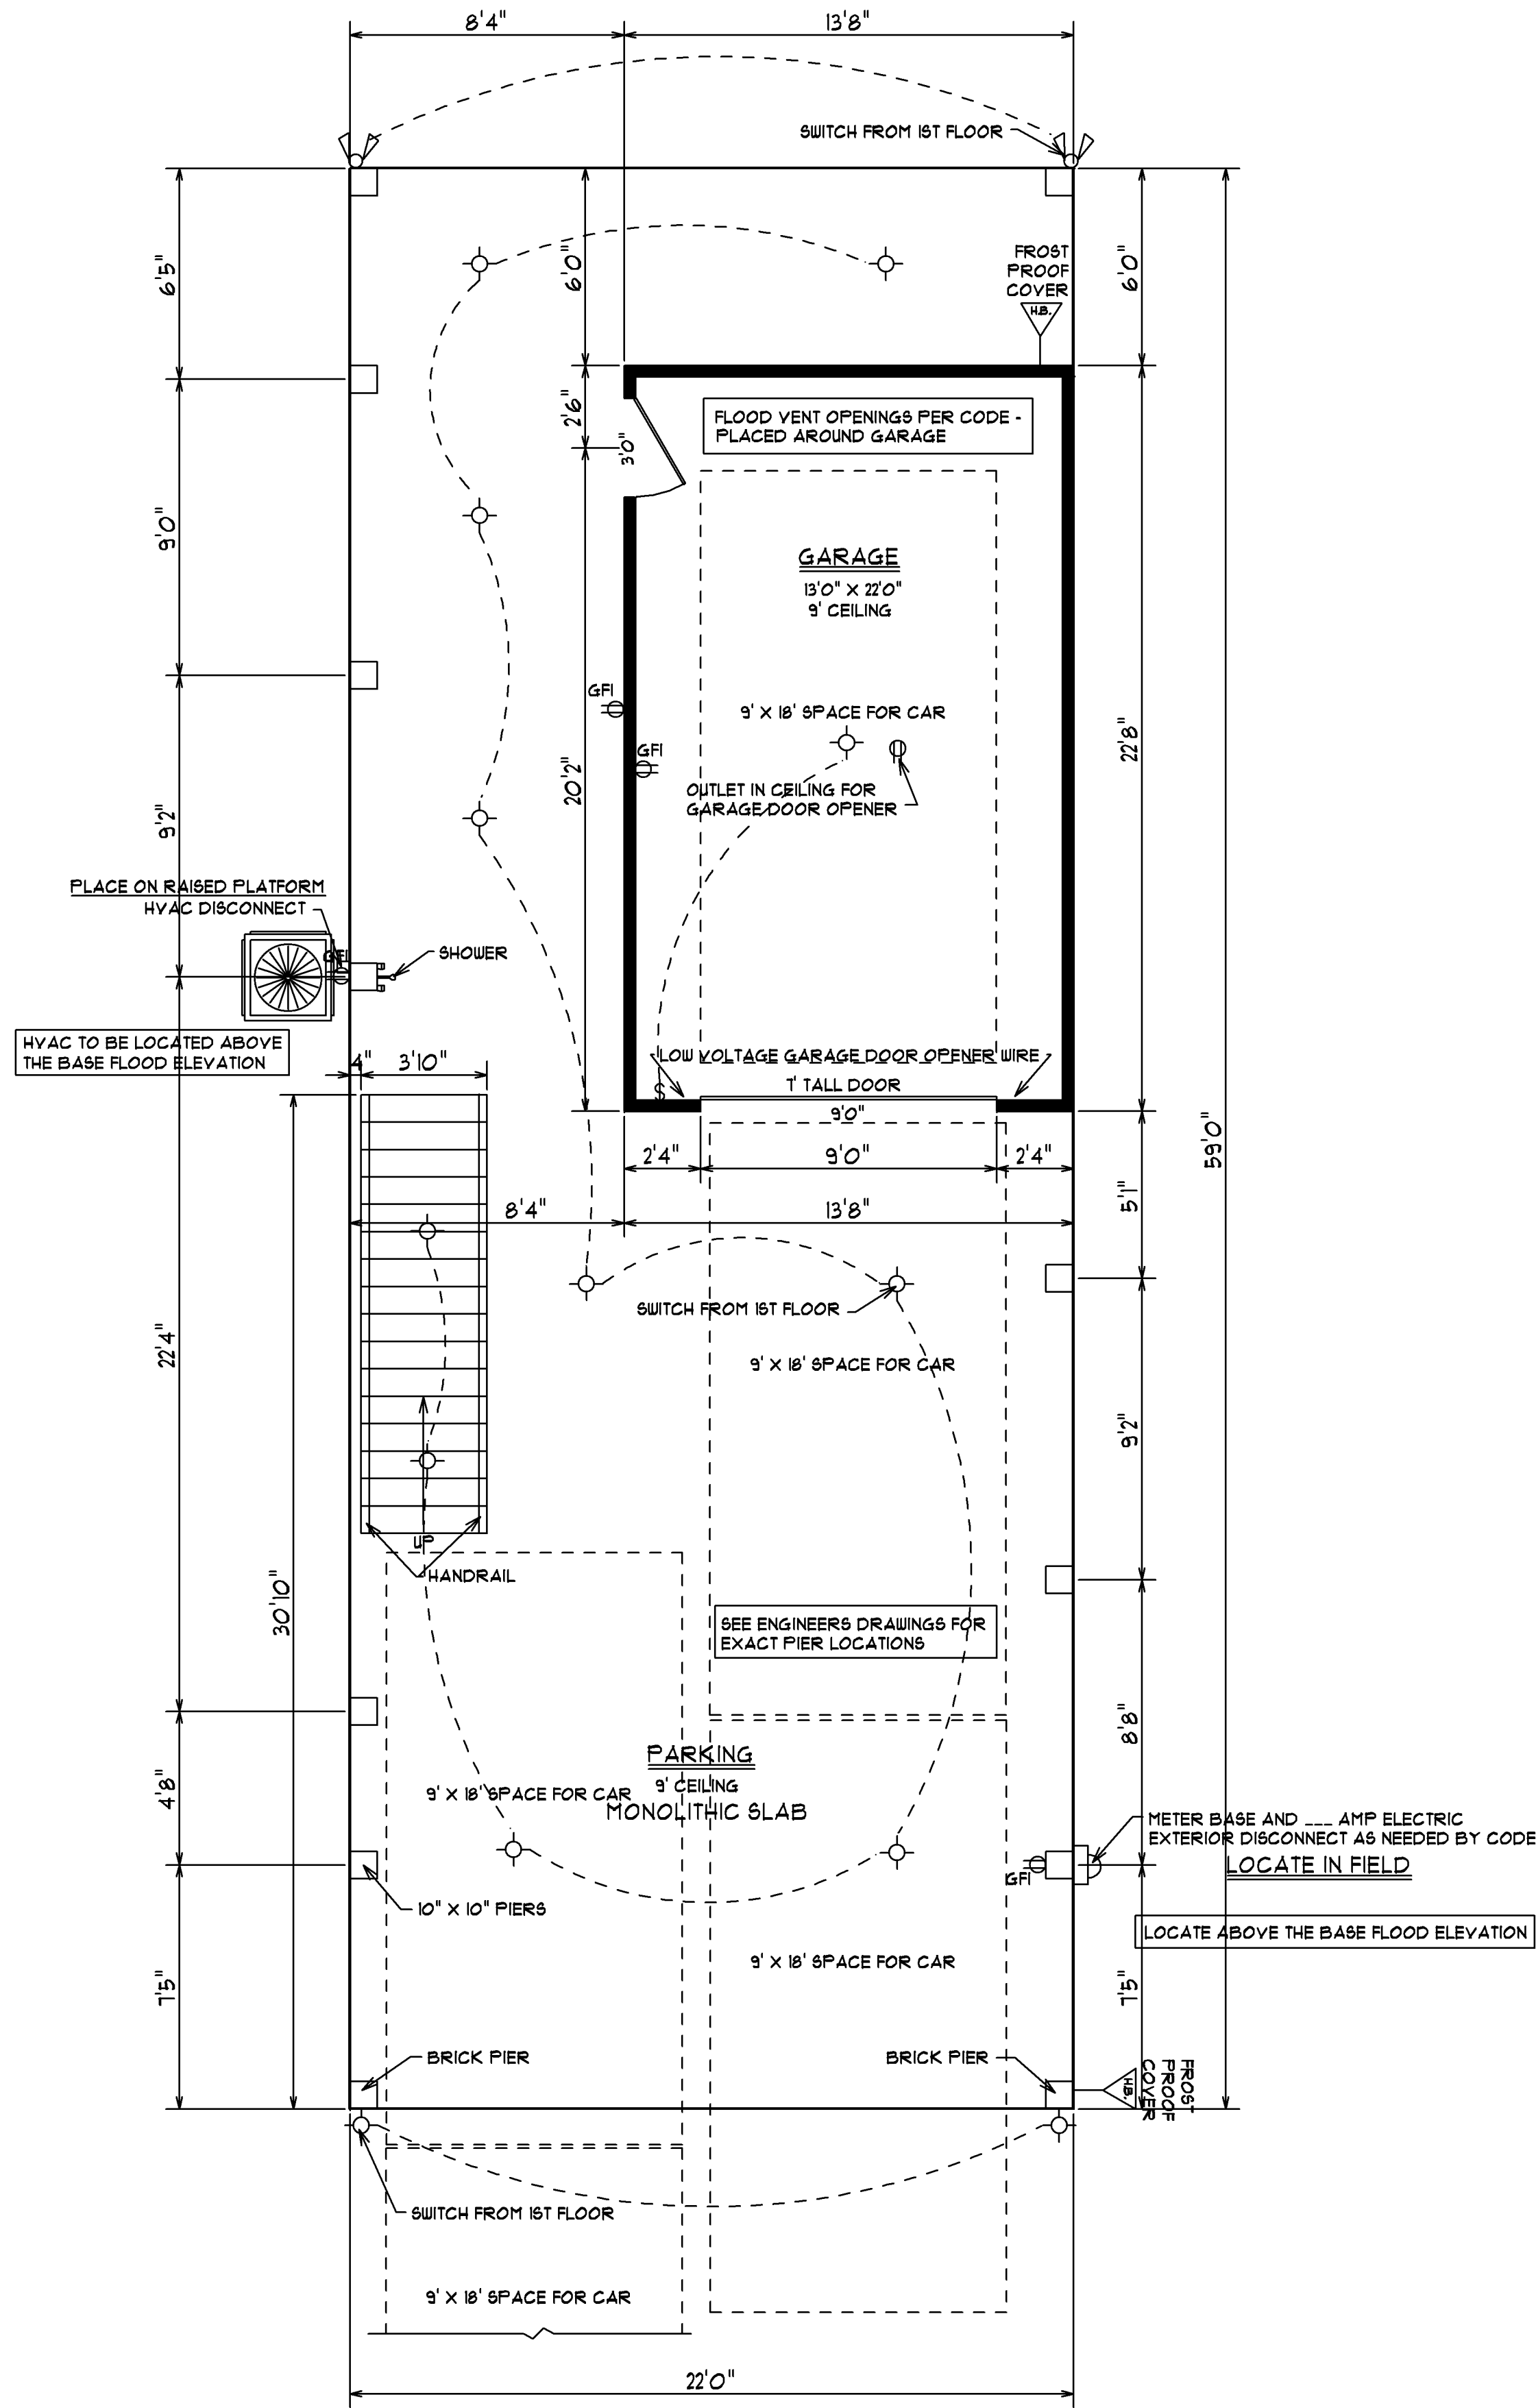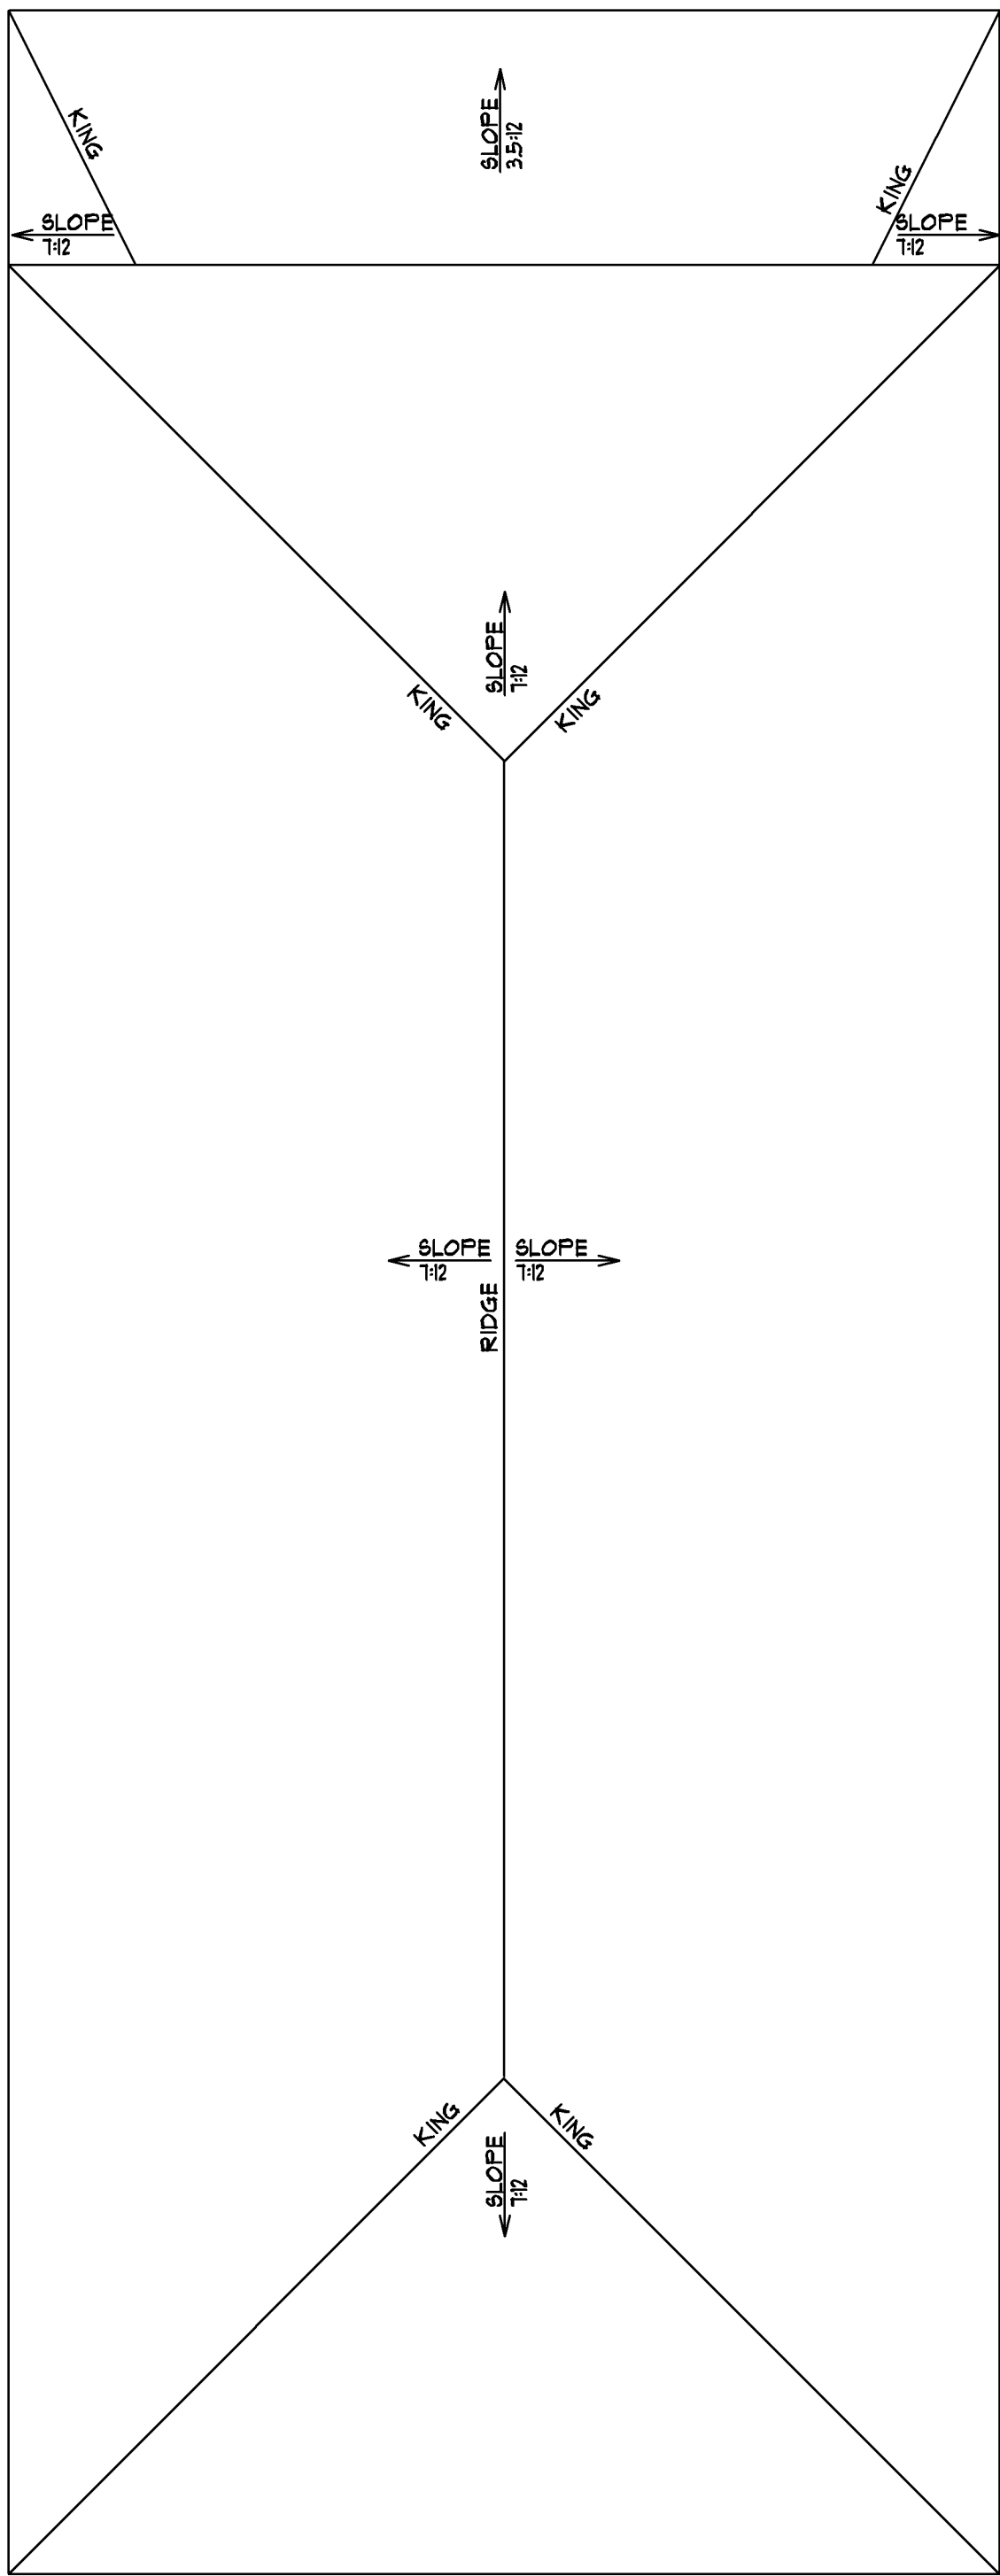

PAULA BURGIN
1341 CROOKED OAK DRIVE
FAULKLEY ISLAND, SC 29565
C: (843) 979-5500
B: (843) 283-3713
BURGINPAULA@AOL.COM


BUILDERS
DRAFTING & DESIGN

SCALE: 1/4" = 1'0"


DATE: 2/20/23

SHEET #2
GROUND
LEVEL PLAN/
ROOF PLAN


JOB LOCATION:		LOT C CALHOUN DRIVE GARDEN CITY, SC	
SQUARE FOOTAGE:	1ST FLOOR HEATED	1042	1019
	2ND FLOOR HEATED	2061	2061
	TOTAL HEATED SPACE	3103	3103
	GARAGE COVERED PORCHES TOTAL UNDER ROOF	440	2811

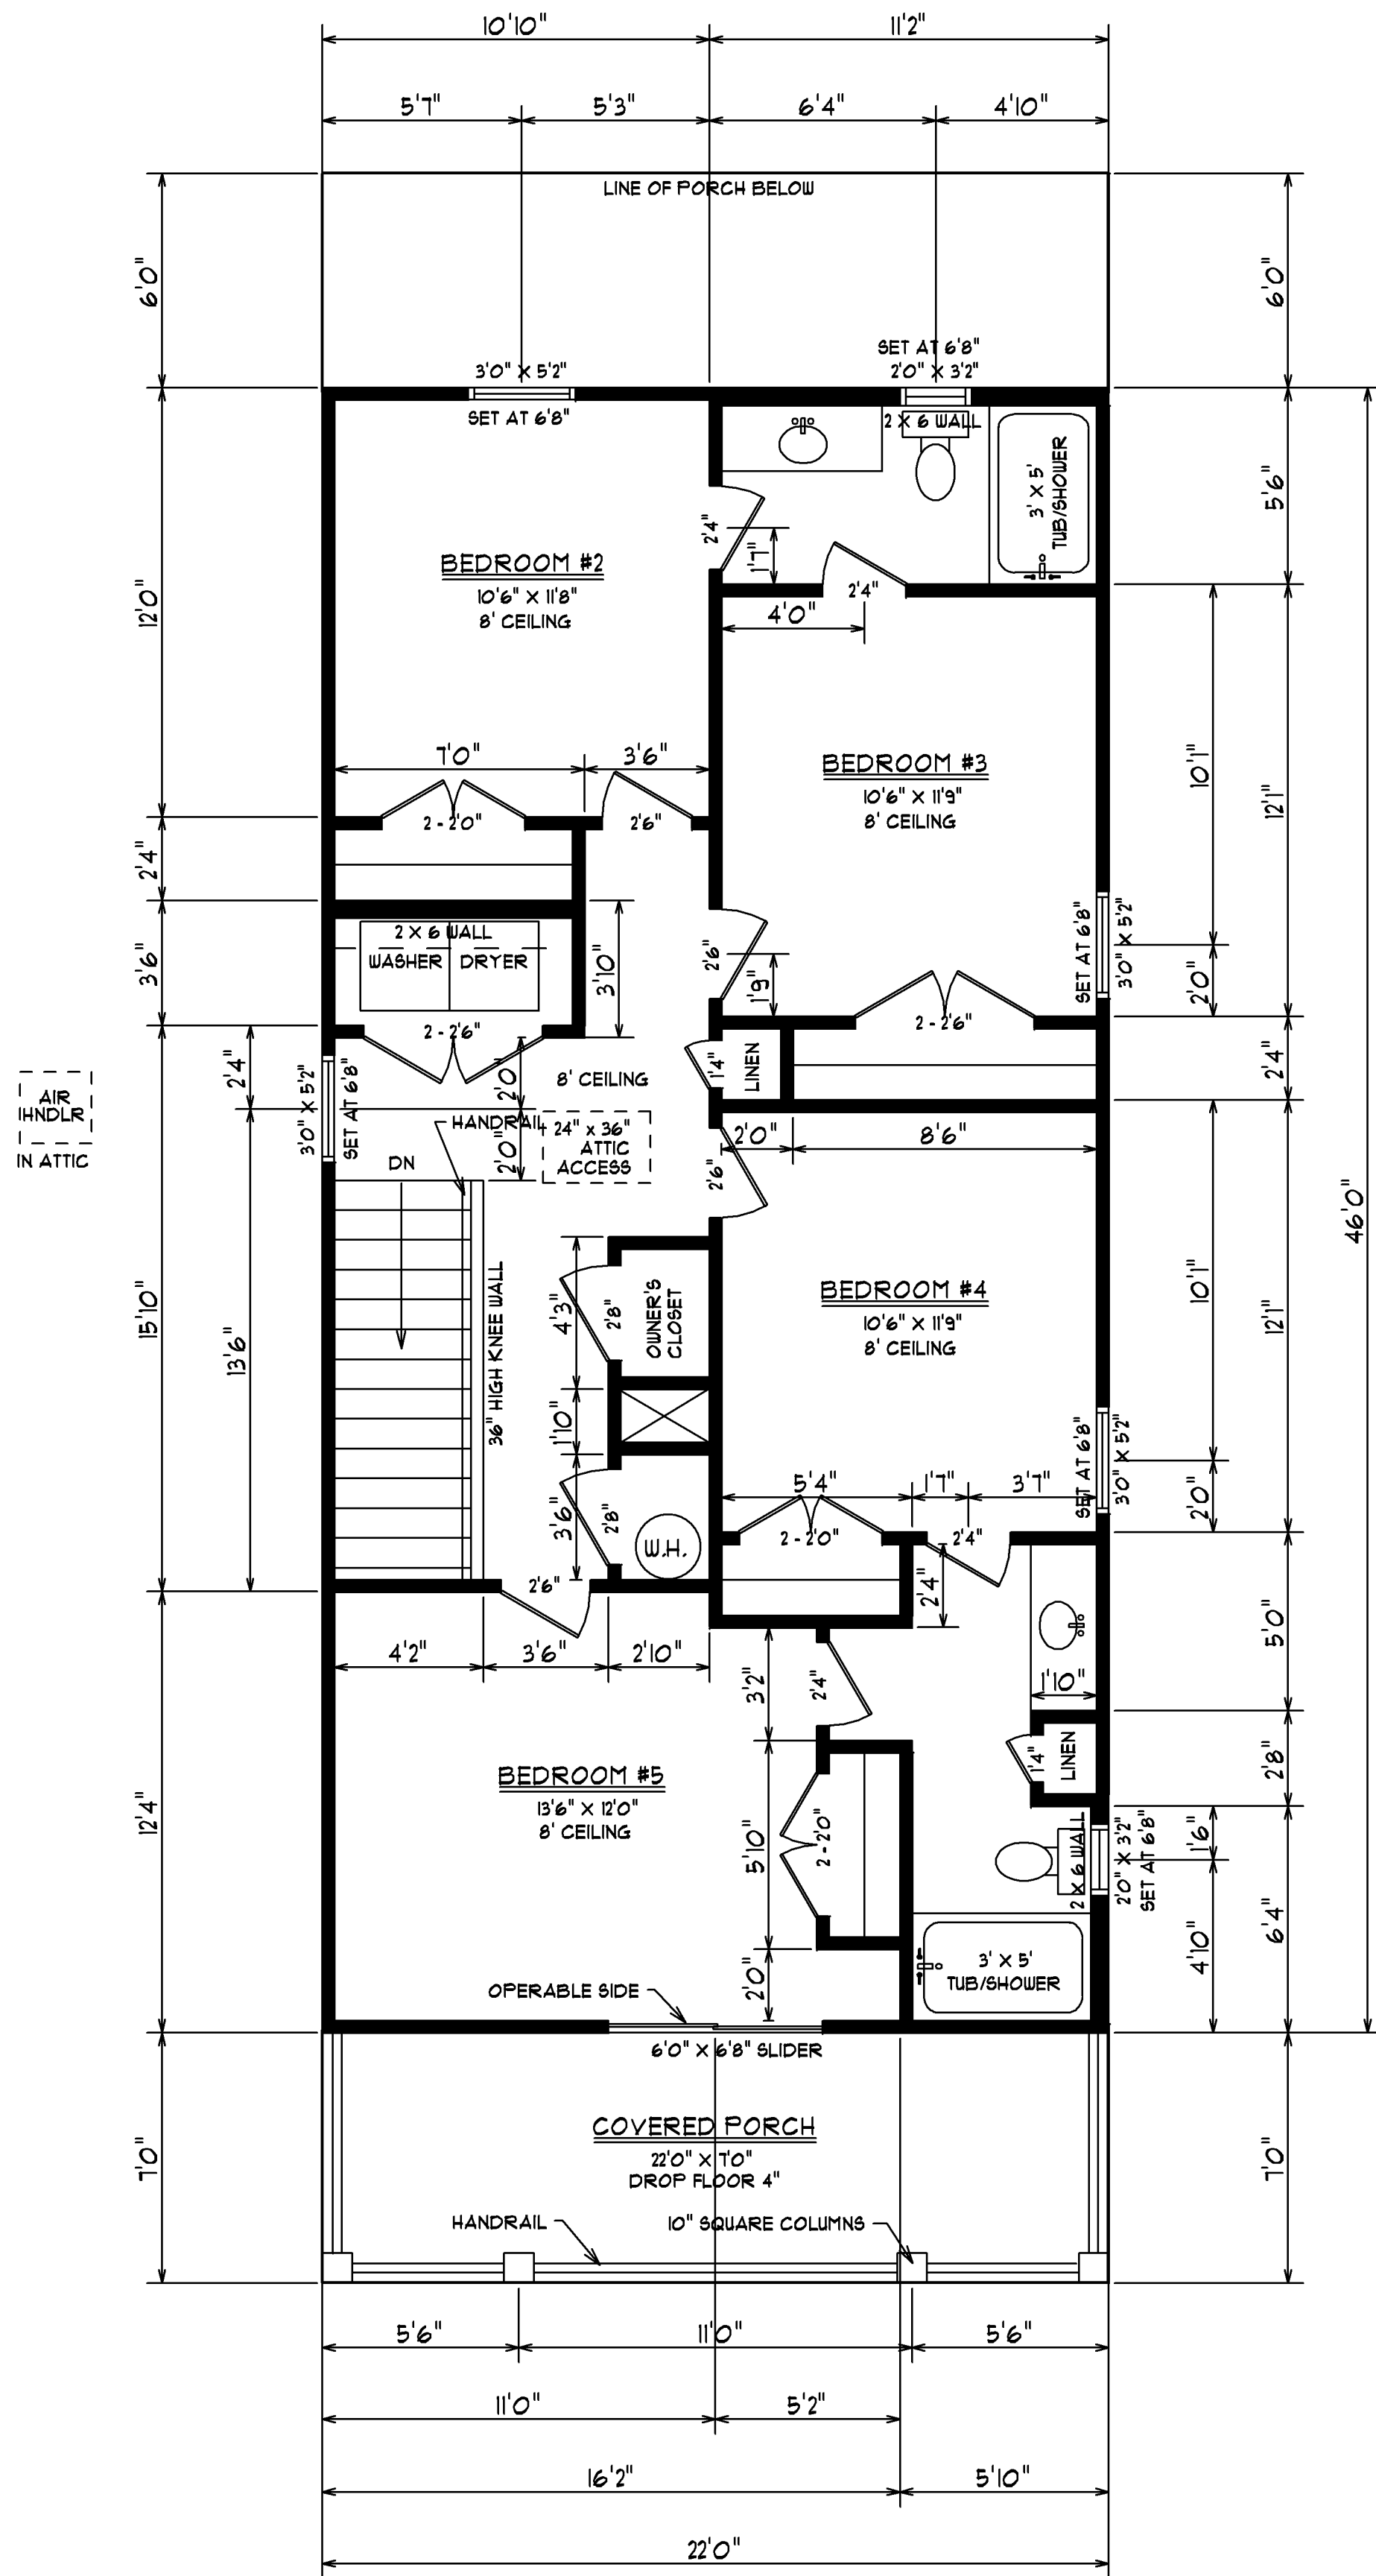

SECOND FLOOR PLAN

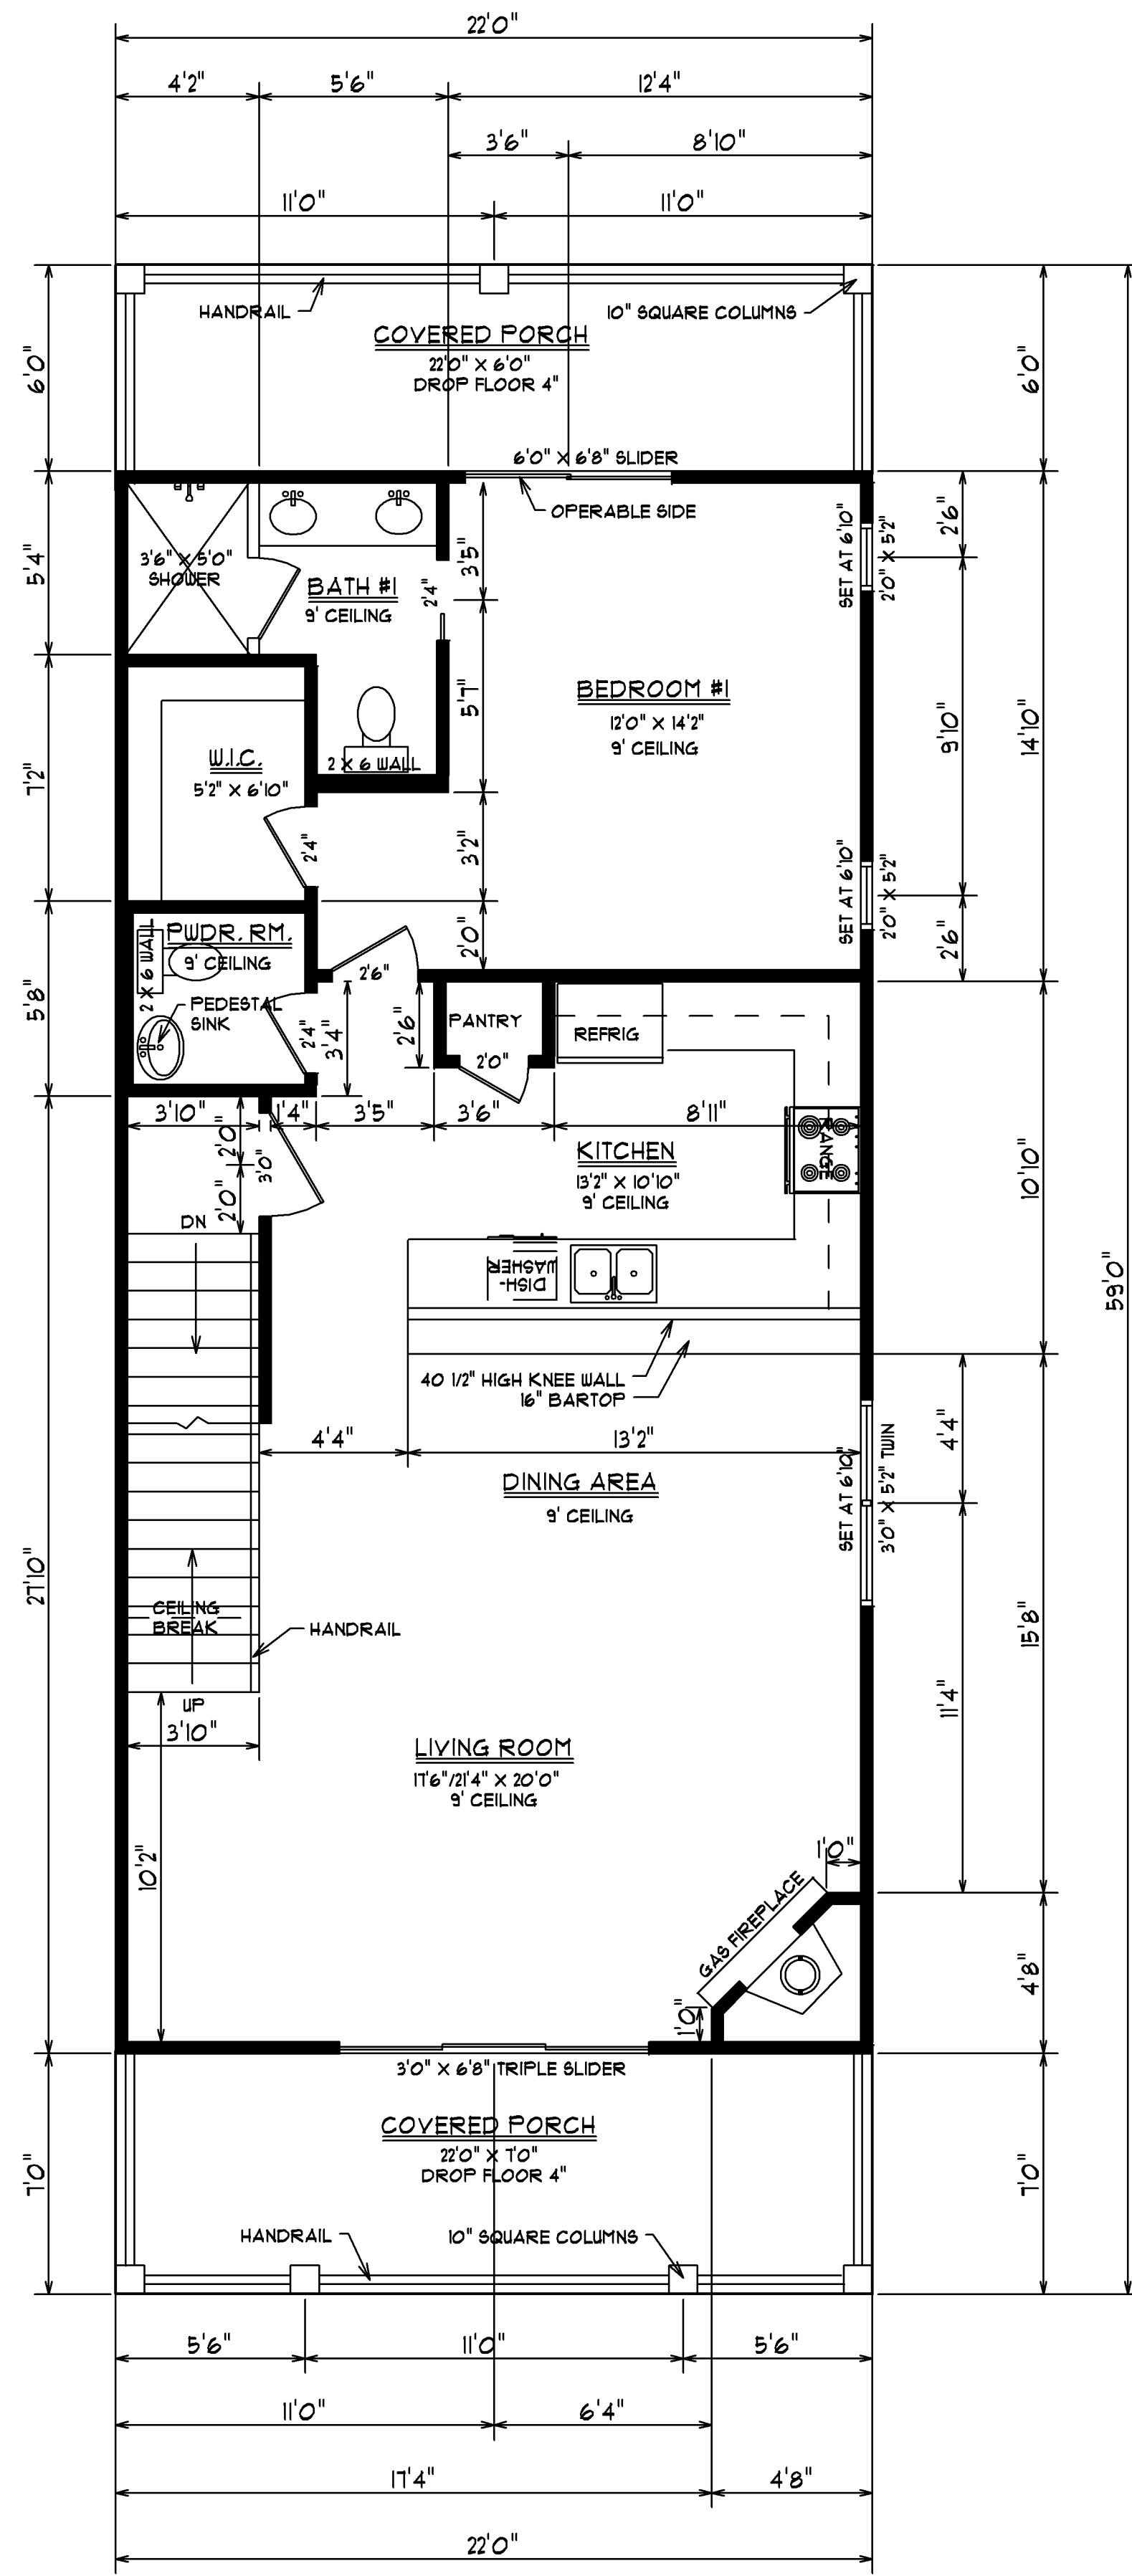

FIRST FLOOR PLAN

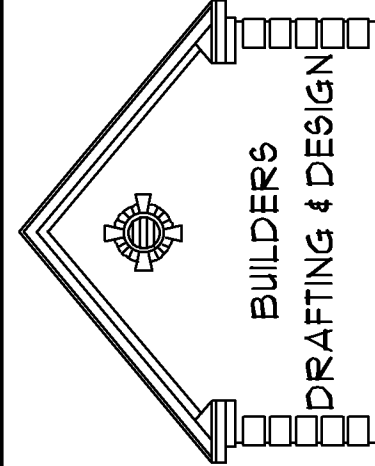

SCALE: 1/4" = 1'0"



DATE: 1/31/23

SHEET #3
FLOOR PLAN

JOB LOCATION:		1042	
LOT C CALHOUN DRIVE		1018	
GARDEN CITY, SC		2061	
SQUARE FOOTAGE:		310	
1ST FLOOR HEATED		440	
2ND FLOOR HEATED		2811	
TOTAL HEATED SPACE			
GARAGE			
COVERED PORCHES			
TOTAL UNDER ROOF			

PAULA BURGIN
1341 CROOKED OAK DRIVE
FAULEYS ISLAND, SC 29565
C: (843) 919-5500
C: (843) 283-3113
BURGINPAULA@aol.com

<u>ELECTRICAL LEGEND</u>	
<u>SYMBOL</u>	<u>DESCRIPTION</u>
	LIGHT
	RECESSED CAN LIGHT
\$	SWITCH
\$3	3-WAY SWITCH
	220 OUTLET
	110 OUTLET
	GROUND FAULT INTERRUPTER
	TELEVISION
	TELEPHONE
	BATH FAN/LIGHT
	BATH FAN ONLY
	GARBAGE DISPOSAL
	SPEAKER
	DOORBELL BUTTON
	SMOKE DETECTOR
	DOUBLE FLOOD LIGHT
	HOSE BIB
	PREWIRED FAN/LIGHT
PREWIRE FOR FAN/LIGHT	
ARC FAULT PROTECTION IN ALL ROOMS REQUIRED BY 2017 NEC CODE	

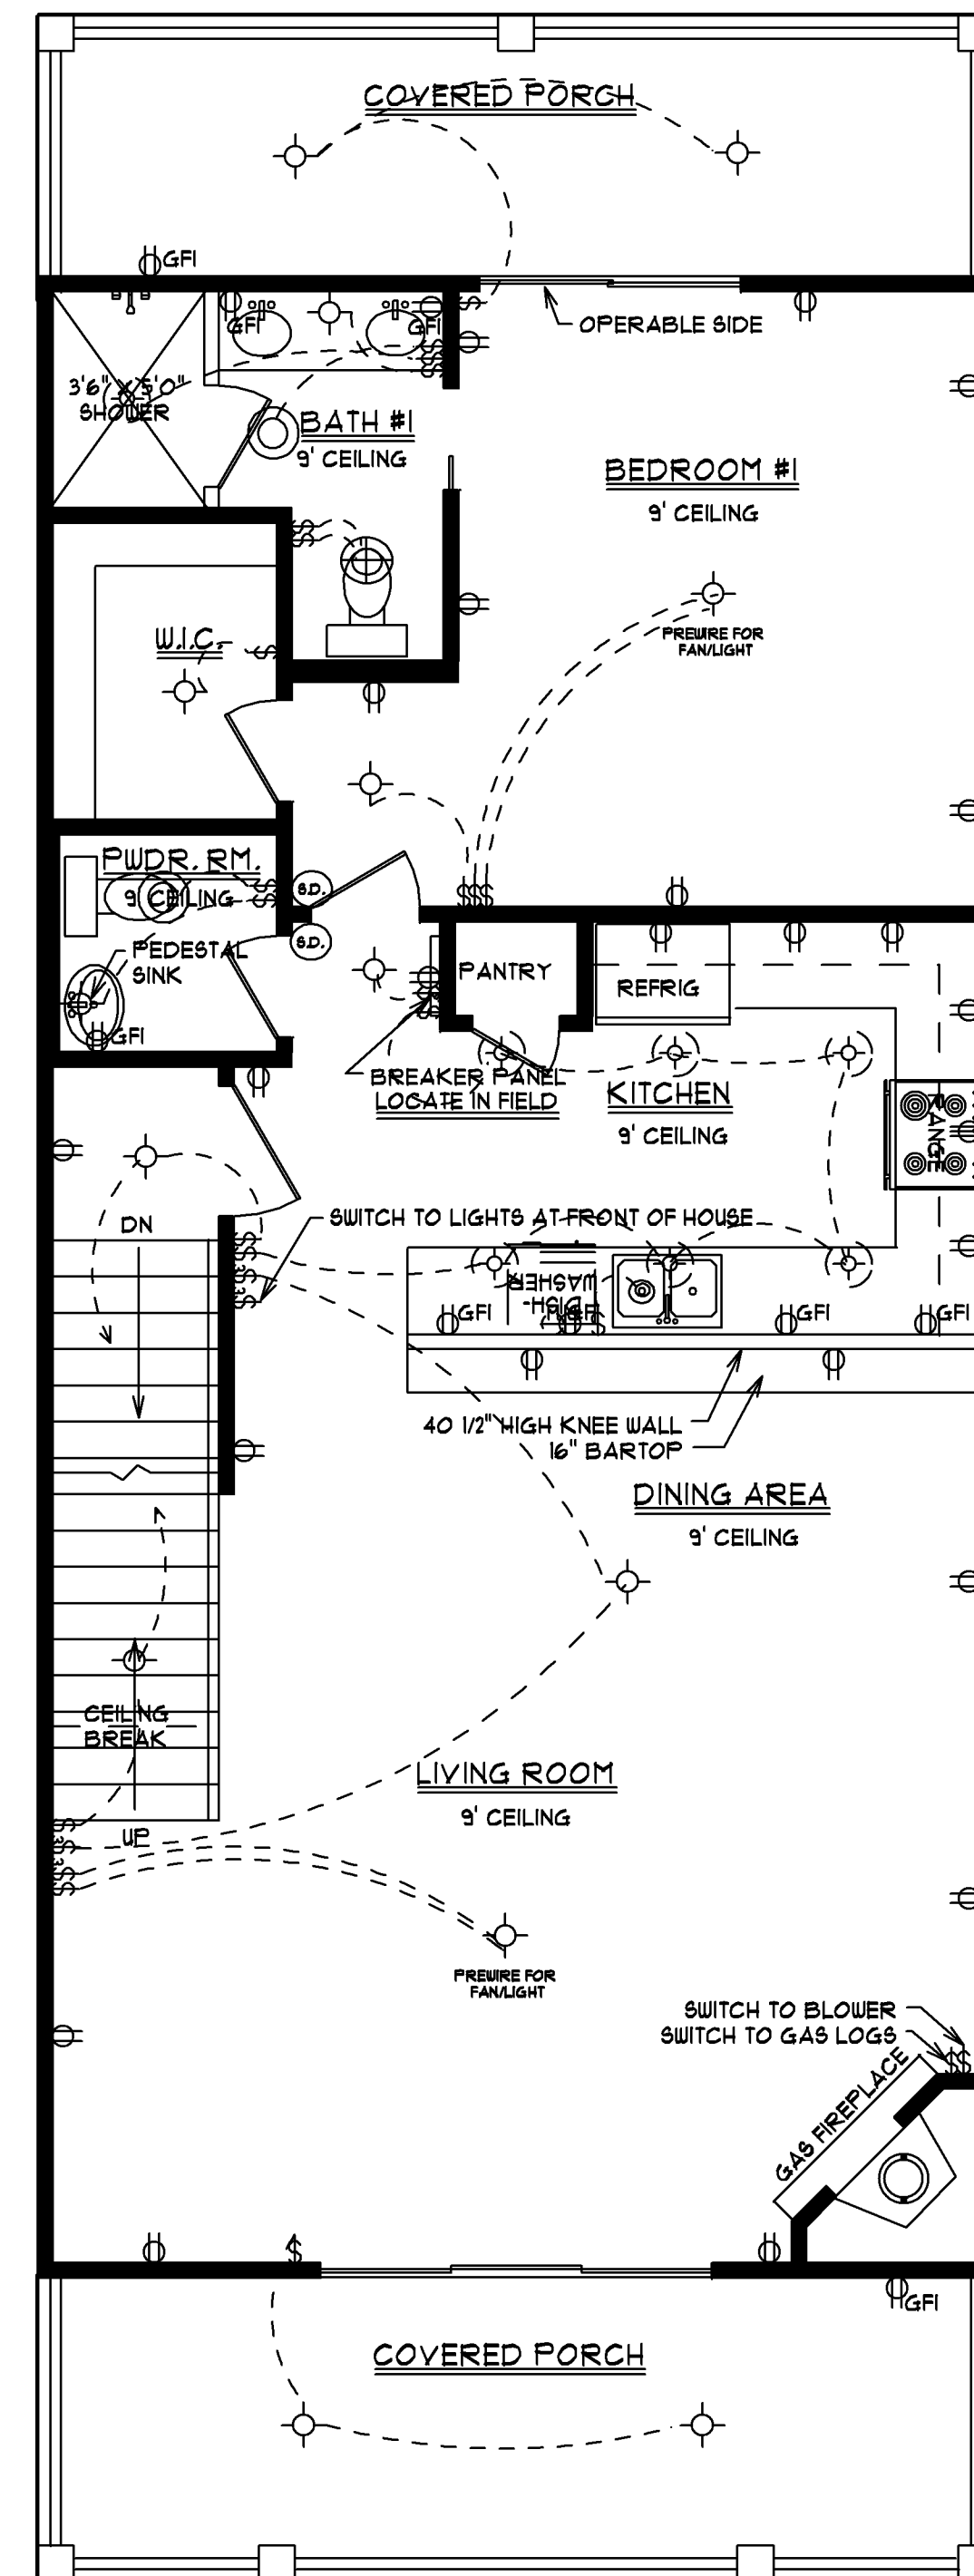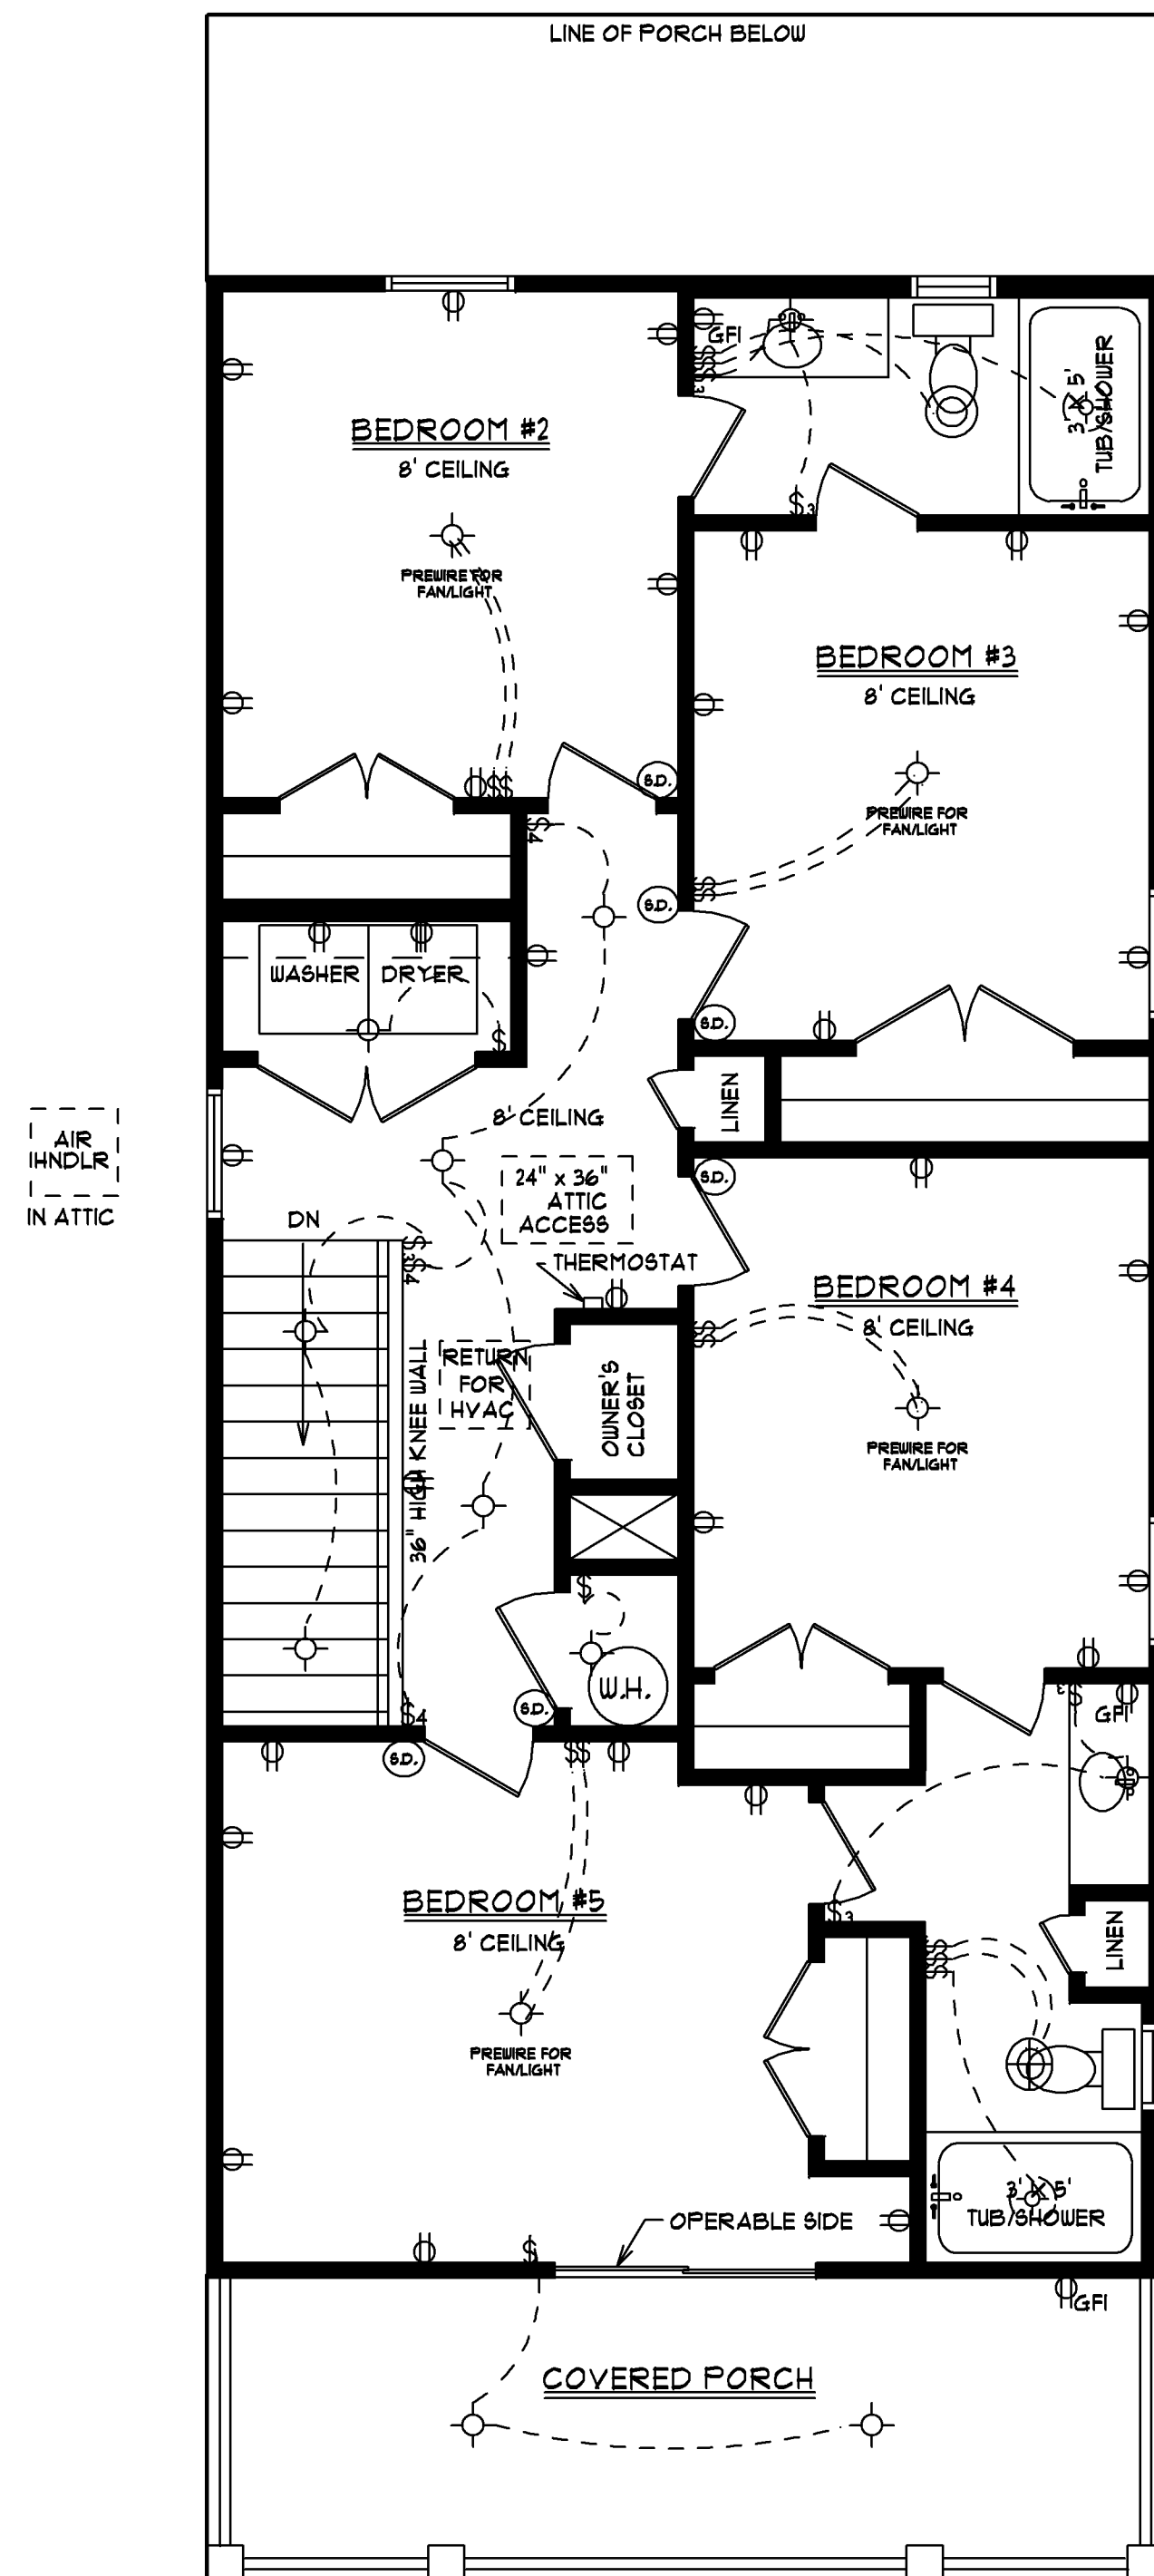

**BUILDERS
DRAFTING & DESIGN**

PAULA BURGIN
 1341 CROOKED OAK DRIVE
 PAULEY'S ISLAND, SC 29585
 OR 843-318-5500
 C 843-283-3713
 BURGINPAULA@AOL.COM

SCALE: $1/4" = 1'0"$




DATE:1/31/23

TEETH

ELECTRICAL

JOB LOCATION:
LOT C CALHOUN DRIVE
GARDEN CITY, SC

SQUARE FOOTAGE:	
1ST FLOOR HEATED	1042
2ND FLOOR HEATED	1019
TOTAL HEATED SPACE	<u>2061</u>
GARAGE	310
COVERED PORCHES	<u>440</u>
TOTAL UNDER ROOF	2811

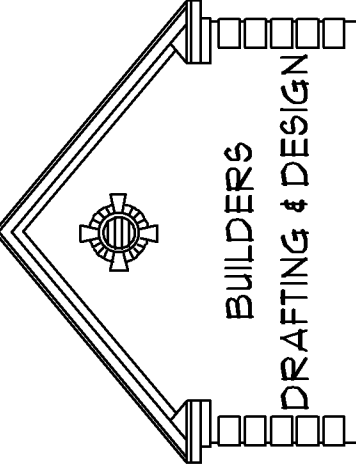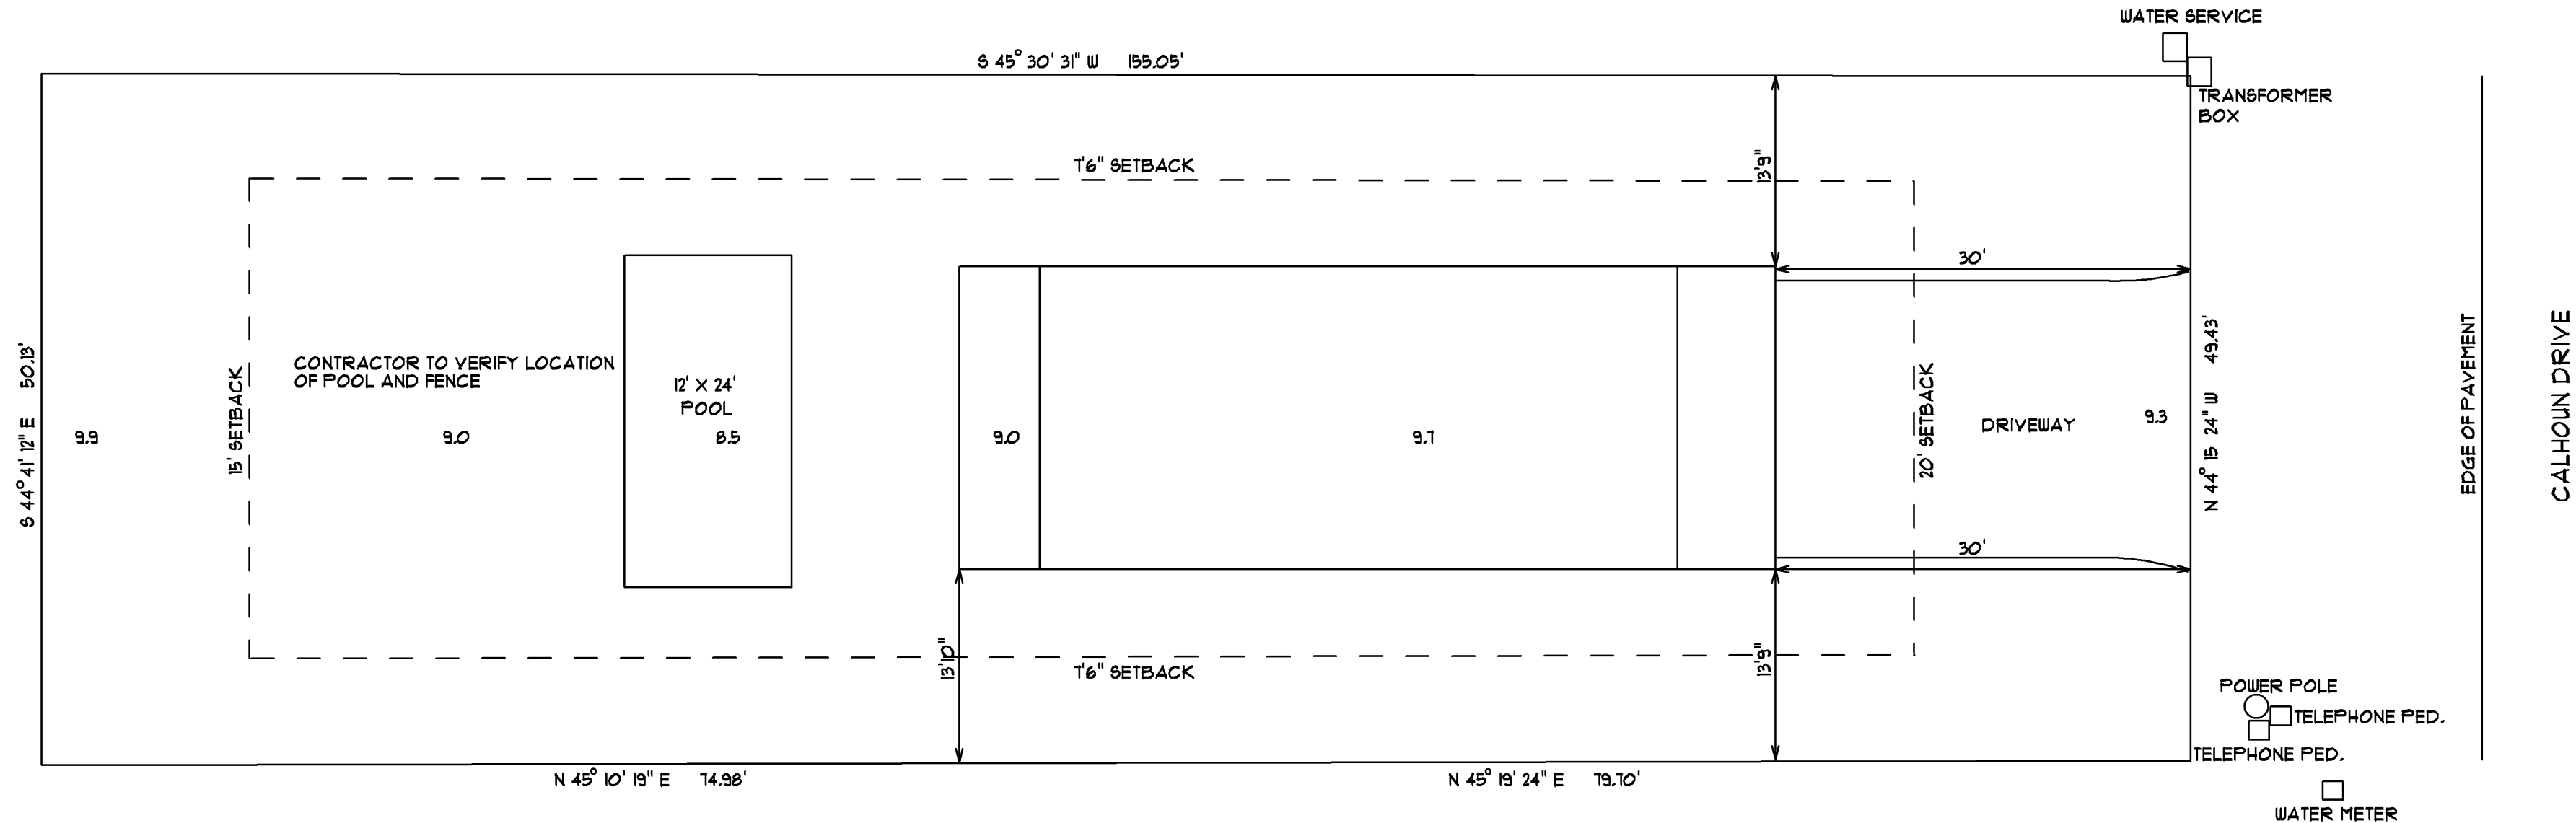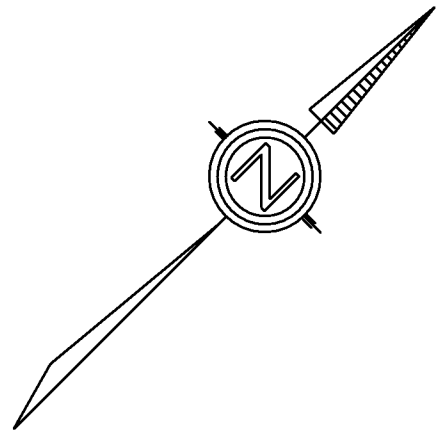

PAULA BURGIN
1341 CROOKED OAK DRIVE
FAULEYS ISLAND, SC 29565
O: (843) 919 - 5500
C: (843) 283 - 3113
BURGINPAULA@AOL.COM

SCALE: 1" = 10'

DATE: 2/20/23

SHEET #5
PLOT PLAN

JOB LOCATION:
LOT C CALHOUN DRIVE
GARDEN CITY, SC

SQUARE FOOTAGE:	
1ST FLOOR HEATED	1042
2ND FLOOR HEATED	1019
TOTAL HEATED SPACE	2061
GARAGE	310
COVERED PORCHES	440
TOTAL UNDER ROOF	2811