
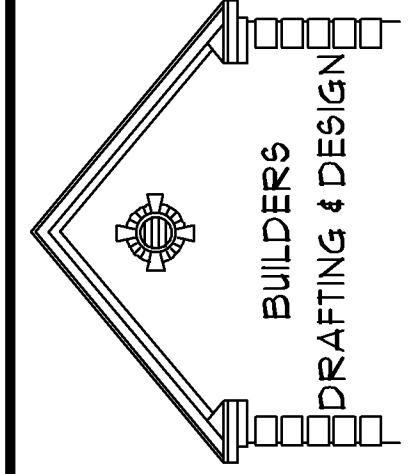
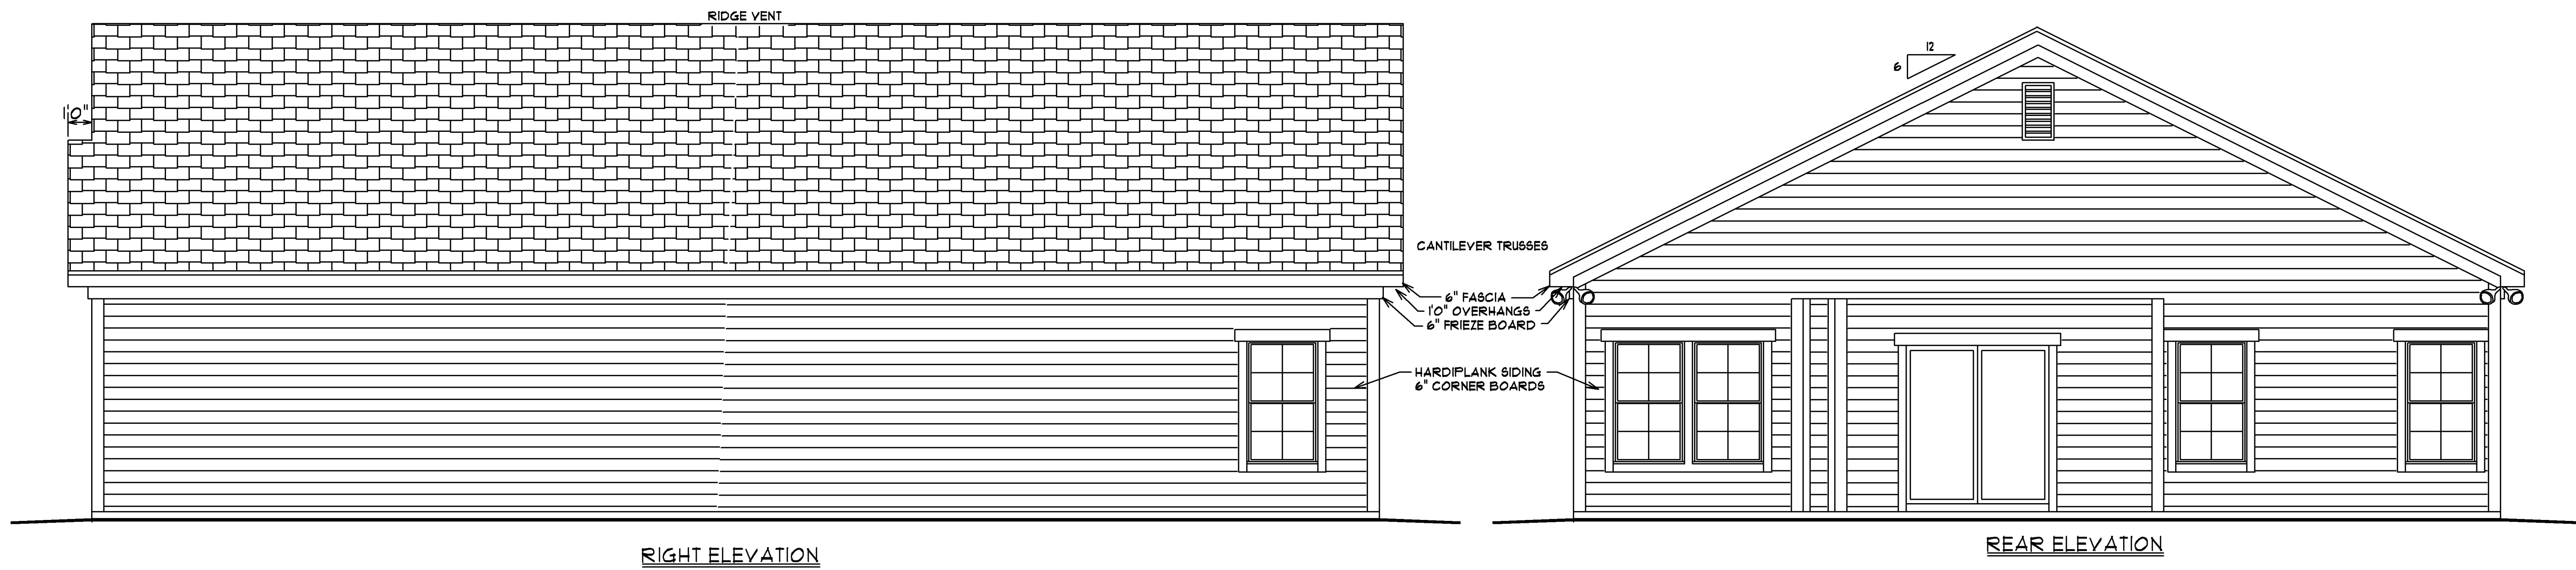


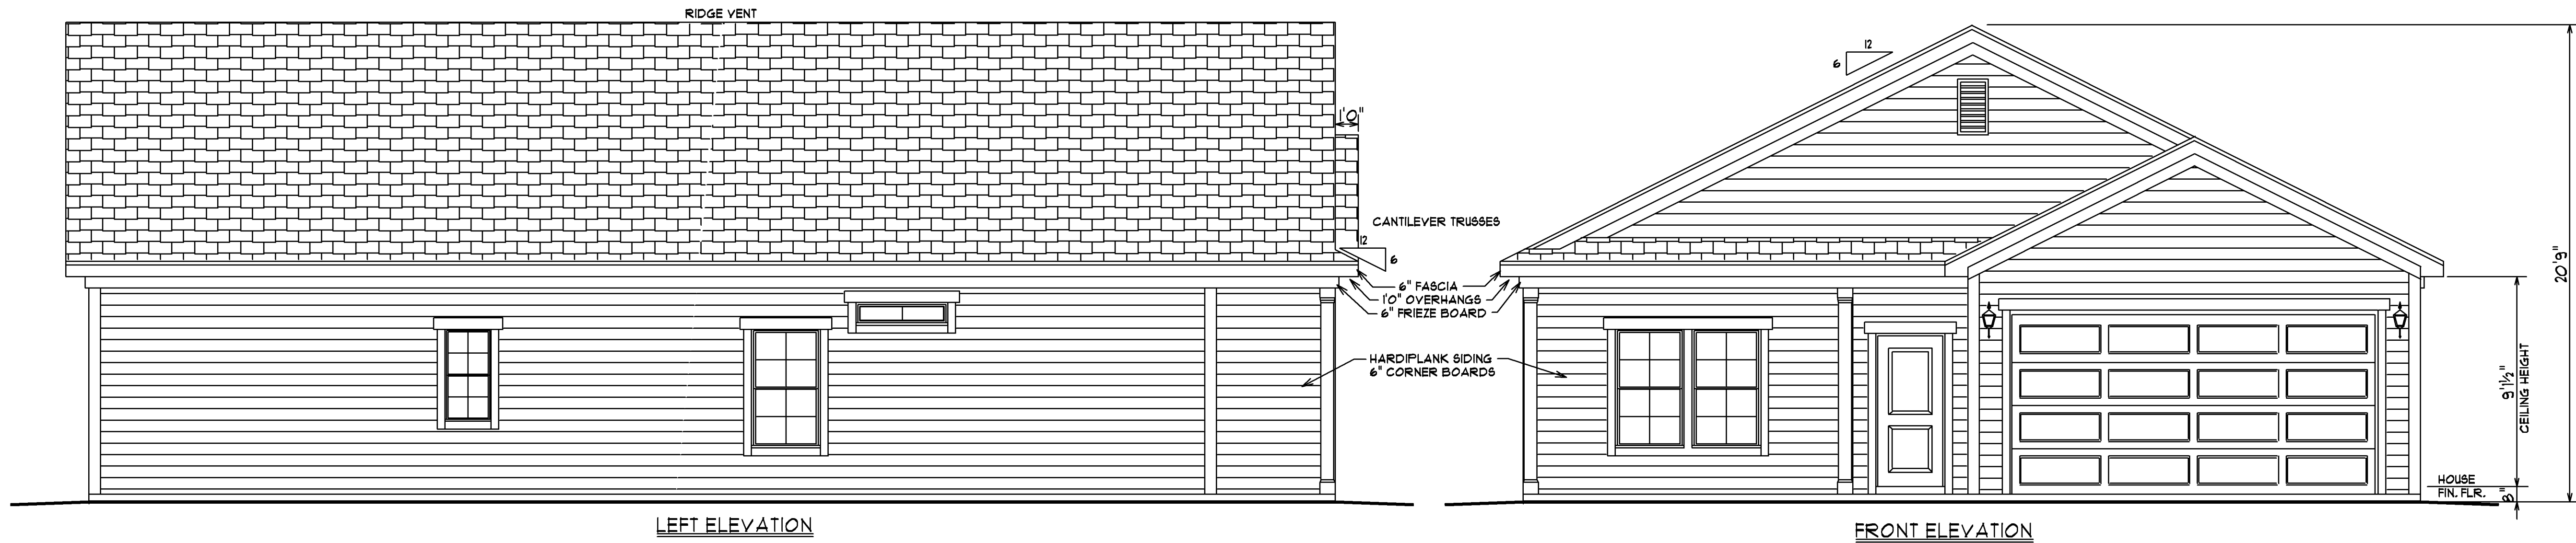

PAULA BURGIN
1341 CROOKED OAK DRIVE
PAULEY'S ISLAND, SC 29585
C(843) 979 - 5500
C(843) 283 - 3713
BURGINPAULA@aol.com

SCALE: 1/4" = 1'0"

DATE 3/20/24

SHEET #1



ELEVATIONS

JOB LOCATION:
LOT #114 AUTUMN DRIVE
THE PINES OF ST. JAMES
MYRTLE BEACH, SC

SQUARE FOOTAGE:	1400	
	441	
	140	
	131	
	212	
HEATED SPACE		
GARAGE		
ENTRY PORCH		
COVERED PORCH		
TOTAL UNDER ROOF		

EXPERT
PROPERTIES LLC

ELECTRICAL LEGEND	
SYMBOL	DESCRIPTION
	LIGHT
	RECESSED CAN LIGHT
\$	SWITCH
\$3	3-WAY SWITCH
	220 OUTLET
	110 OUTLET
	GROUND FAULT INTERRUPTER
	TELEVISION
	TELEPHONE
	BATH FAN/LIGHT
	BATH FAN ONLY
	GARBAGE DISPOSAL
	SPEAKER
	DOORBELL BUTTON
	SMOKE DETECTOR
	DOUBLE FLOOD LIGHT
	HOSE BIB
	PREWIRED FAN/LIGHT

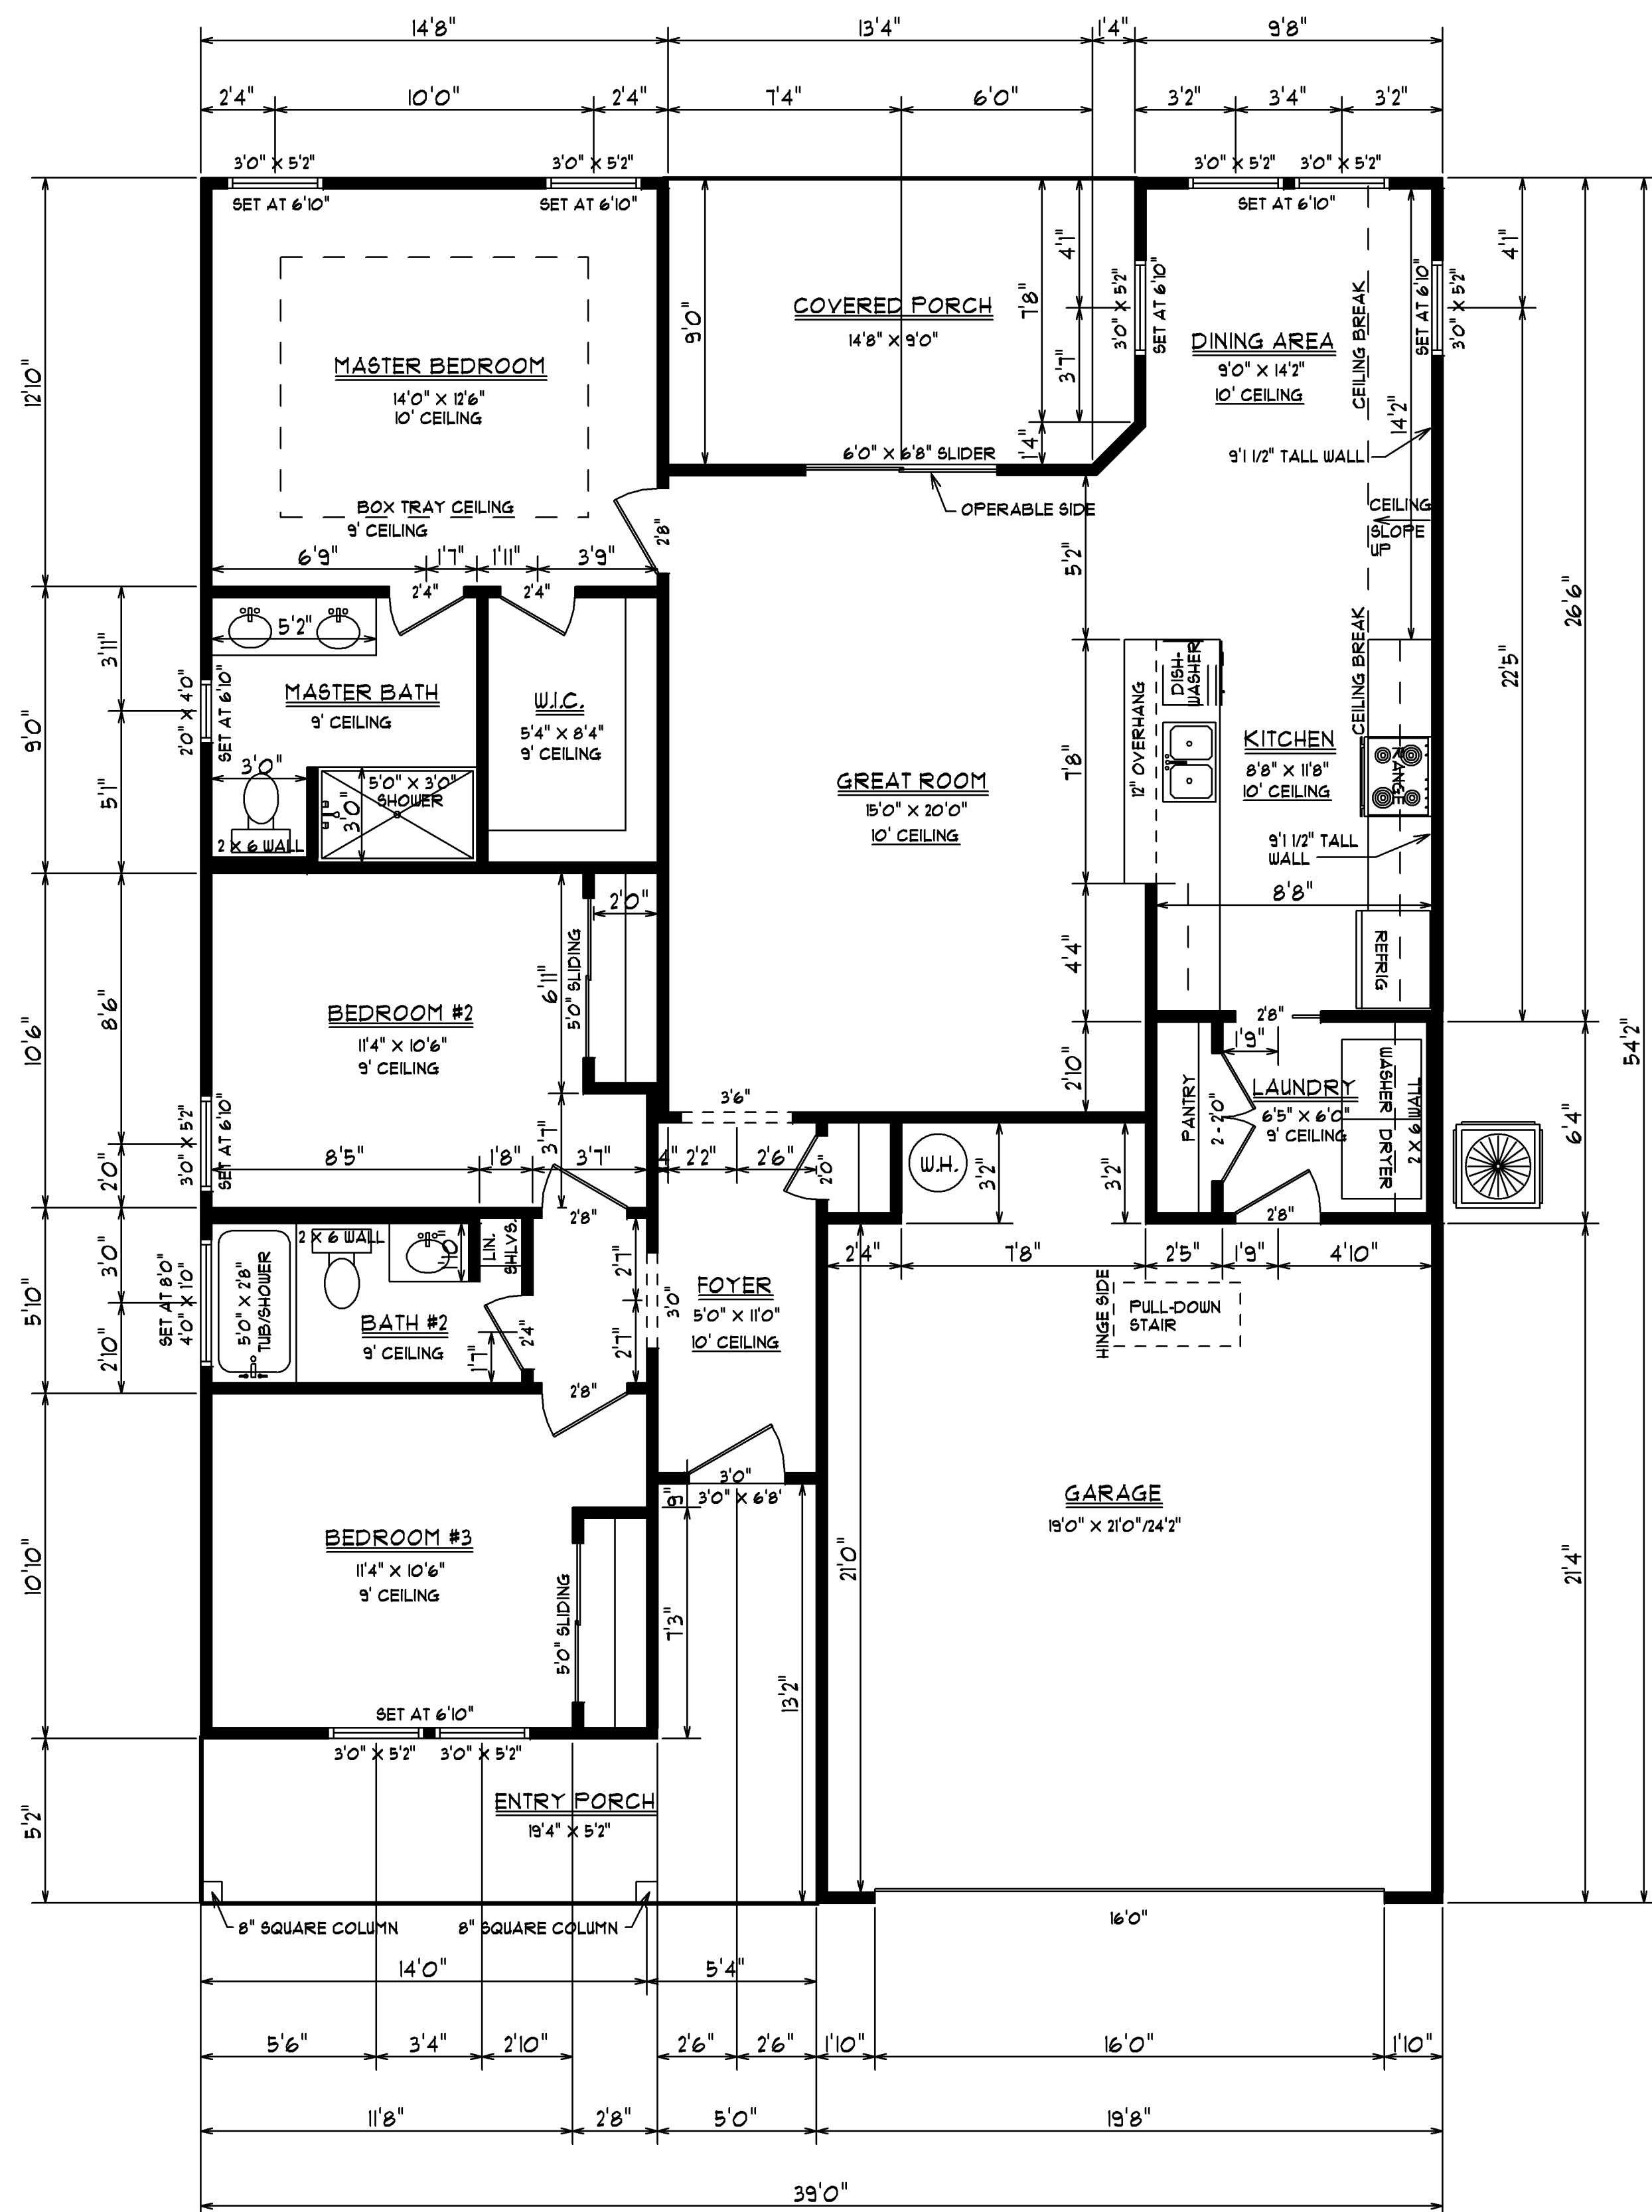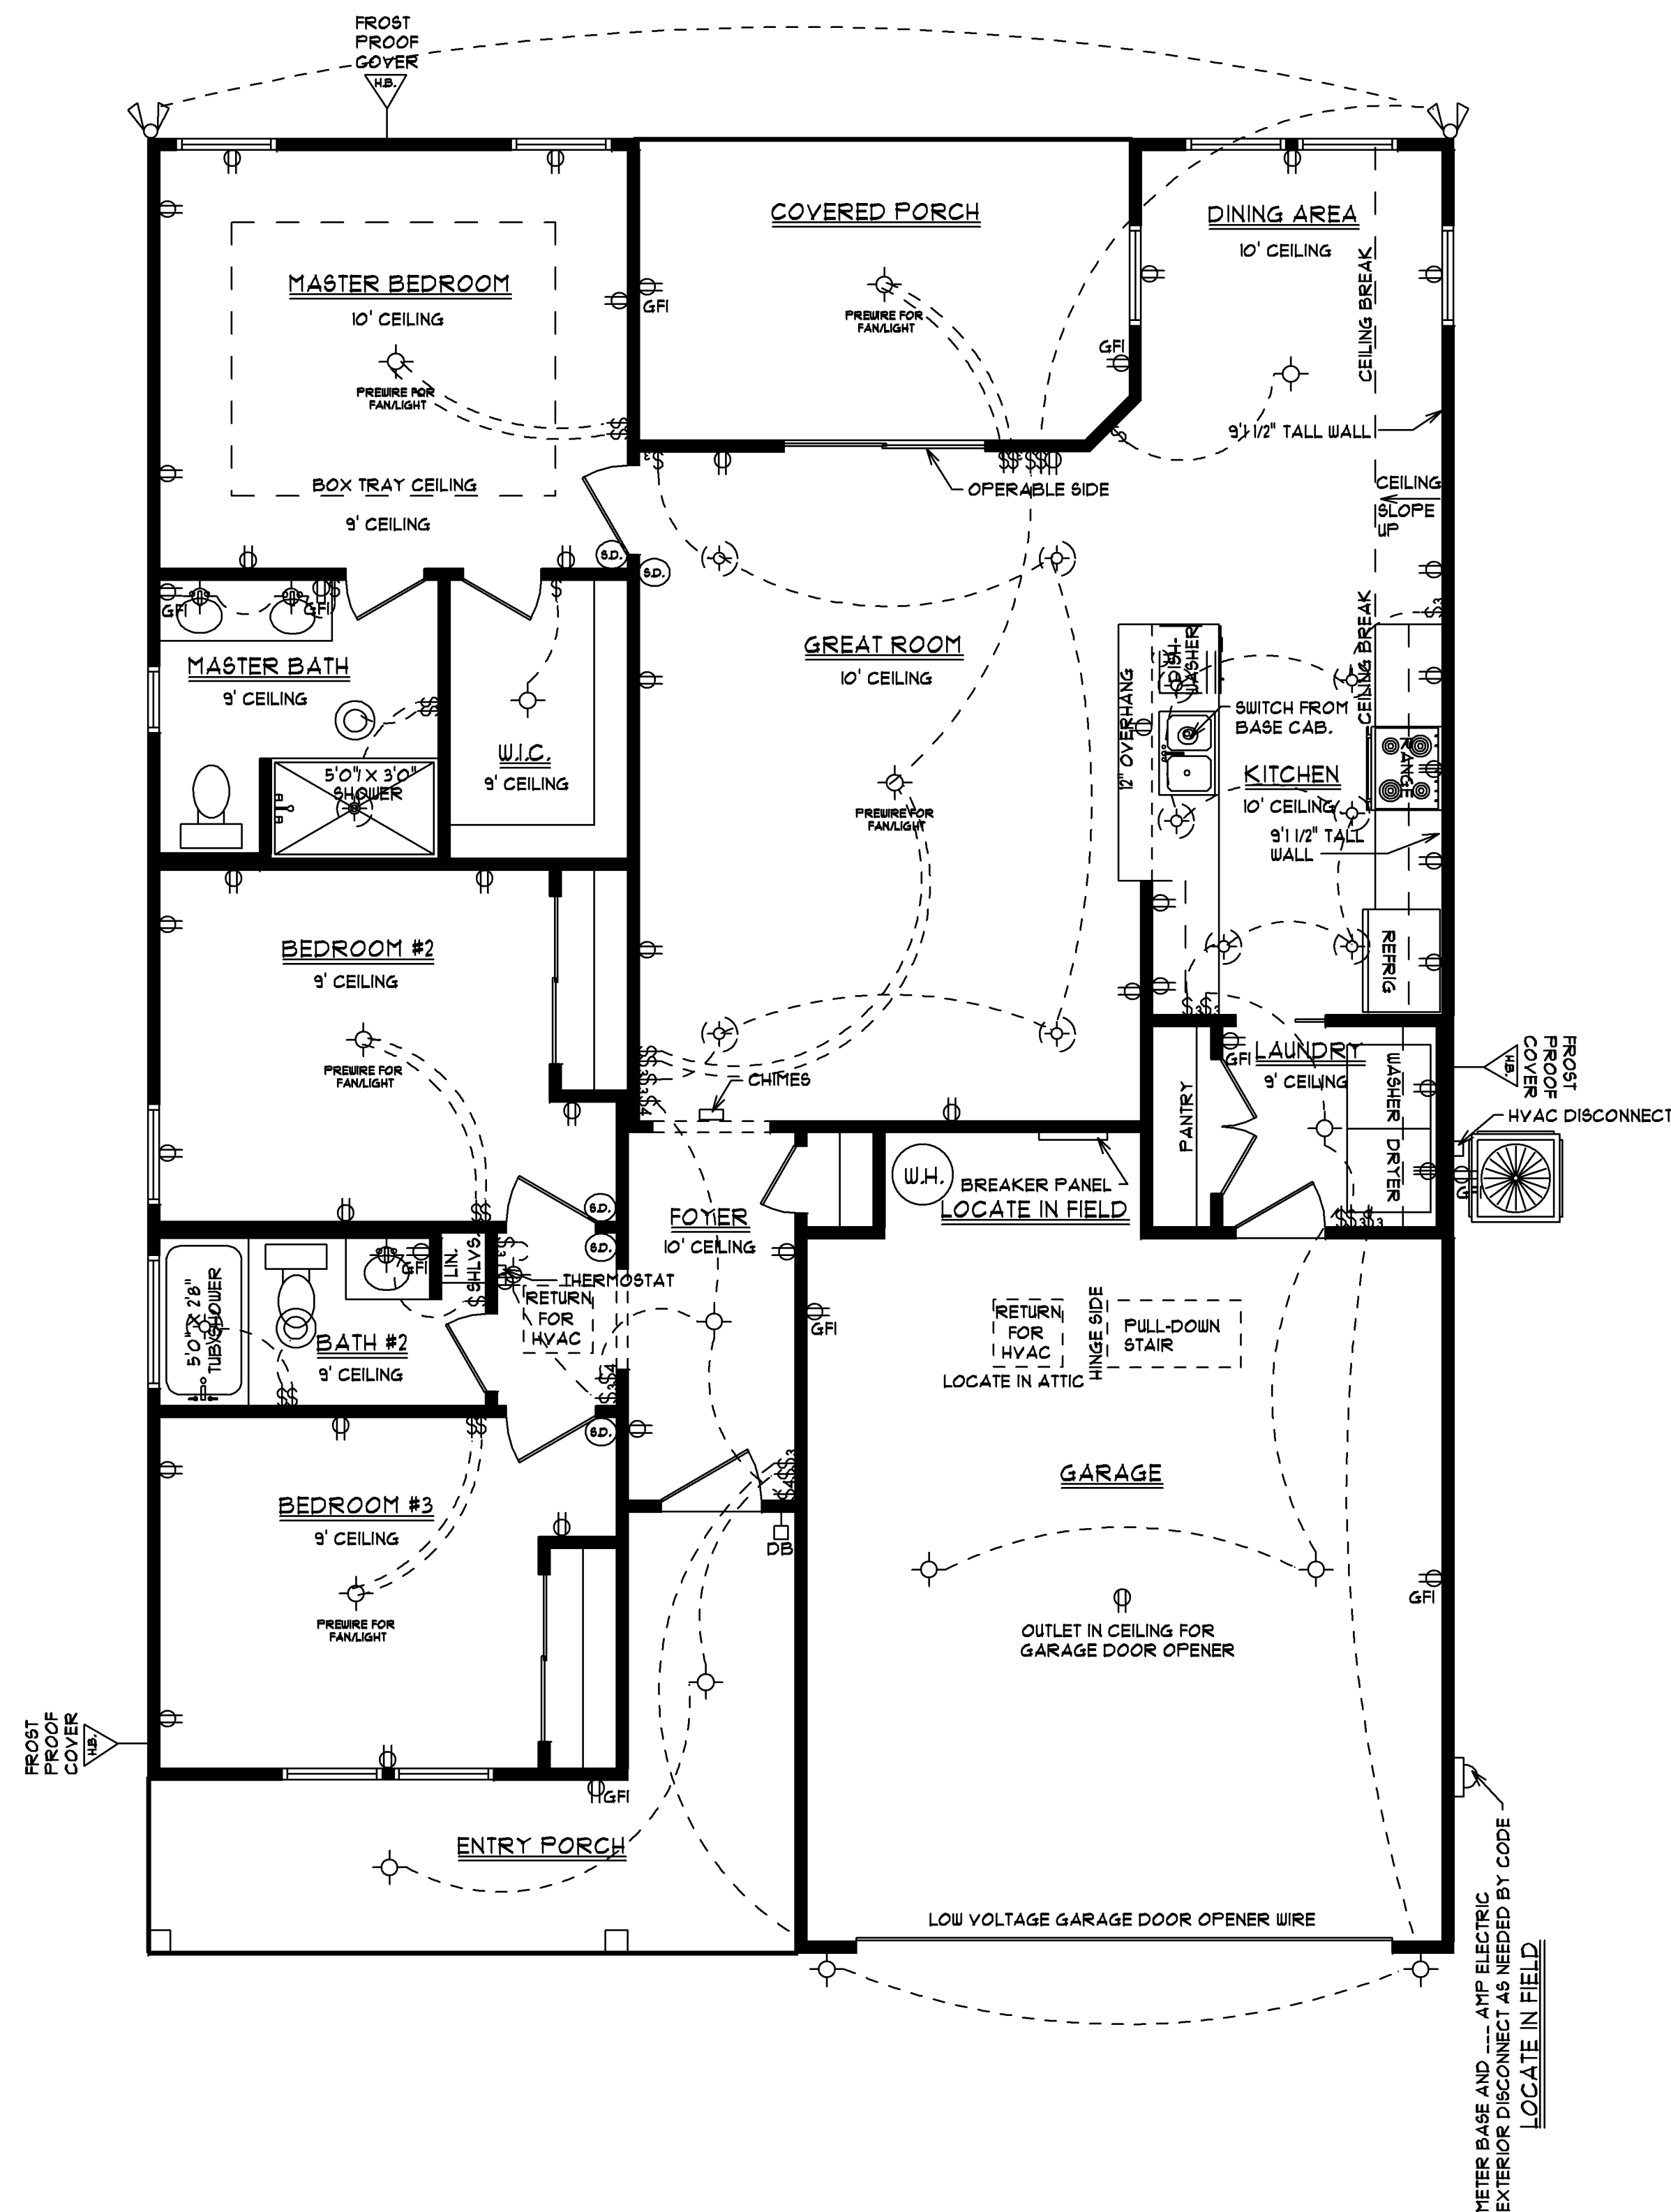

PROPERTIES
EXPERT

SQUARE FOOTAGE:
HEATED SPACE
GARAGE
ENTRY PORCH
COVERED PORCH
TOTAL UNDER ROOF


JOB LOCATION:
LOT #174 AUTUMN DRIVE
THE PINES OF ST. JAMES
MYRTLE BEACH, SC

SHEET #2




FLOOR PLAN/
ELECTRICAL

DATE:3/20/24

SCALE: 1/4" = 1'0"

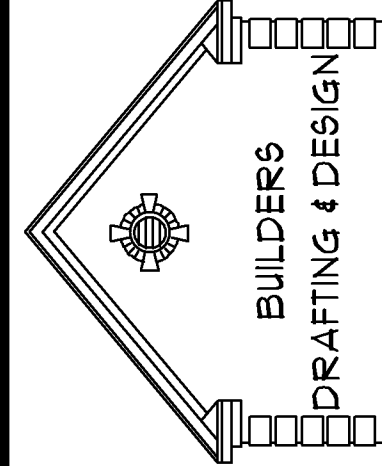

PAULA BURGIN
1341 CROOKED OAK DRIVE
PAWLEY'S ISLAND, SC 29585
O (843) 979 - 5500
C (843) 283 - 3773
BURGINPAULA@AOL.COM

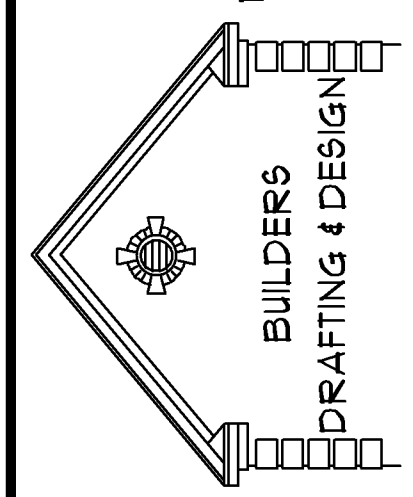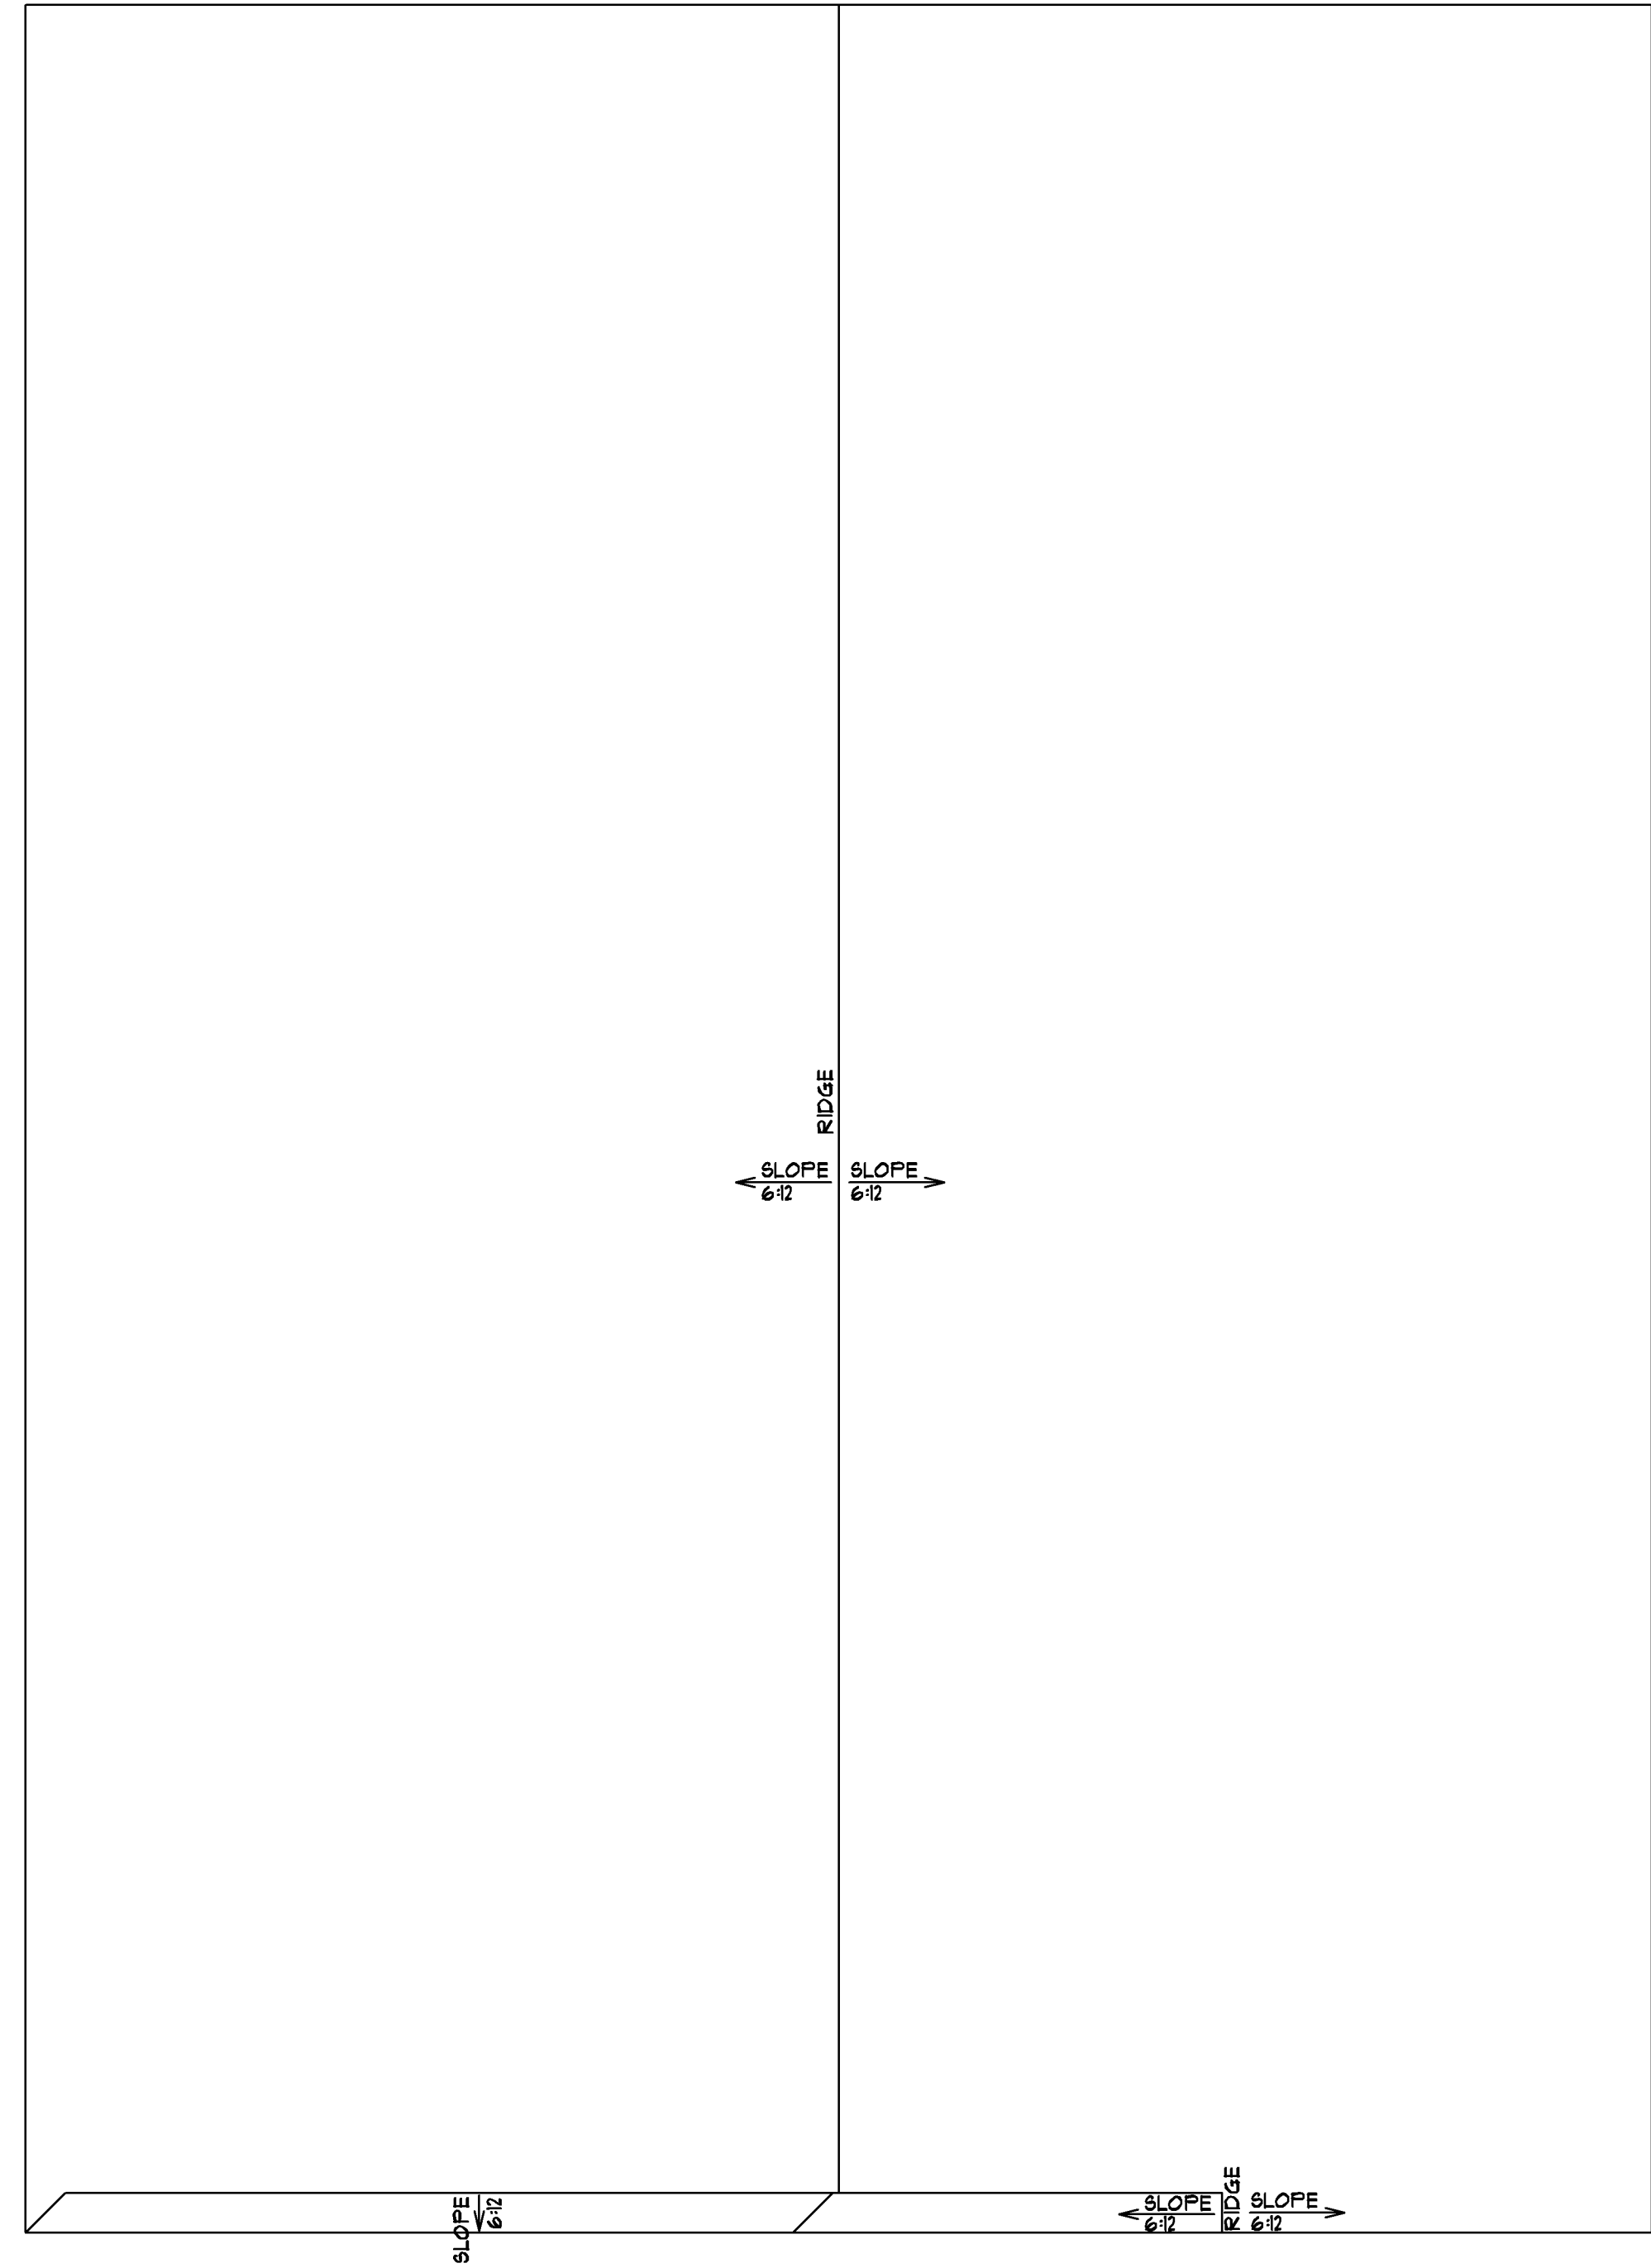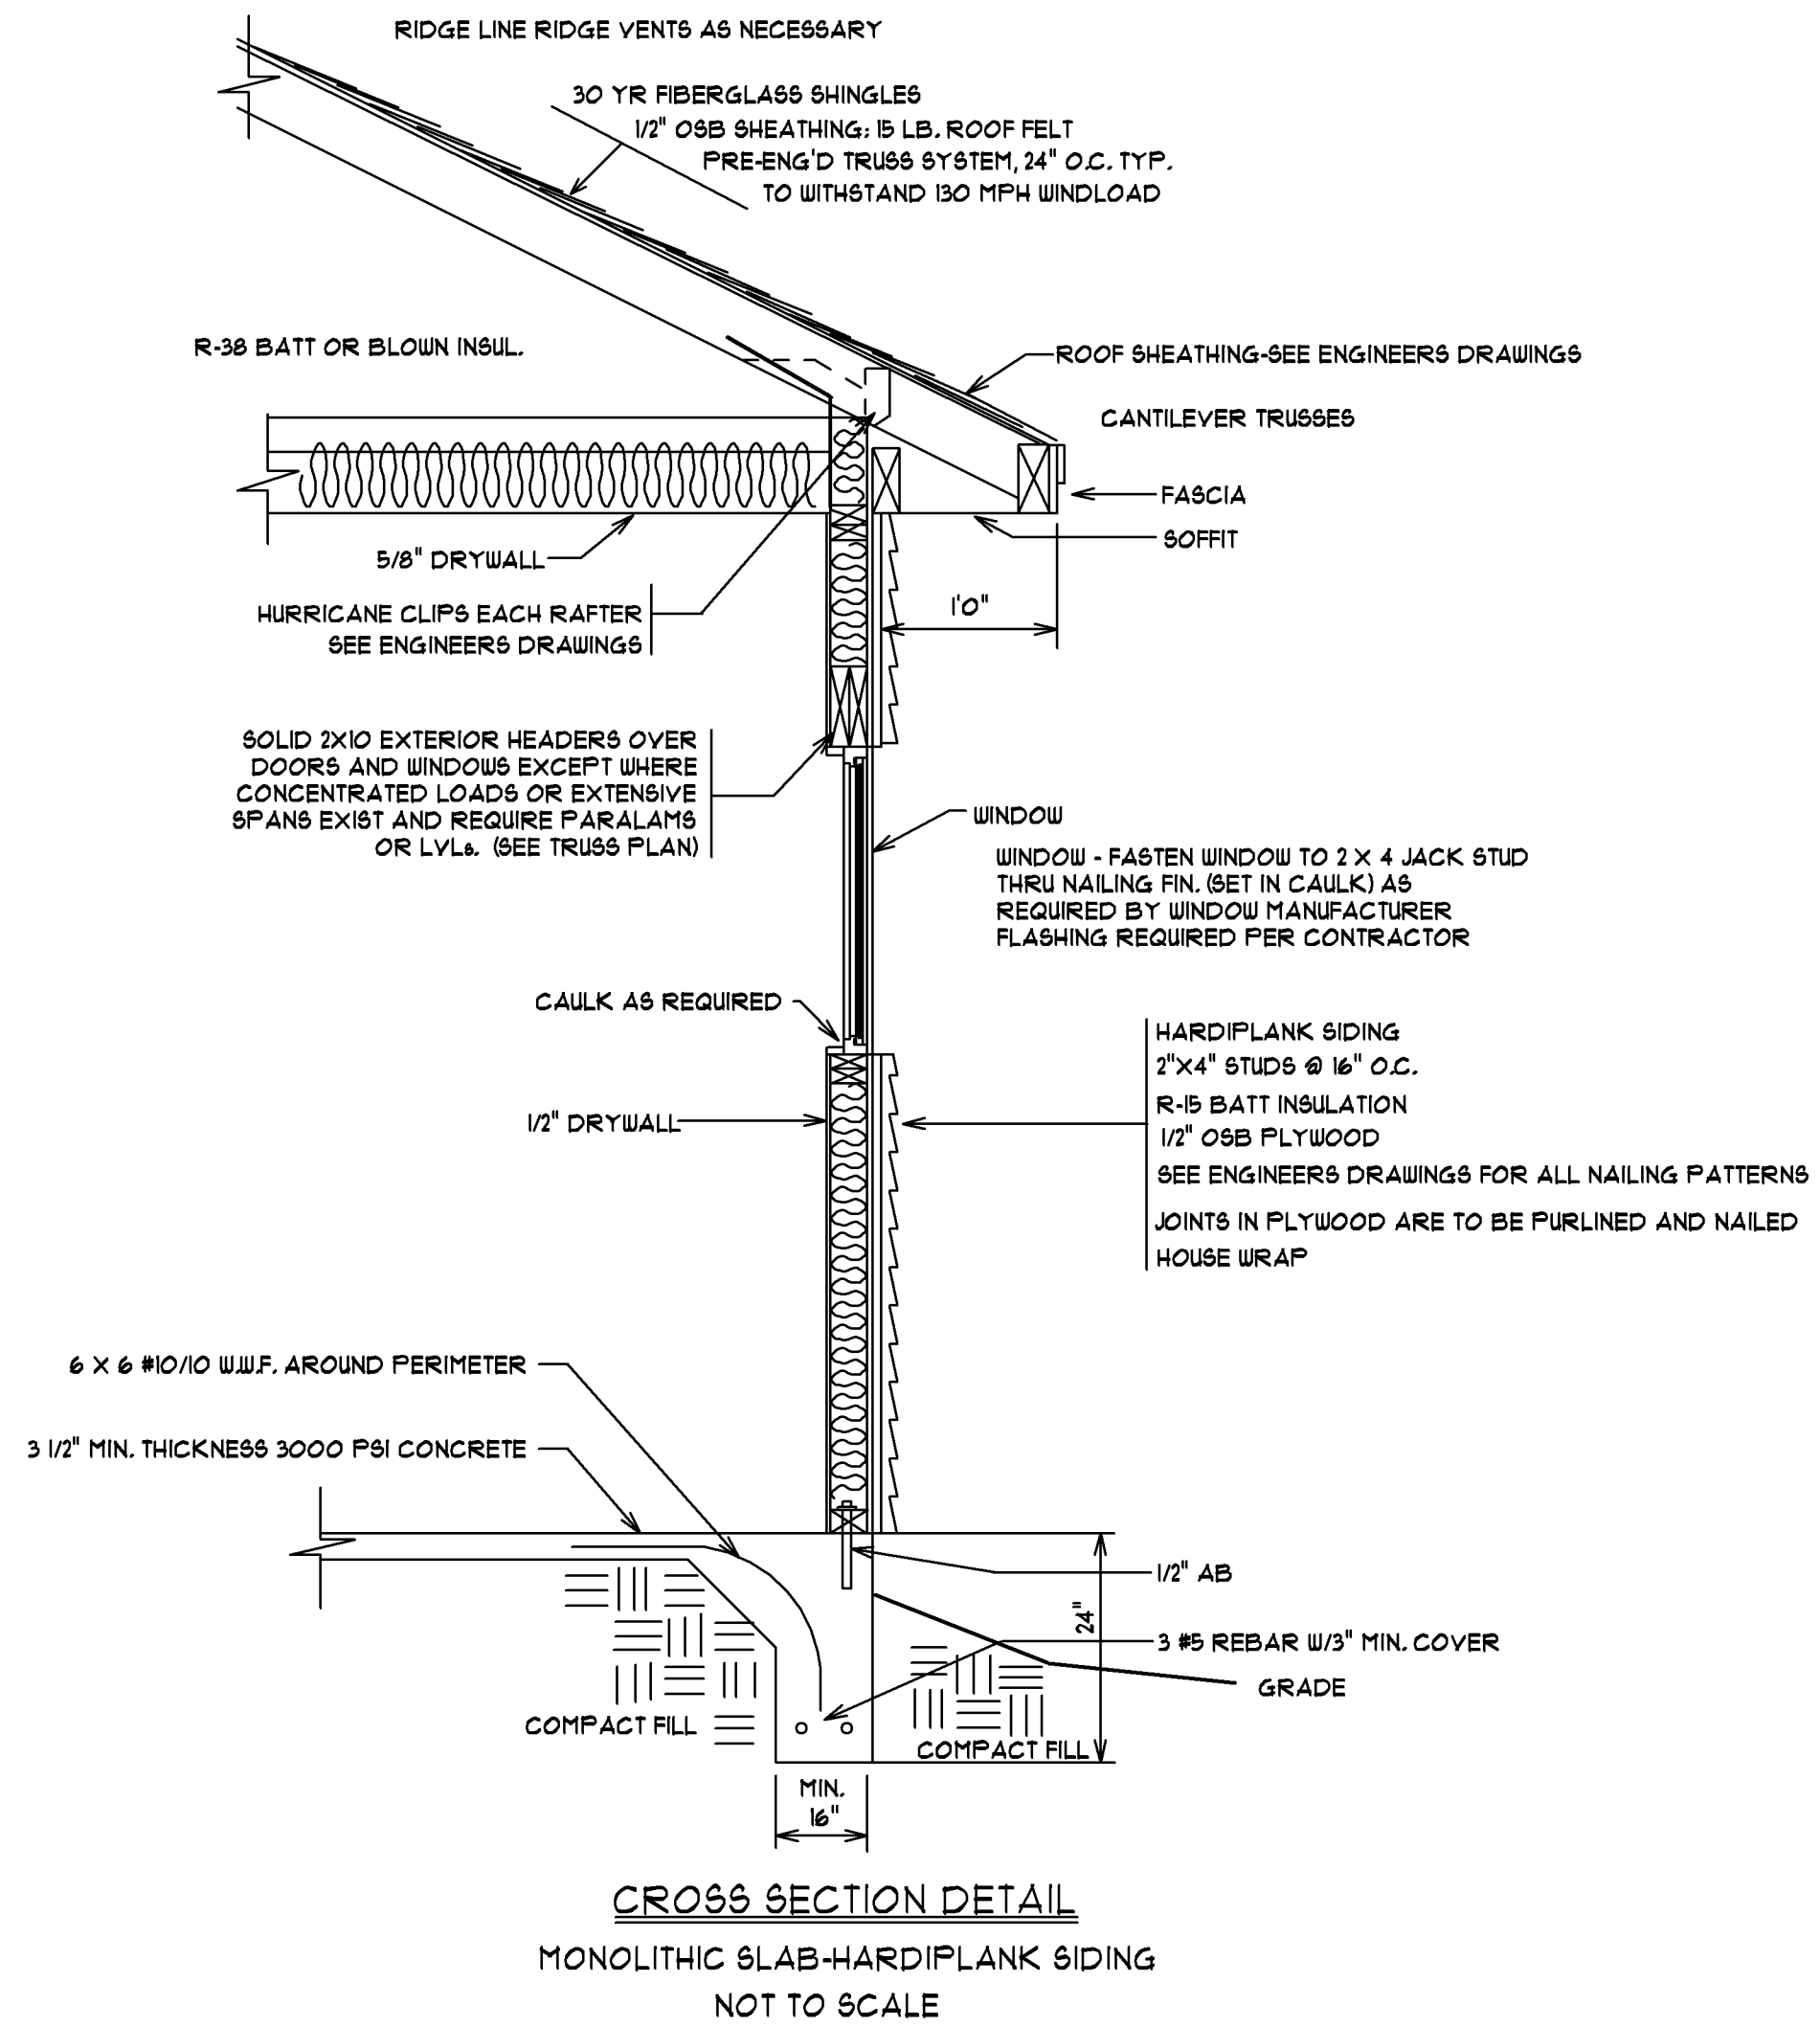

PAULA BURGIN
1341 CROOKED OAK DRIVE
PAULEY'S ISLAND, SC 29565
C: (843) 979 - 5500
C: (843) 283 - 3713
BURGINPAULA@aol.com

SCALE: 1/4" = 1'0"

DATE 3/20/24

SHEET #3

ROOF PLAN/
DETAIL




JOB LOCATION:

LOT #14 AUTUMN DRIVE
THE PINES OF ST. JAMES
MYRTLE BEACH, SC

SQUARE FOOTAGE:

HEATED SPACE	1400
GARAGE	441
ENTRY PORCH	140
COVERED PORCH	131
TOTAL UNDER ROOF	2112

EXPERT
PROPERTIES LLC

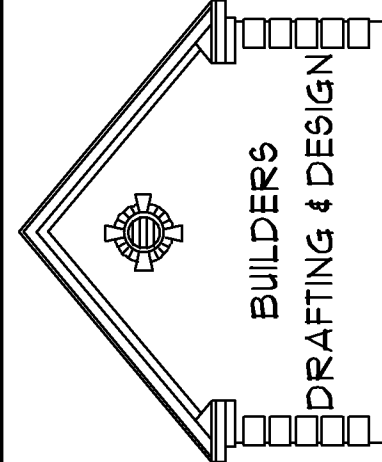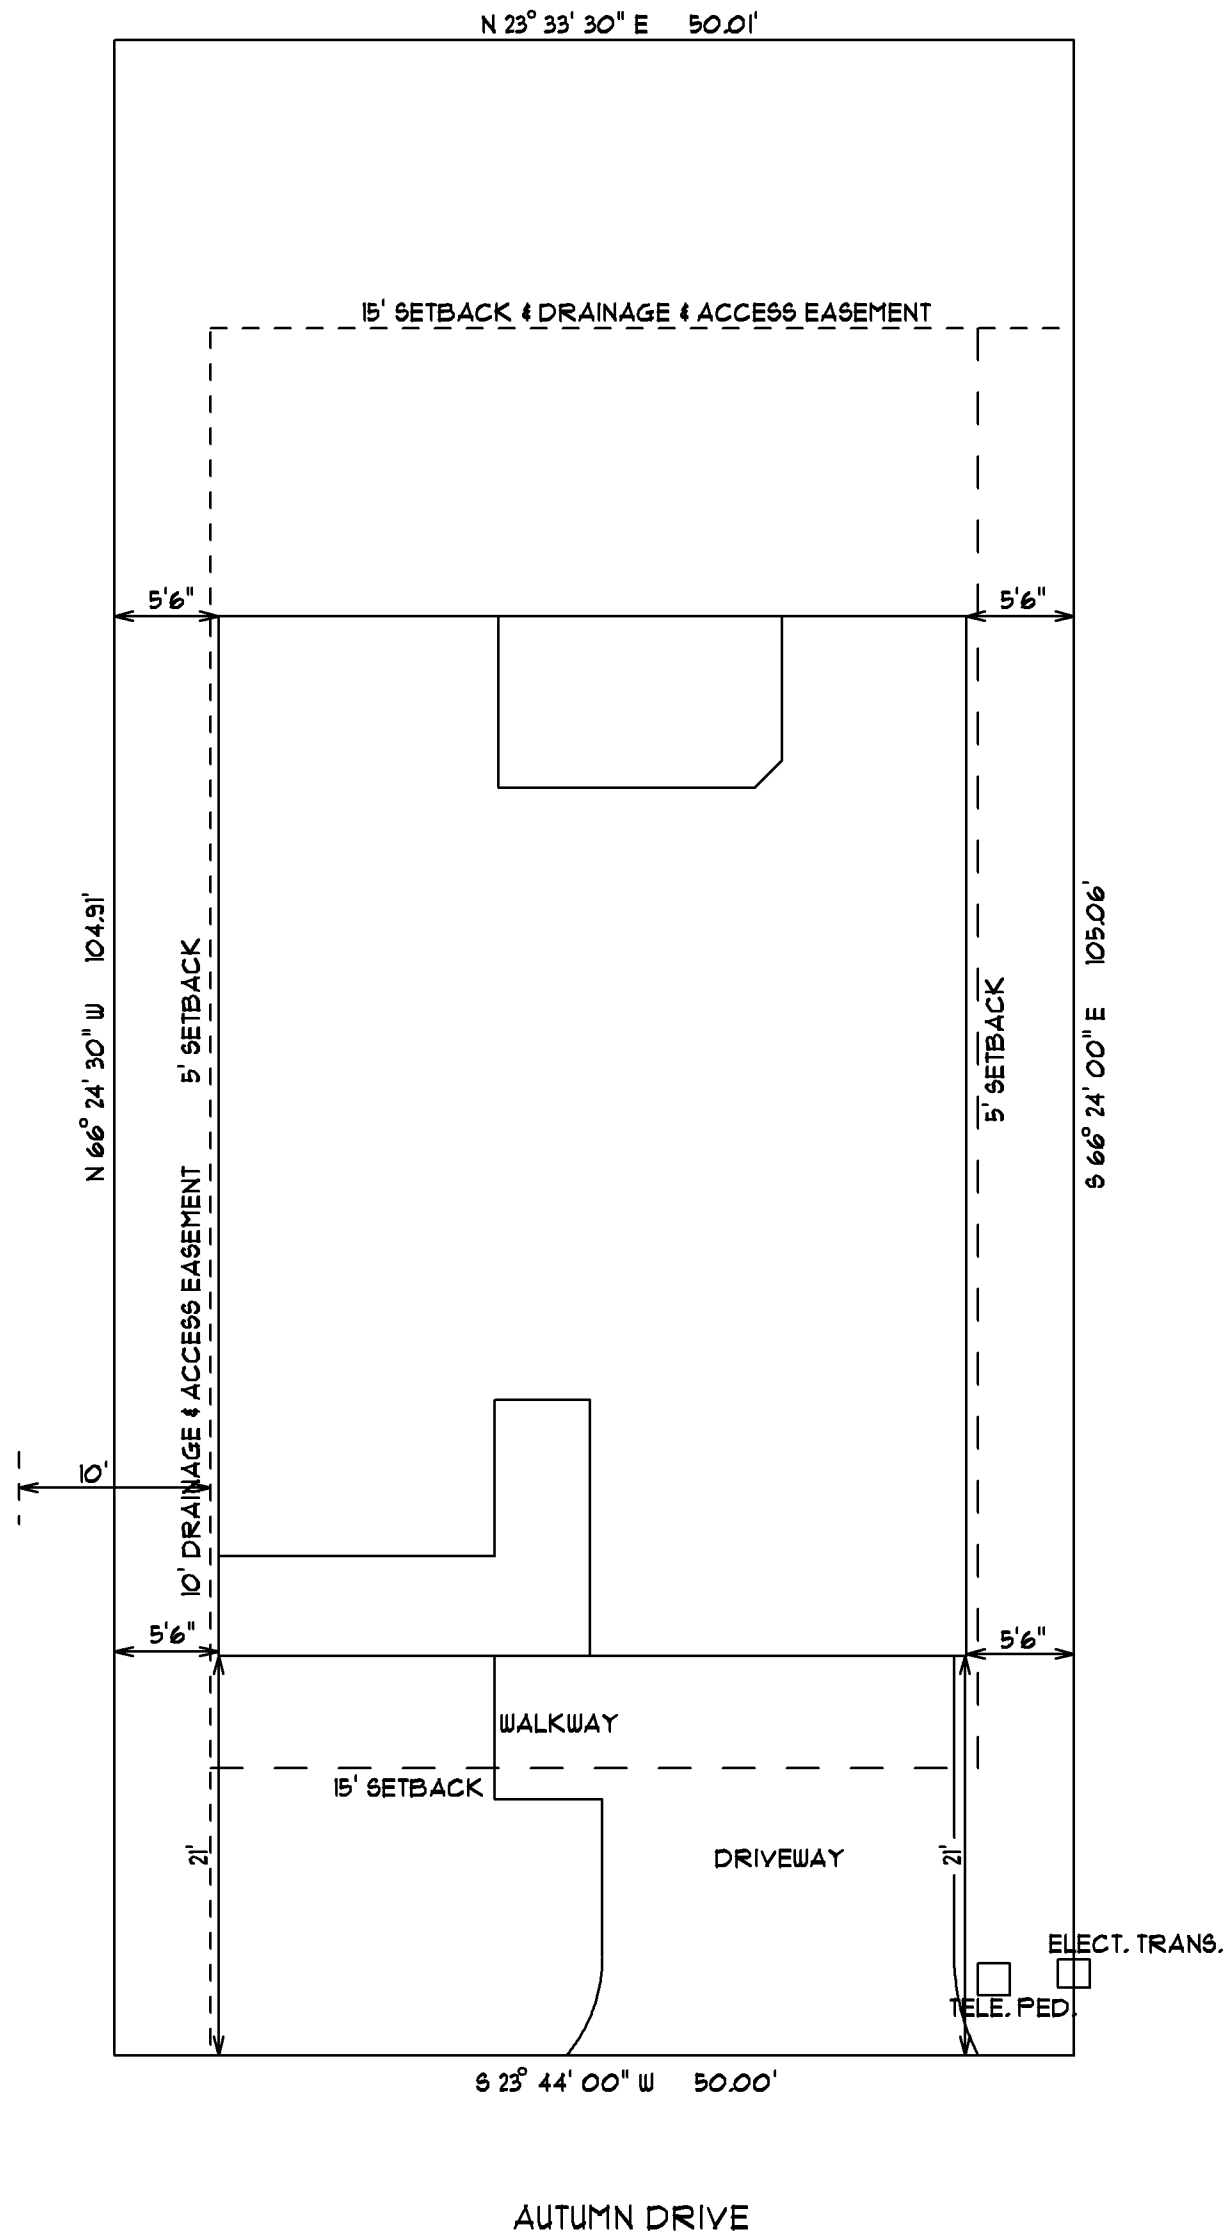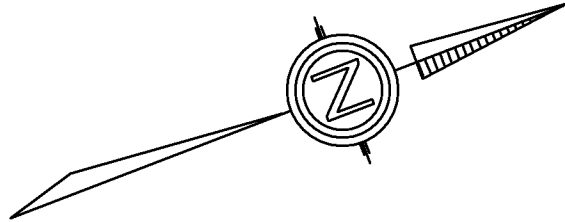

PAULA BURGIN
1341 CROOKED OAK DRIVE
FAULEY'S ISLAND, SC 29565
C(843) 979 - 5500
C(843) 283 - 3773
BURGINPAULA@AOL.COM

SCALE: 1" = 10'

DATE 3/20/24

SHEET #4

PLOT PLAN

JOB LOCATION:

LOT #114 AUTUMN DRIVE
THE PINES OF ST. JAMES
MYRTLE BEACH, SC

SQUARE FOOTAGE:

HEATED SPACE
GARAGE
ENTRY PORCH
COVERED PORCH
TOTAL UNDER ROOF

1400
441
140
131
2112

EXPERT
PROPERTIES LLC