



PAULA BURGIN
841 CROOKED OAK DRIVE
PAULEY'S ISLAND, SC 29585
C 843 283 - 3773
BURGINPAULA@AOL.COM

SCALE: 1/4" = 1'-0"

DATE: 4/5/24


SHEET #1

ELEVATIONS

JOB LOCATION:
LOT 333 BENTCREEK LANE
CAROLINA WATERWAY PLANTATION
MYRTLE BEACH, SC

SQUARE FOOTAGE:	2105
1ST FLOOR HEATED	110
2ND FLOOR HEATED	2815
TOTAL HEATED SPACE	1030
UNHEATED ATTIC	624
GARAGE	44
ENTRY PORCH	333
COVERED PORCH	333
TOTAL UNDER ROOF	4906

SNT HOLDINGS
LLC

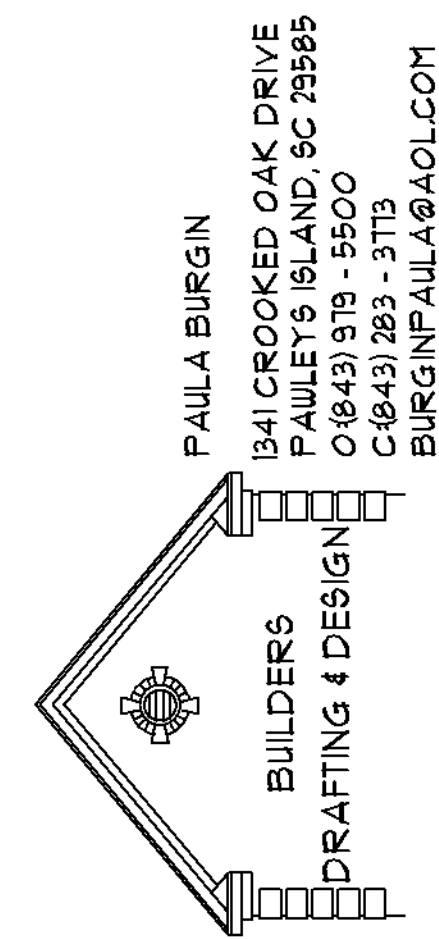

SCALE: 1/4" = 1'0"

DATE: 4/5/24


SHEET #2

ELEVATIONS

JOB LOCATION:
LOT 333 BENTCREEK LANE
CAROLINA WATERWAY PLANTATION
MYRTLE BEACH, SC

SQUARE FOOTAGE:	2105	110	2815	1030	624	333	4906
1ST FLOOR HEATED							
2ND FLOOR HEATED							
TOTAL HEATED SPACE							
UNHEATED JUNK ATTIC							
GARAGE							
ENTRY PORCH							
COVERED PORCH							
TOTAL UNDER ROOF							

SNT HOLDINGS
LLC

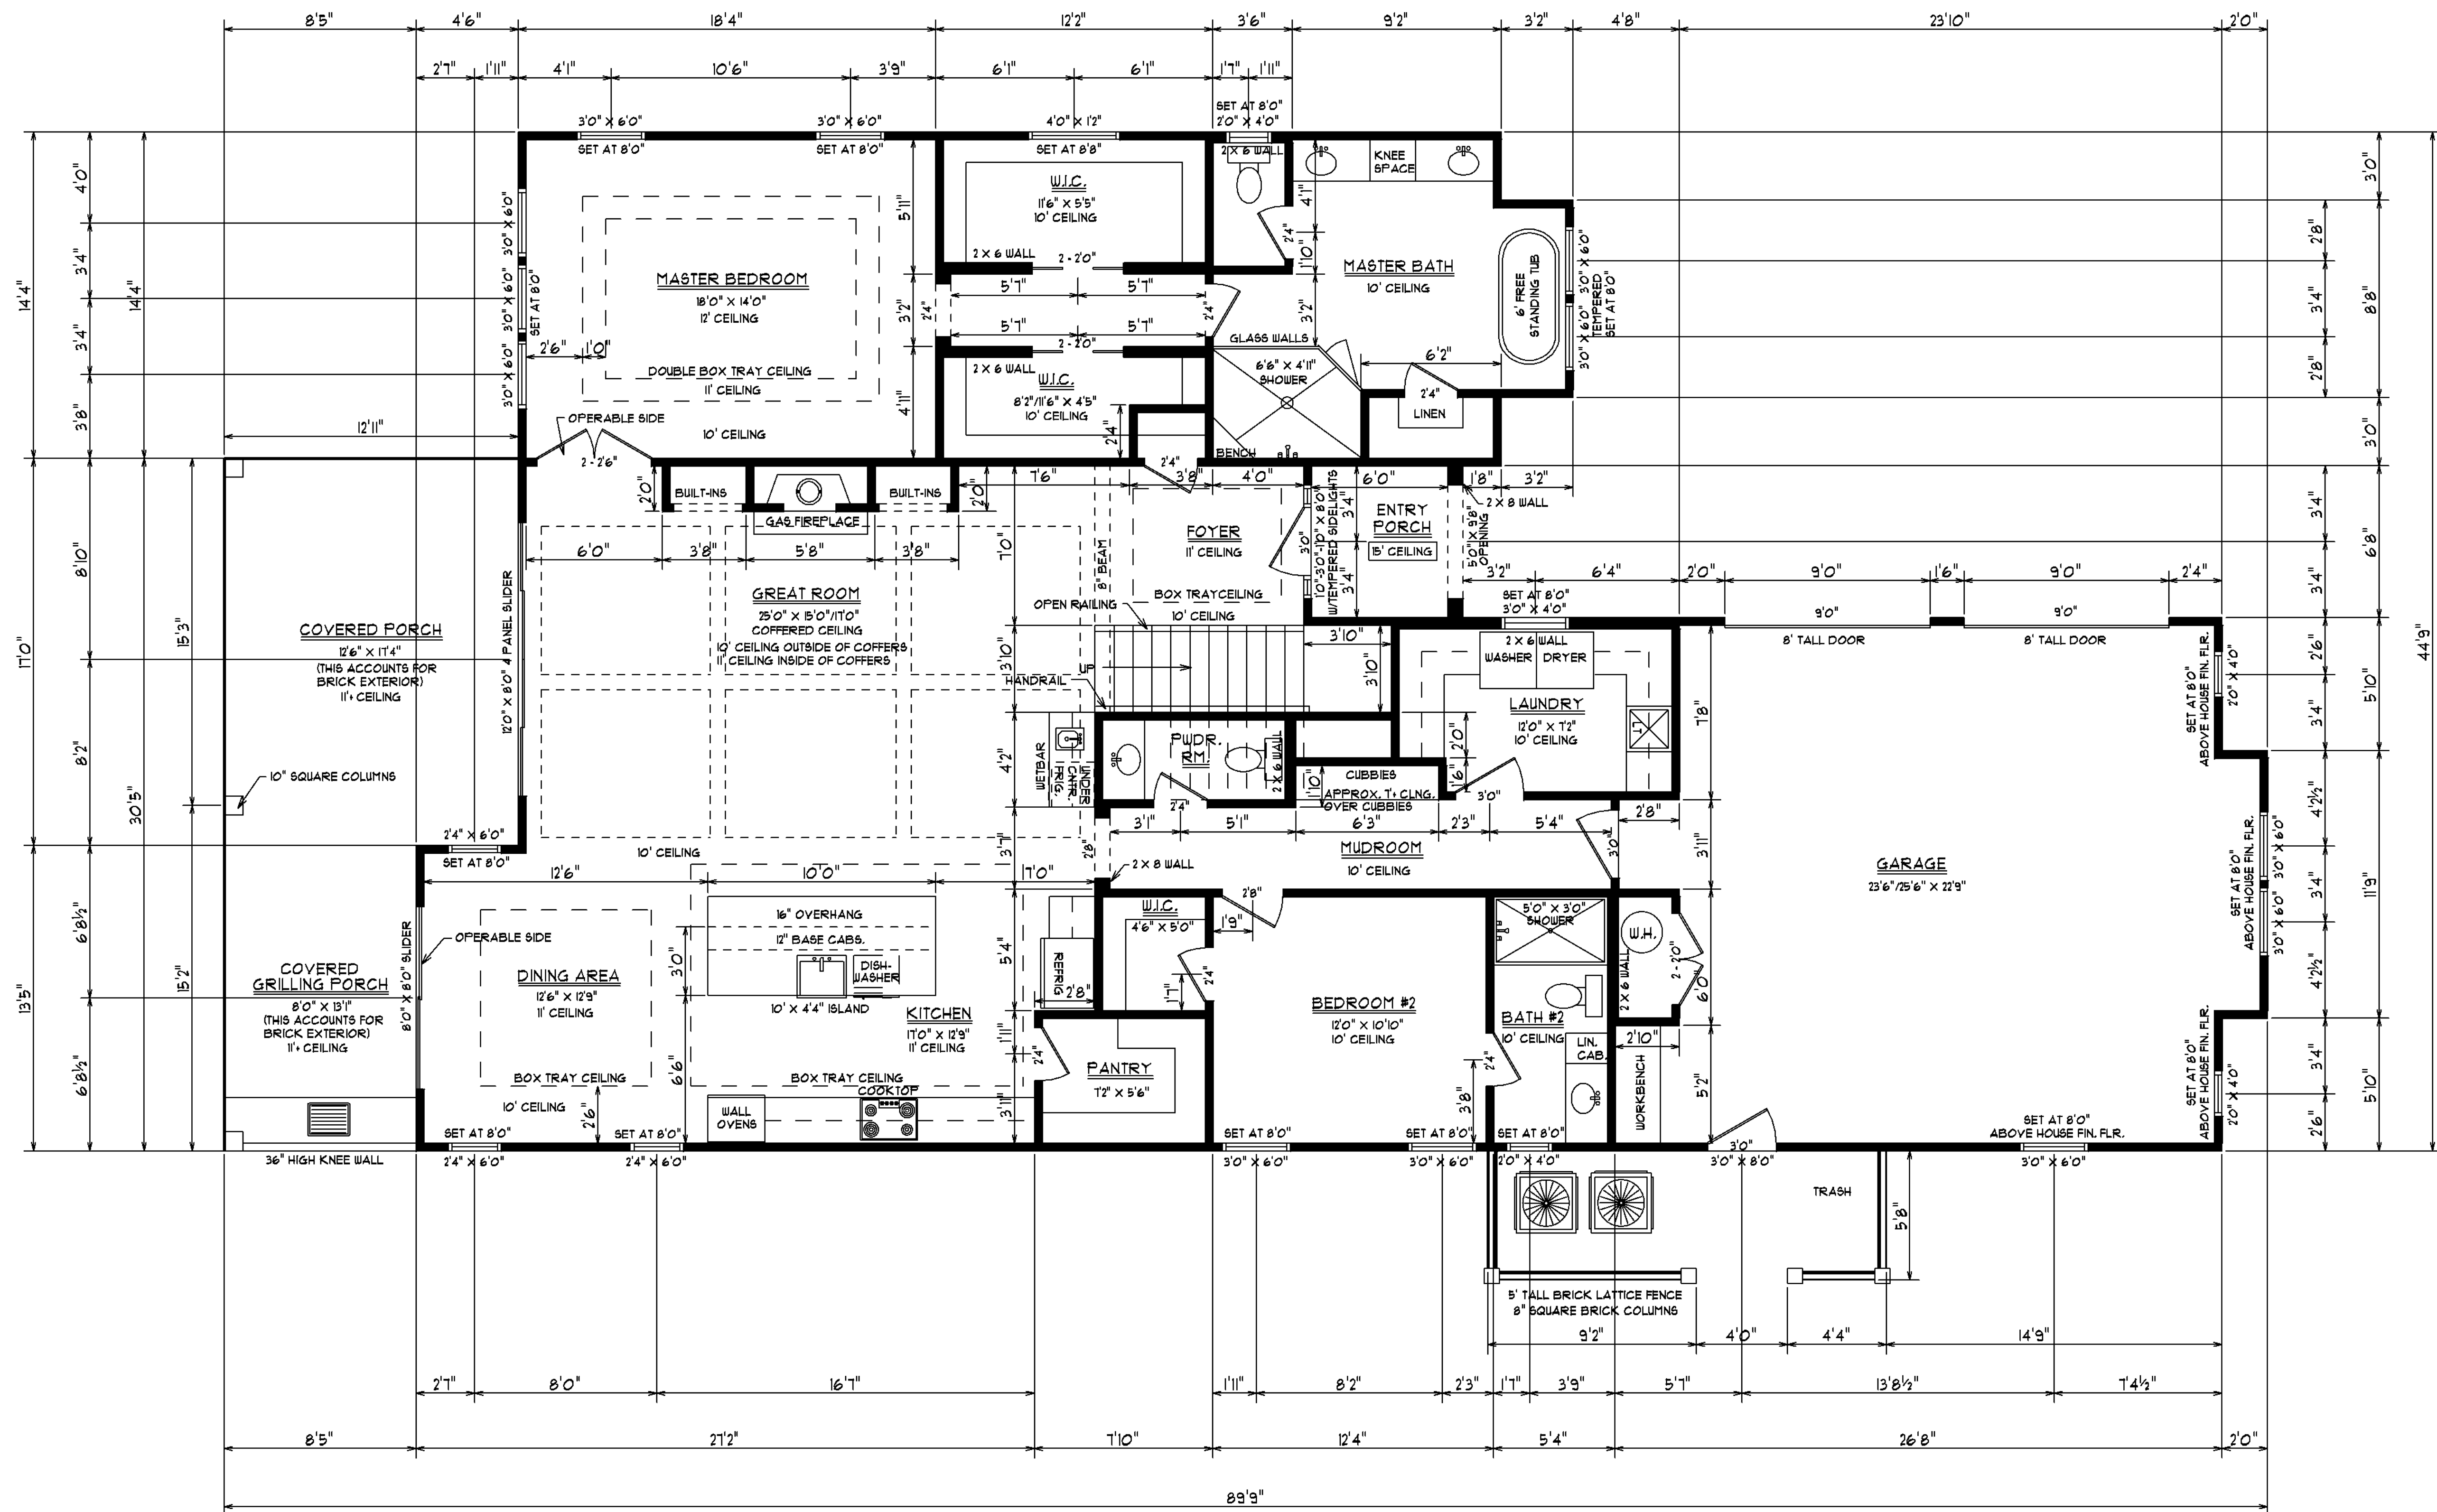

NOTE:
1. DIMENSIONS DO NOT INCLUDE BRICK EXTERIOR


SCALE: 1/4" = 1'0"

DATE: 4/5/24

SHEET #3
FIRST FLOOR PLAN

JOB LOCATION:
LOT 333 BENTCREEK LANE
CAROLINA WATERWAY PLANTATION
MYRTLE BEACH, SC

SQUARE FOOTAGE:	2105
1ST FLOOR HEATED	1710
2ND FLOOR HEATED	2815
TOTAL HEATED SPACE	
UNHEATED JUNE/ATTIC	1030
GARAGE	624
ENTRY PORCH	44
COVERED PORCH	333
TOTAL UNDER ROOF	4306

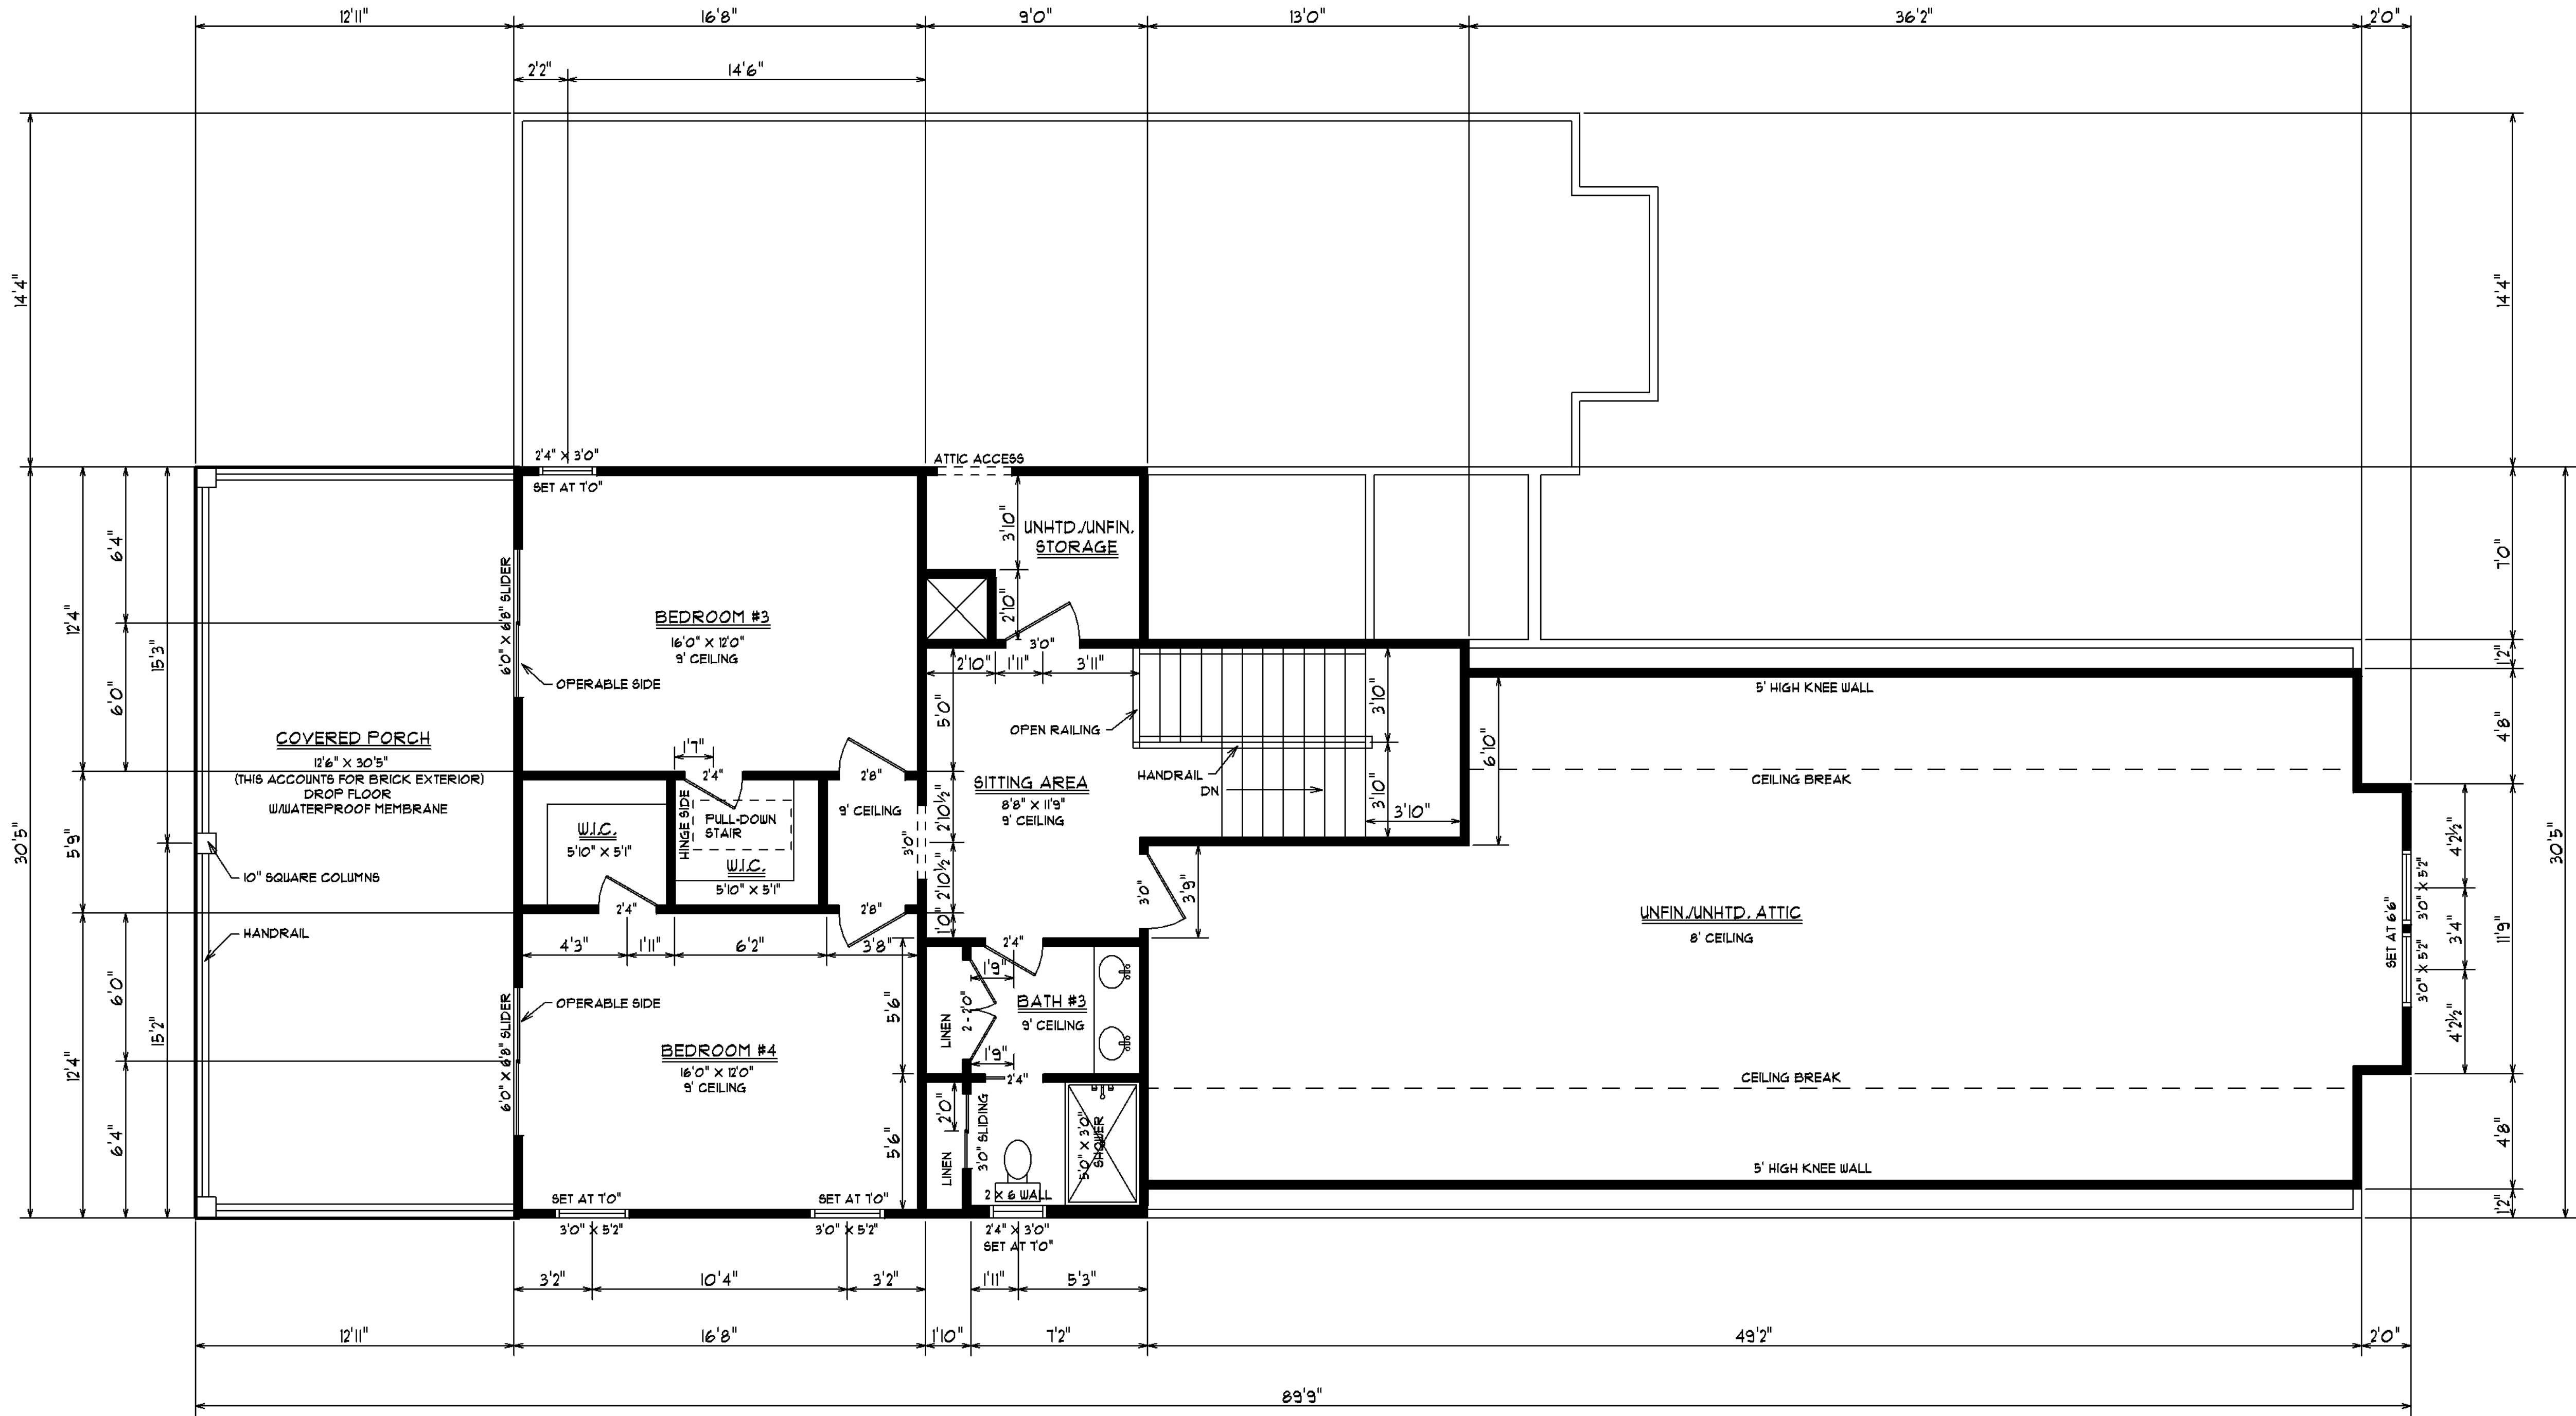

NOTE:
1. DIMENSIONS DO NOT INCLUDE BRICK EXTERIOR

PAULA BURGIN
341 CROOKED OAK DRIVE
FAULET'S ISLAND, SC 29585
C(843) 519 - 5500
BURGINPAULA@AOL.COM

BUILDERS
DRAFTING & DESIGN

SCALE: 1/4" = 1'-0"

DATE: 4/5/24


SHEET #4
SECOND FLOOR PLAN

JOB LOCATION:
LOT 333 BENTCREEK LANE
CAROLINA WATERWAY PLANTATION
MYRTLE BEACH, SC

SQUARE FOOTAGE:	2105
1ST FLOOR HEATED	110
2ND FLOOR HEATED	2815
TOTAL HEATED SPACE	
UNHTD./UNFIN. ATTIC	1030
GARAGE	624
ENTRY PORCH	44
COVERED PORCH	333
TOTAL UNDER ROOF	4906

SNT HOLDINGS
LLC

ELECTRICAL LEGEND	
SYMBOL	DESCRIPTION
	LIGHT
	RECESSED CAN LIGHT
	SWITCH
	3-WAY SWITCH
	220 OUTLET
	110 OUTLET
	GROUND FAULT INTERRUPTER
	TELEVISION
	TELEPHONE
	BATH FAN/LIGHT
	BATH FAN ONLY
	GARBAGE DISPOSAL
	SPEAKER
	DOORBELL BUTTON
	SMOKE DETECTOR
	DOUBLE FLOOD LIGHT
	HOSE BIB
	PREWIRED FAN/LIGHT

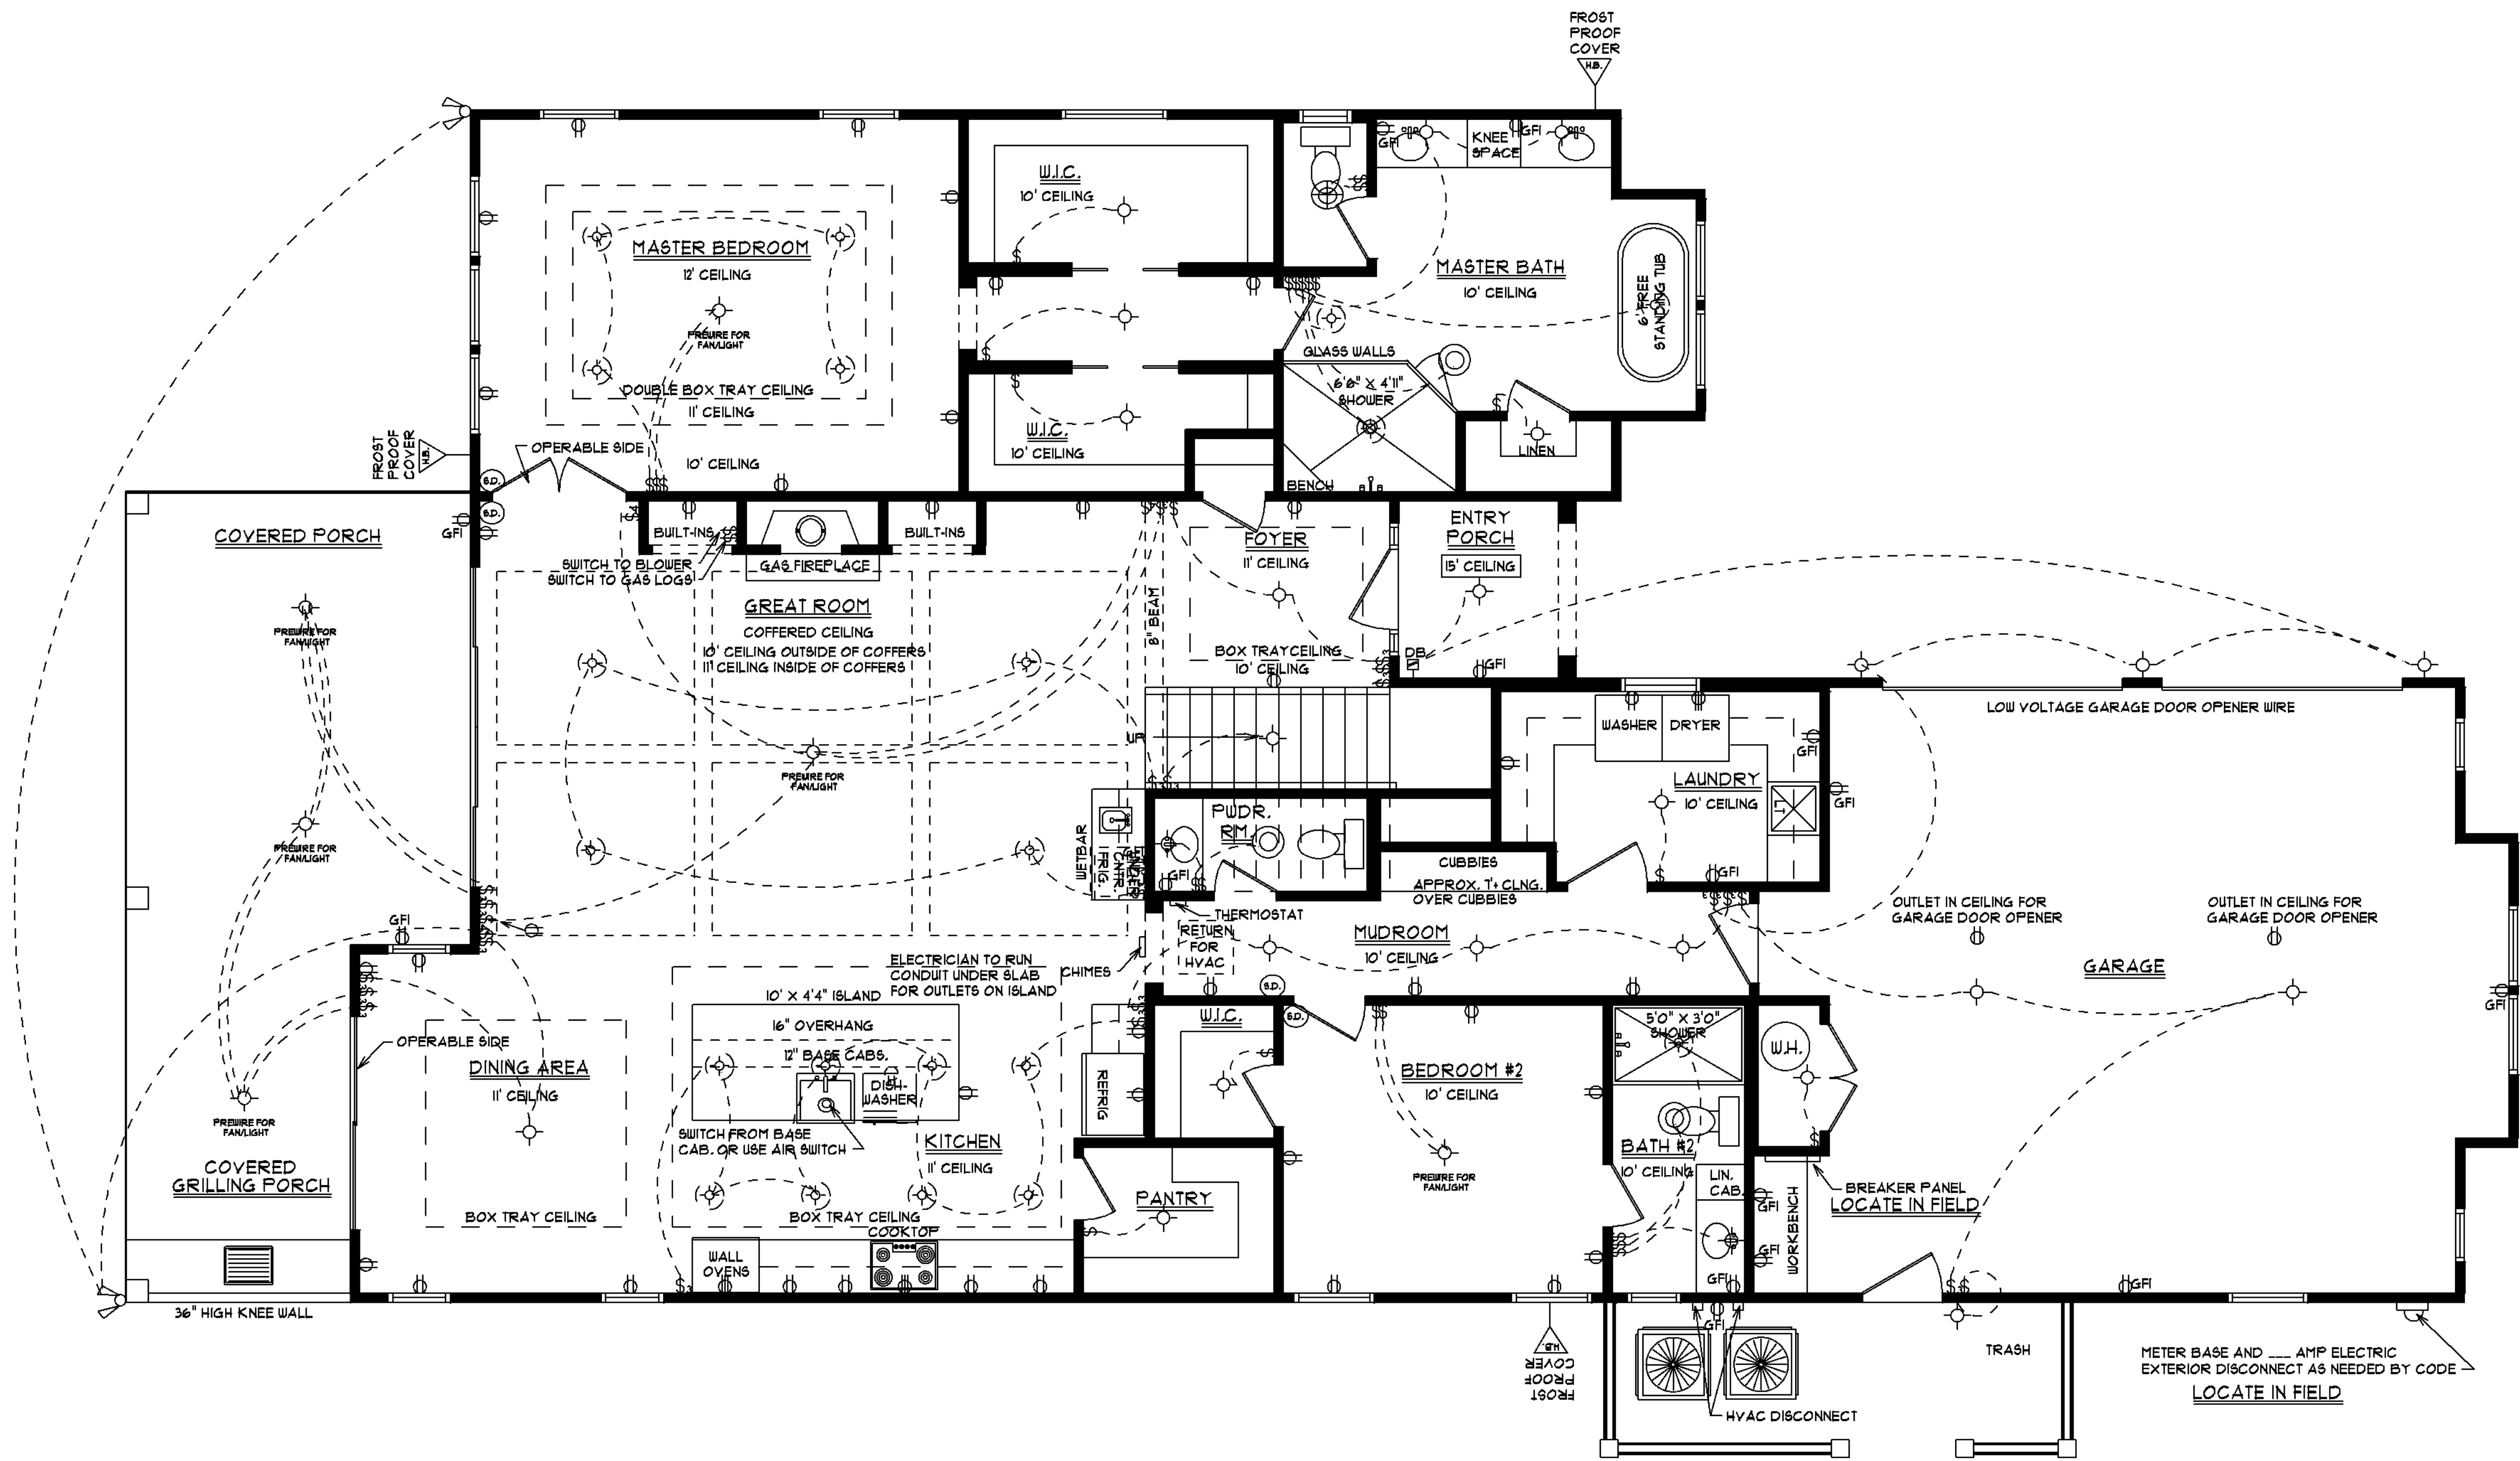

PAULA BURGIN
341 CROOKED OAK DRIVE
PAULEY'S ISLAND, SC 29585
0843) 919 - 5500
C843) 283 - 3113
BURGINPAULA@aol.com

BUILDERS
DRAFTING & DESIGN

SCALE: 1/4" = 1'-0"

DATE: 4/5/24

SHEET #5


1ST FLOOR
ELECTRICAL

JOB LOCATION:
LOT 333 BENTCREEK LANE
CAROLINA WATERWAY PLANTATION
MYRTLE BEACH, SC

SQUARE FOOTAGE:	2105	110	2815	1030	44	333	4306
1ST FLOOR HEATED							
2ND FLOOR HEATED							
TOTAL HEATED SPACE							
UNHEATED ATTIC							
GARAGE							
ENTRY PORCH							
COVERED PORCH							
TOTAL UNDER ROOF							

SNT HOLDINGS
LLC

ELECTRICAL LEGEND	
SYMBOL	DESCRIPTION
	LIGHT
	RECESSED CAN LIGHT
	SWITCH
	3-WAY SWITCH
	220 OUTLET
	110 OUTLET
	GROUND FAULT INTERRUPTER
	TELEVISION
	TELEPHONE
	BATH FAN/LIGHT
	BATH FAN ONLY
	GARBAGE DISPOSAL
	SPEAKER
	DOORBELL BUTTON
	SMOKE DETECTOR
	DOUBLE FLOOD LIGHT
	HOSE BIB
	PREWIRED FAN/LIGHT

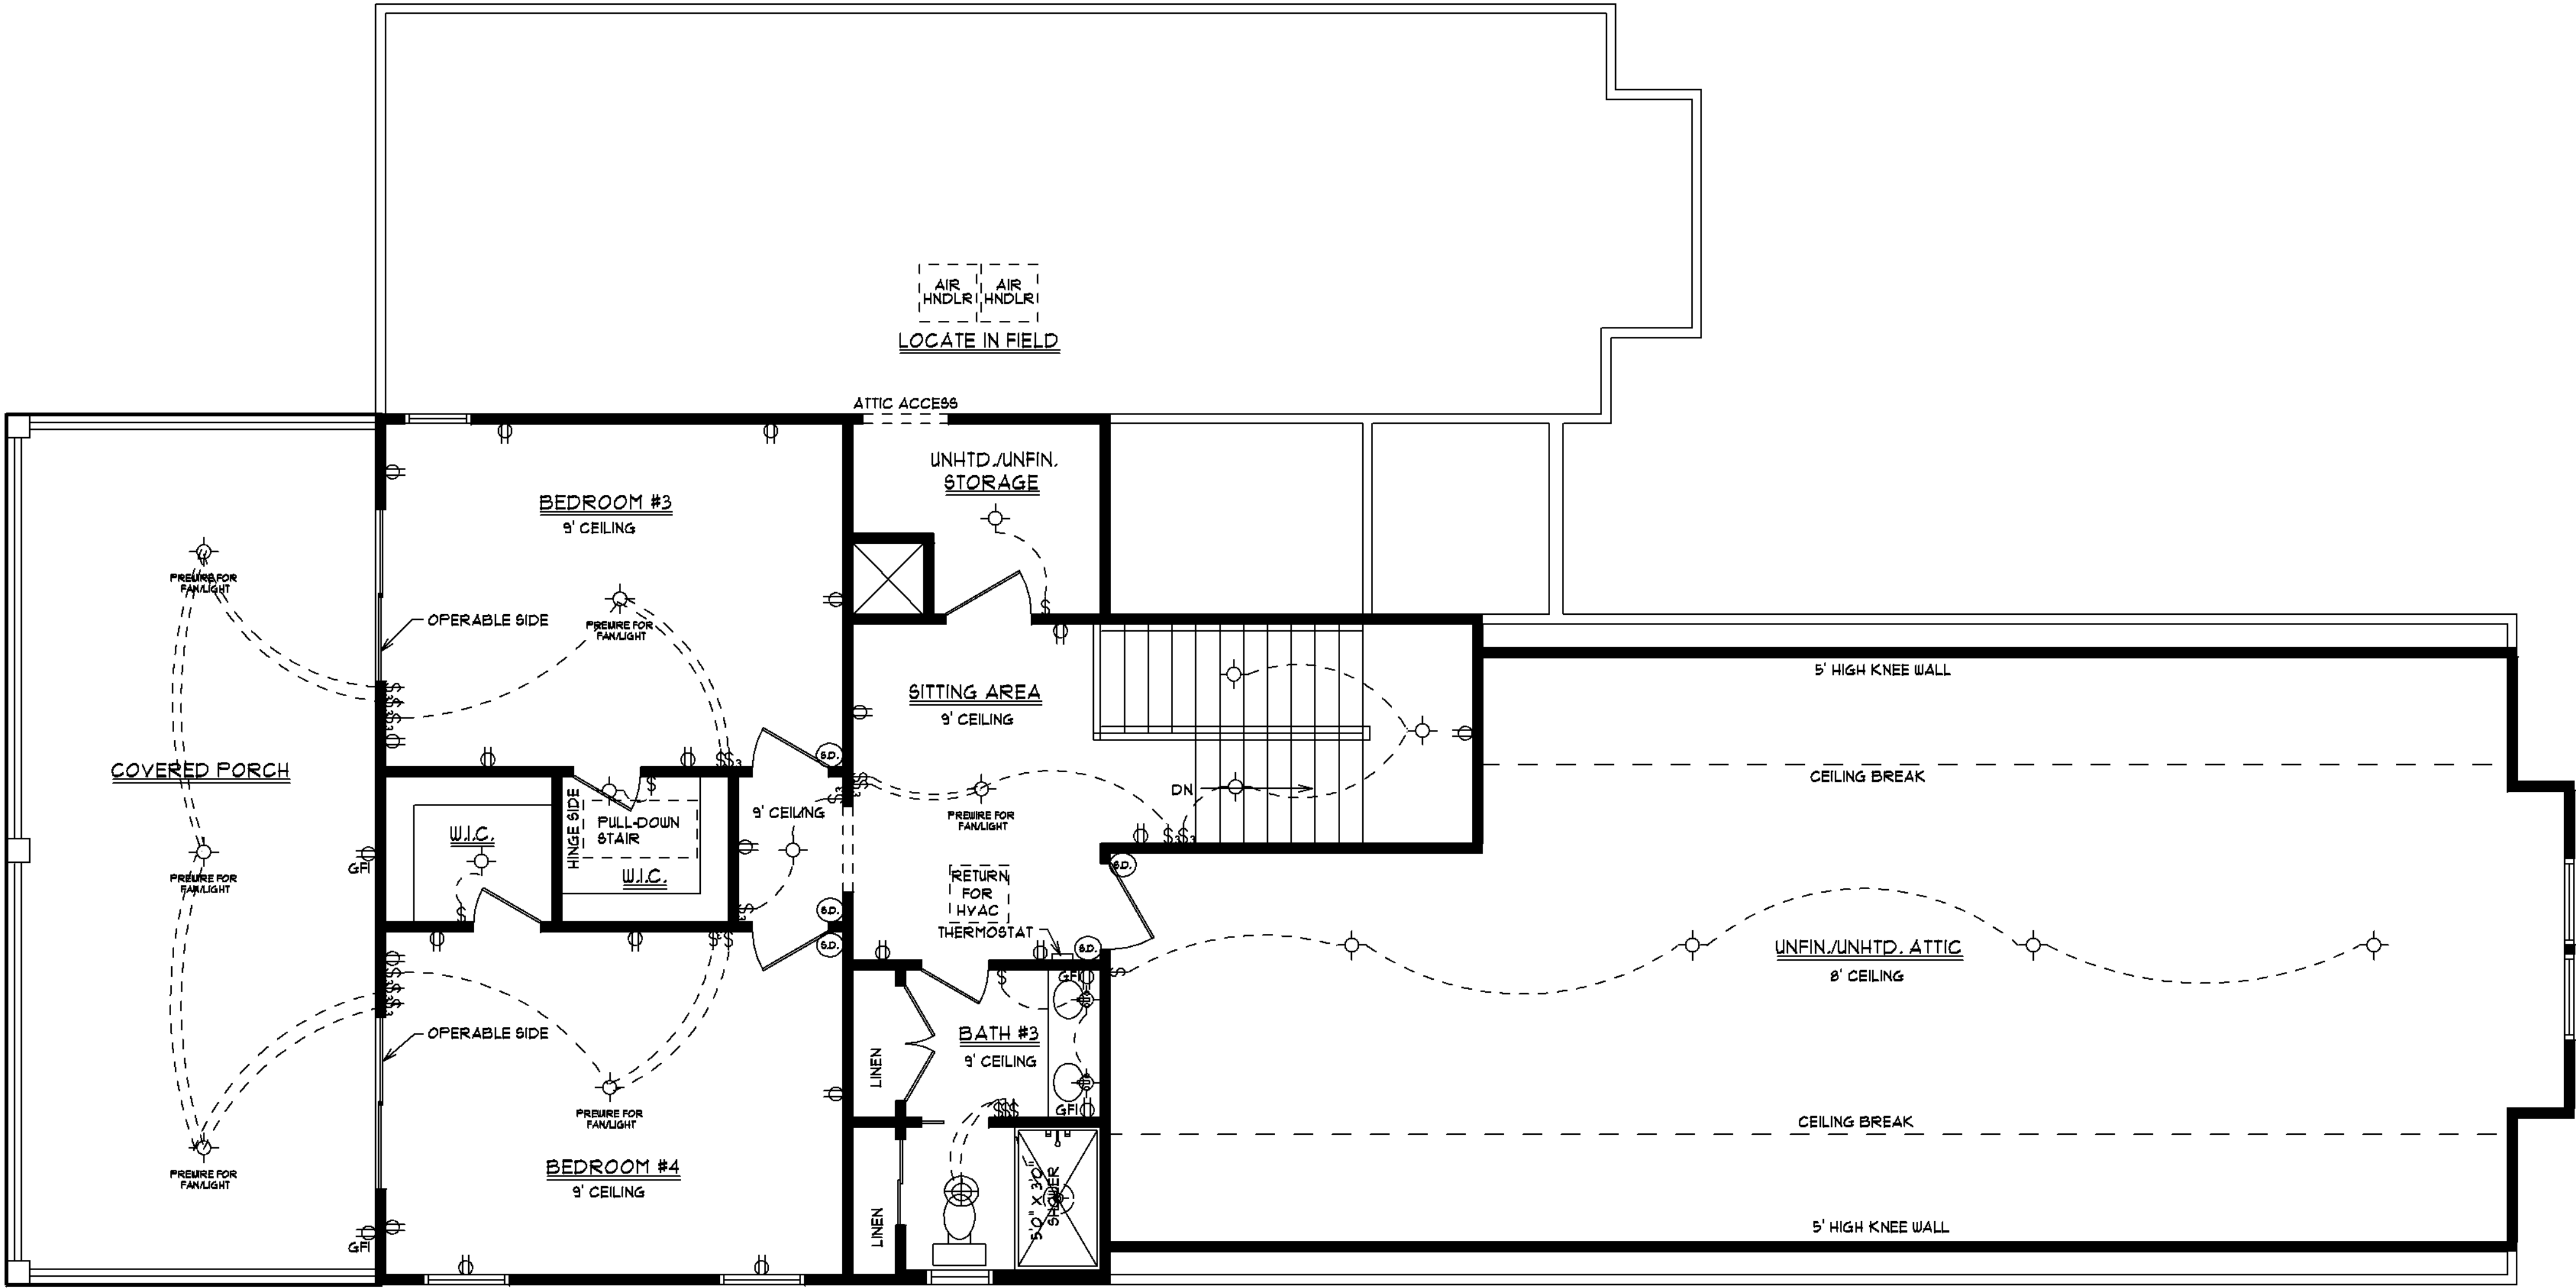

BUILDERS
DRAFTING & DESIGN

PAULA BURGIN
341 CROOKED OAK DRIVE
FAULEY'S ISLAND, SC 29585
O (843) 919 - 5500
C (843) 283 - 3113
BURGINPAULA@AOL.COM

SCALE: 1/4" = 1'-0"


DATE: 4/5/24

SHEET #6
2ND FLOOR
ELECTRICAL

JOB LOCATION:
LOT 333 BENTCREEK LANE
CAROLINA WATERWAY PLANTATION
MYRTLE BEACH, SC

SQUARE FOOTAGE:	2105
	1110
	2815
	1030
	624
1ST FLOOR HEATED	
2ND FLOOR HEATED	
TOTAL HEATED SPACE	
UNHTD./UNFIN. ATTIC	
GARAGE	
ENTRY PORCH	
COVERED PORCH	
TOTAL UNDER ROOF	4306

SNT HOLDINGS
LLC

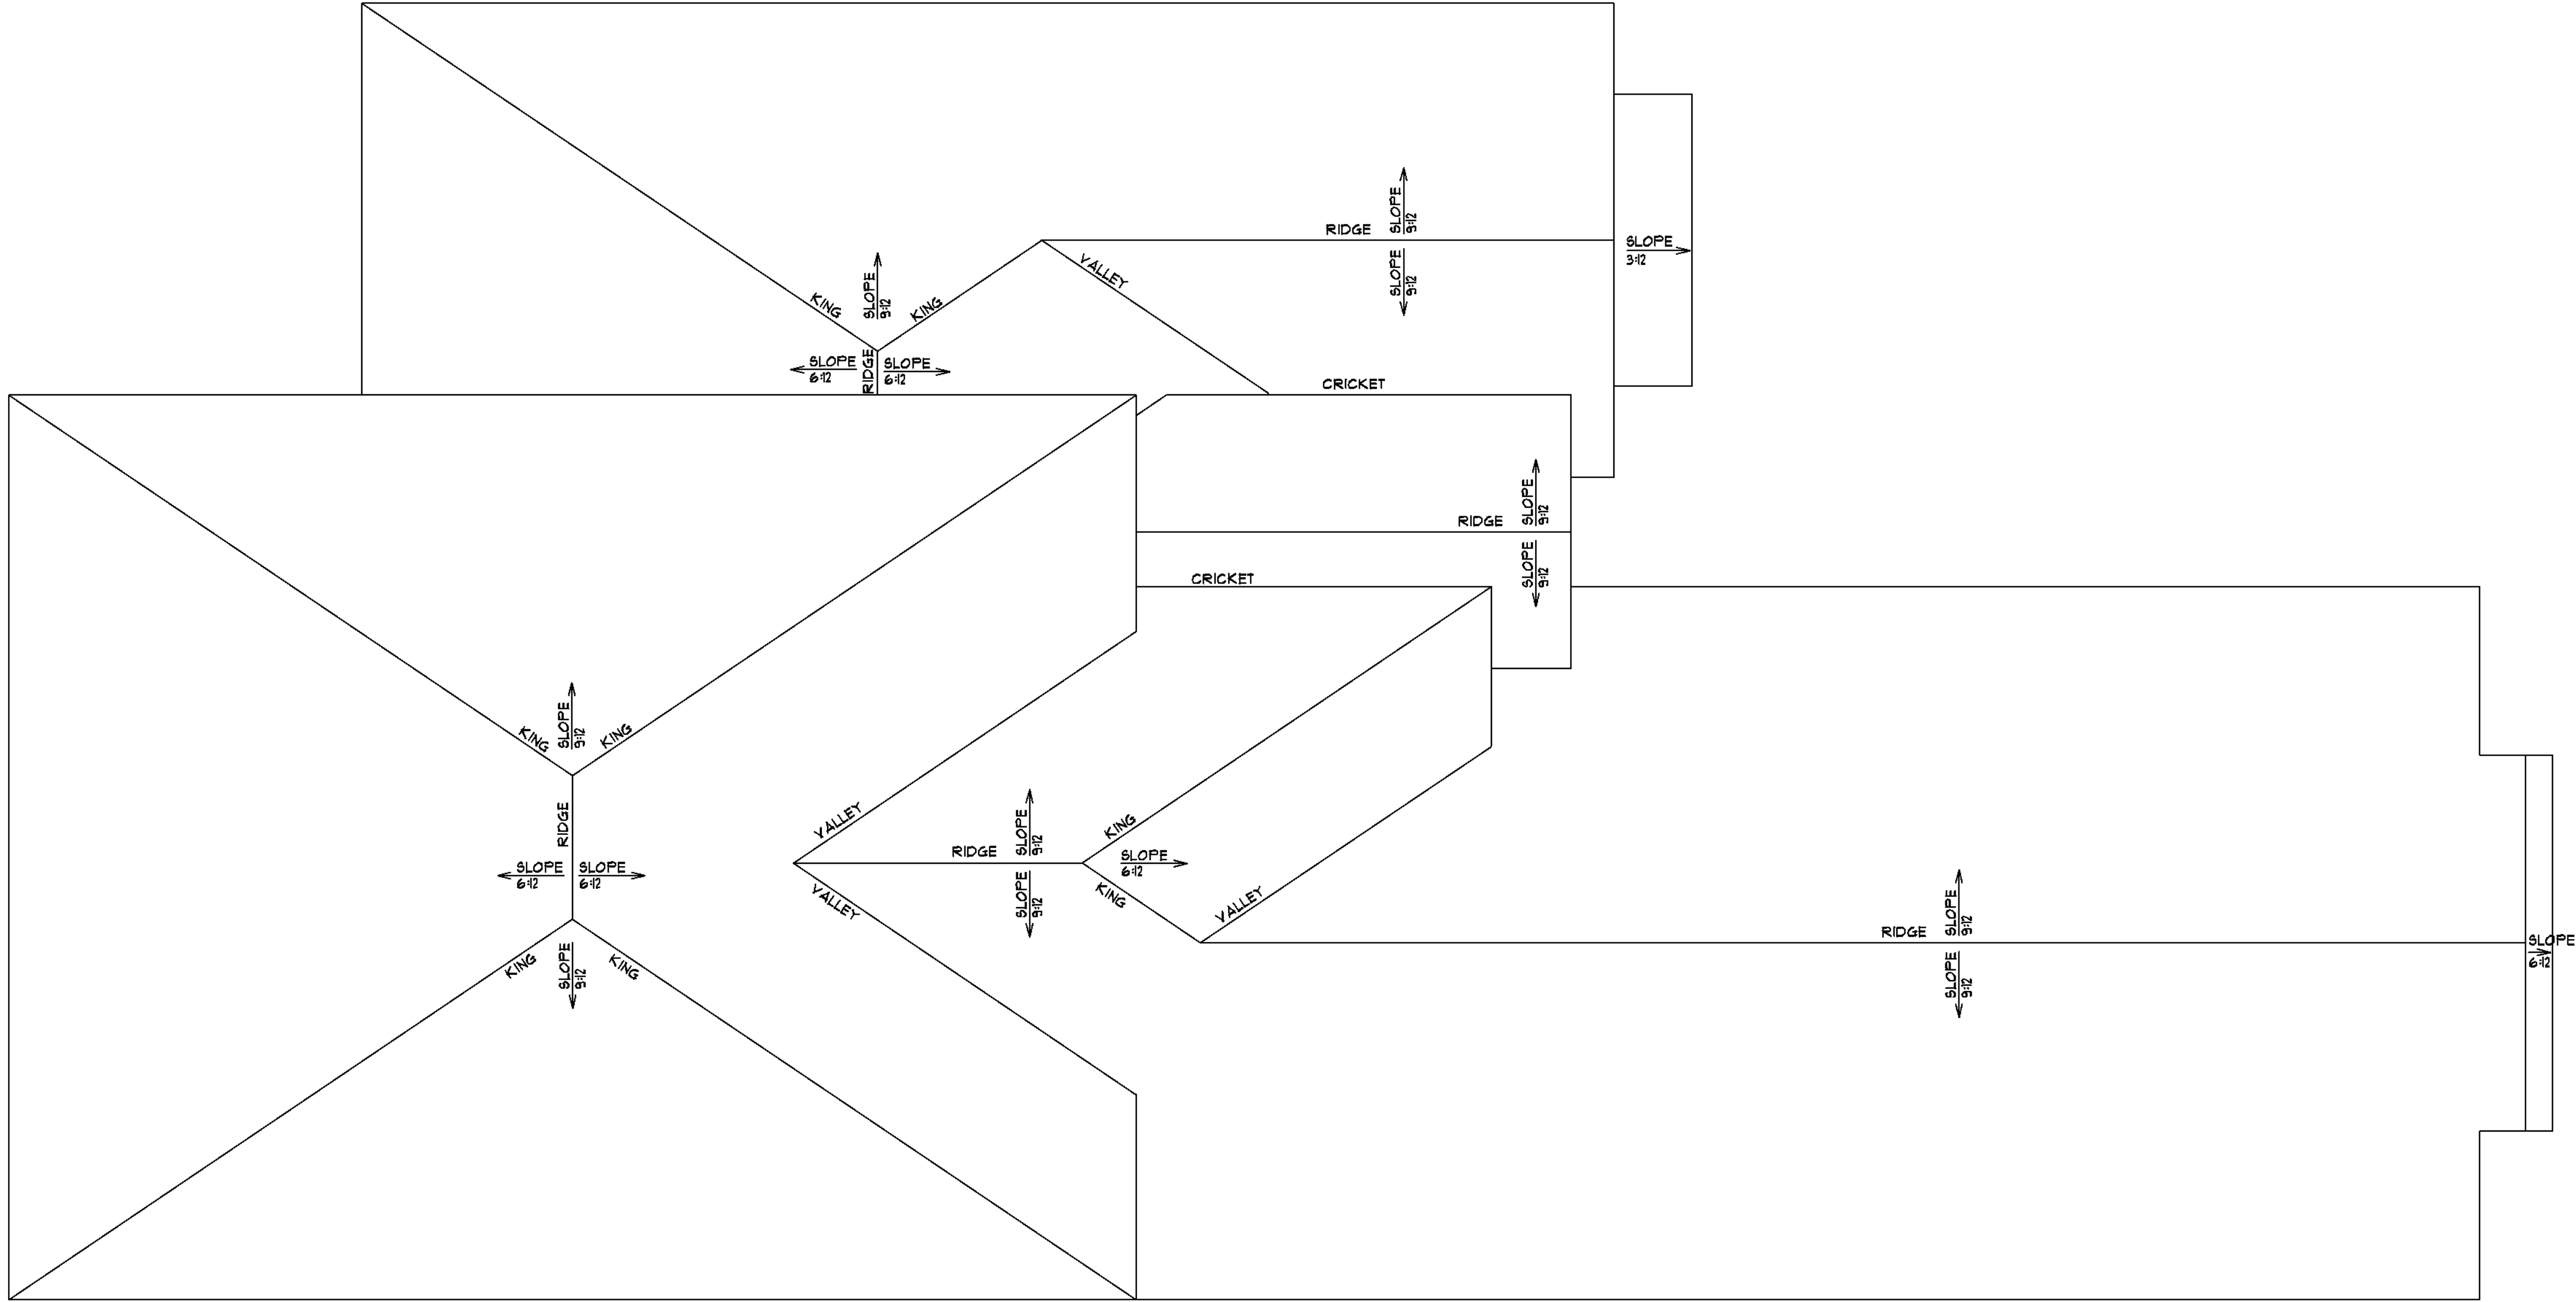

SNT HOLDINGS
LLC

SQUARE FOOTAGE:	
1ST FLOOR HEATED	2105
2ND FLOOR HEATED	110
TOTAL HEATED SPACE	2215
UNHEATED ATTIC	1030
GARAGE	624
ENTRY PORCH	44
COVERED PORCH	333
TOTAL UNDER ROOF	4906

JOB LOCATION:
LOT 333 BENTCREEK LANE
CAROLINA WATERWAY PLANTATION
MYRTLE BEACH, SC

SHEET #1


ROOF PLAN

DATE:4/5/24


SCALE: 1/4" = 1'-0"

BUILDERS
DRAFTING & DESIGN

PAULA BURGIN
841 CROOKED OAK DRIVE
PAULEY'S ISLAND, SC 29585
C (843) 283 - 3773
BURGINPAULA@AOL.COM

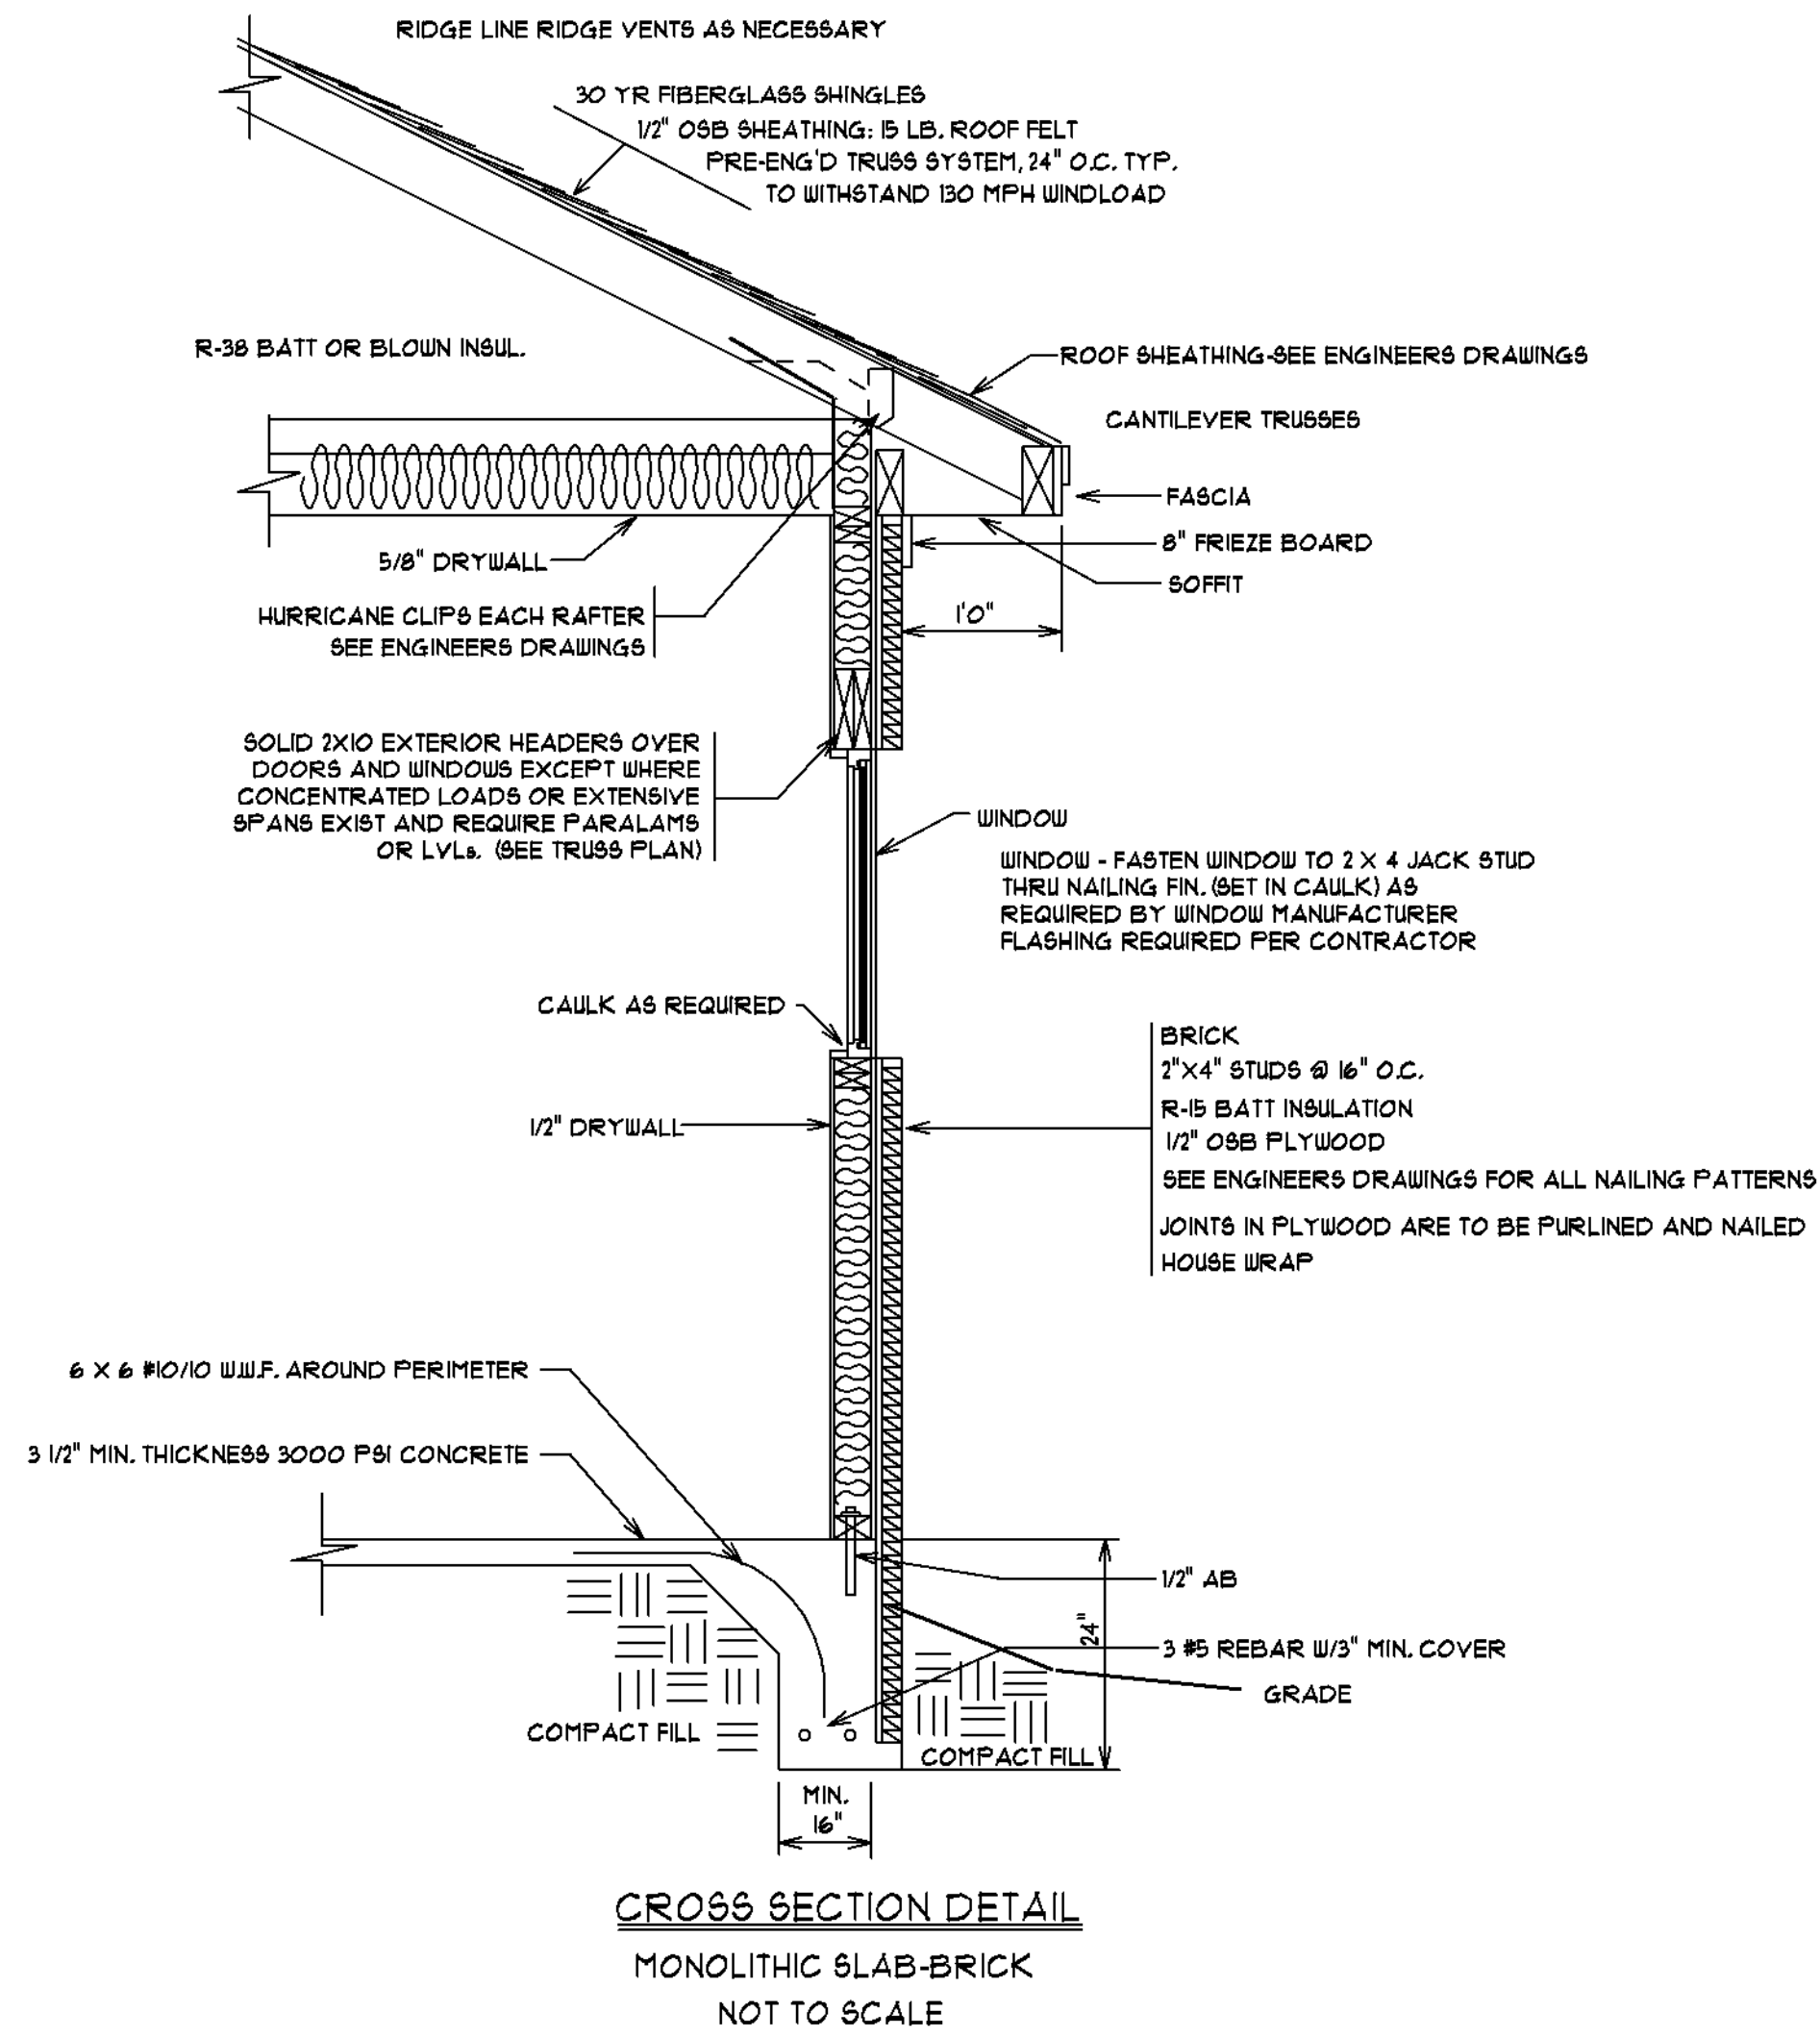

PAULA BURGIN
BUILDERS
DRAFTING & DESIGN

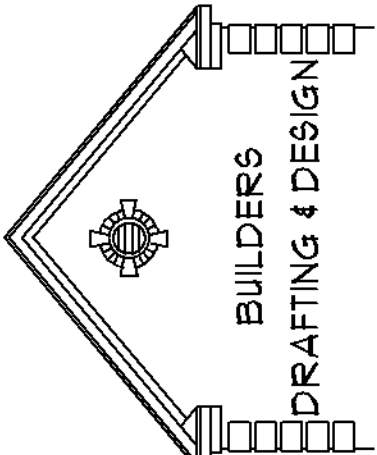

841 CROOKED OAK DRIVE
PAULEY'S ISLAND, SC 29585
O (843) 919 - 5500
C (843) 283 - 3113
BURGINPAULA@aol.com

SCALE:

DATE: 4/5/24



SHEET #8

DETAIL

JOB LOCATION:
LOT 333 BENTCREEK LANE
CAROLINA WATERWAY PLANTATION
MYRTLE BEACH, SC

SQUARE FOOTAGE:	2105
	110
	2815
	1030
	624
1ST FLOOR HEATED	
2ND FLOOR HEATED	
TOTAL HEATED SPACE	
UNHEATED ATTIC	
STORAGE	
GARAGE	
ENTRY PORCH	
COVERED PORCH	
TOTAL UNDER ROOF	4306

SNT HOLDINGS
LLC

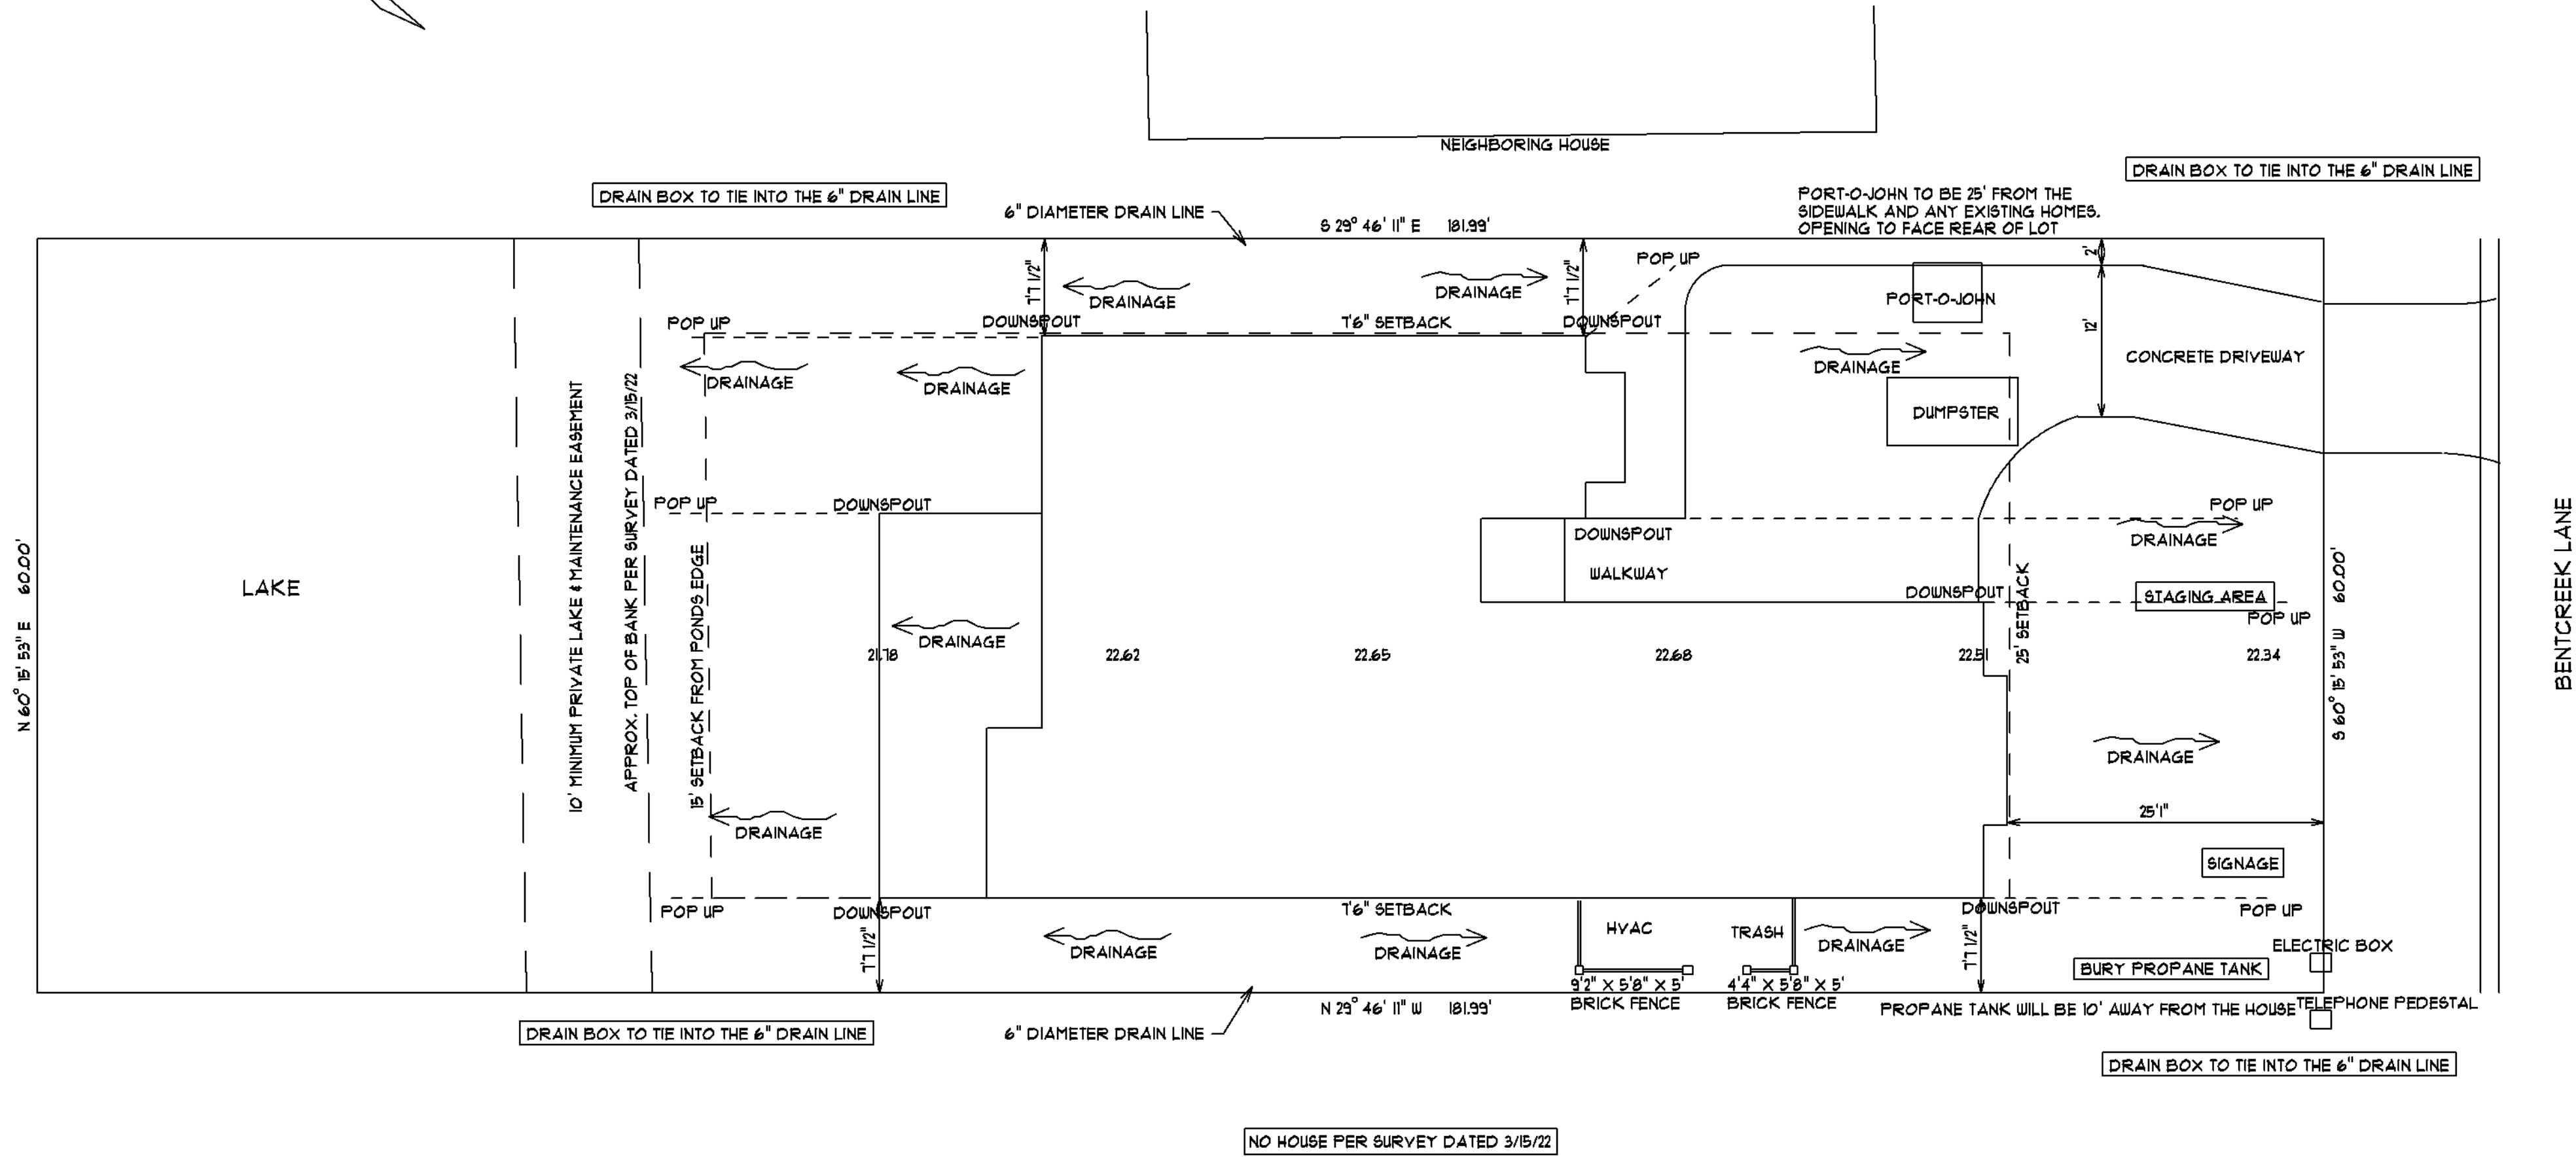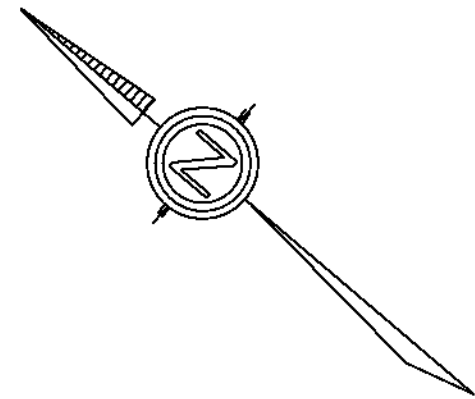

NO HOUSE PER SURVEY DATED 3/15/22

- NOTES:
1. 600 WHOLE YARD
 2. IRRIGATION SYSTEM W/AUTOMATIC TIMER TO BE INSTALLED TO PROVIDE FULL COVERAGE TO ALL GRASS & PLANTS
 3. INSTALL 6" DIAMETER FRENCH DRAINS ALONG PROPERTY LINE TO CARRY ALL WATER FLOW FROM UNDER GROUND. TIE IN ROOF GUTTER DOWNSPOUTS. ALL WATER FLOW MUST SHED TOWARD FRONT OF THE PROPERTY.

PAULA BURGIN
BUILDERS
DRAFTING & DESIGN
841 CROOKED OAK DRIVE
FAULET'S ISLAND, SC 29585
O (843) 919 - 5500
C (843) 283 - 3113
BURGINPAULA@AOL.COM

SCALE: 1" = 10'

DATE: 4/5/24



SHEET #9

PLOT PLAN

JOB LOCATION:
LOT 333 BENTCREEK LANE
CAROLINA WATERWAY PLANTATION
MYRTLE BEACH, SC

SQUARE FOOTAGE:	2105	110	2815	1030	624	44	333	4306
1ST FLOOR HEATED								
2ND FLOOR HEATED								
TOTAL HEATED SPACE								
UNHEATED ATTIC								
STORAGE								
GARAGE								
ENTRY PORCH								
COVERED PORCH								
TOTAL UNDER ROOF								

SNT HOLDINGS
LLC

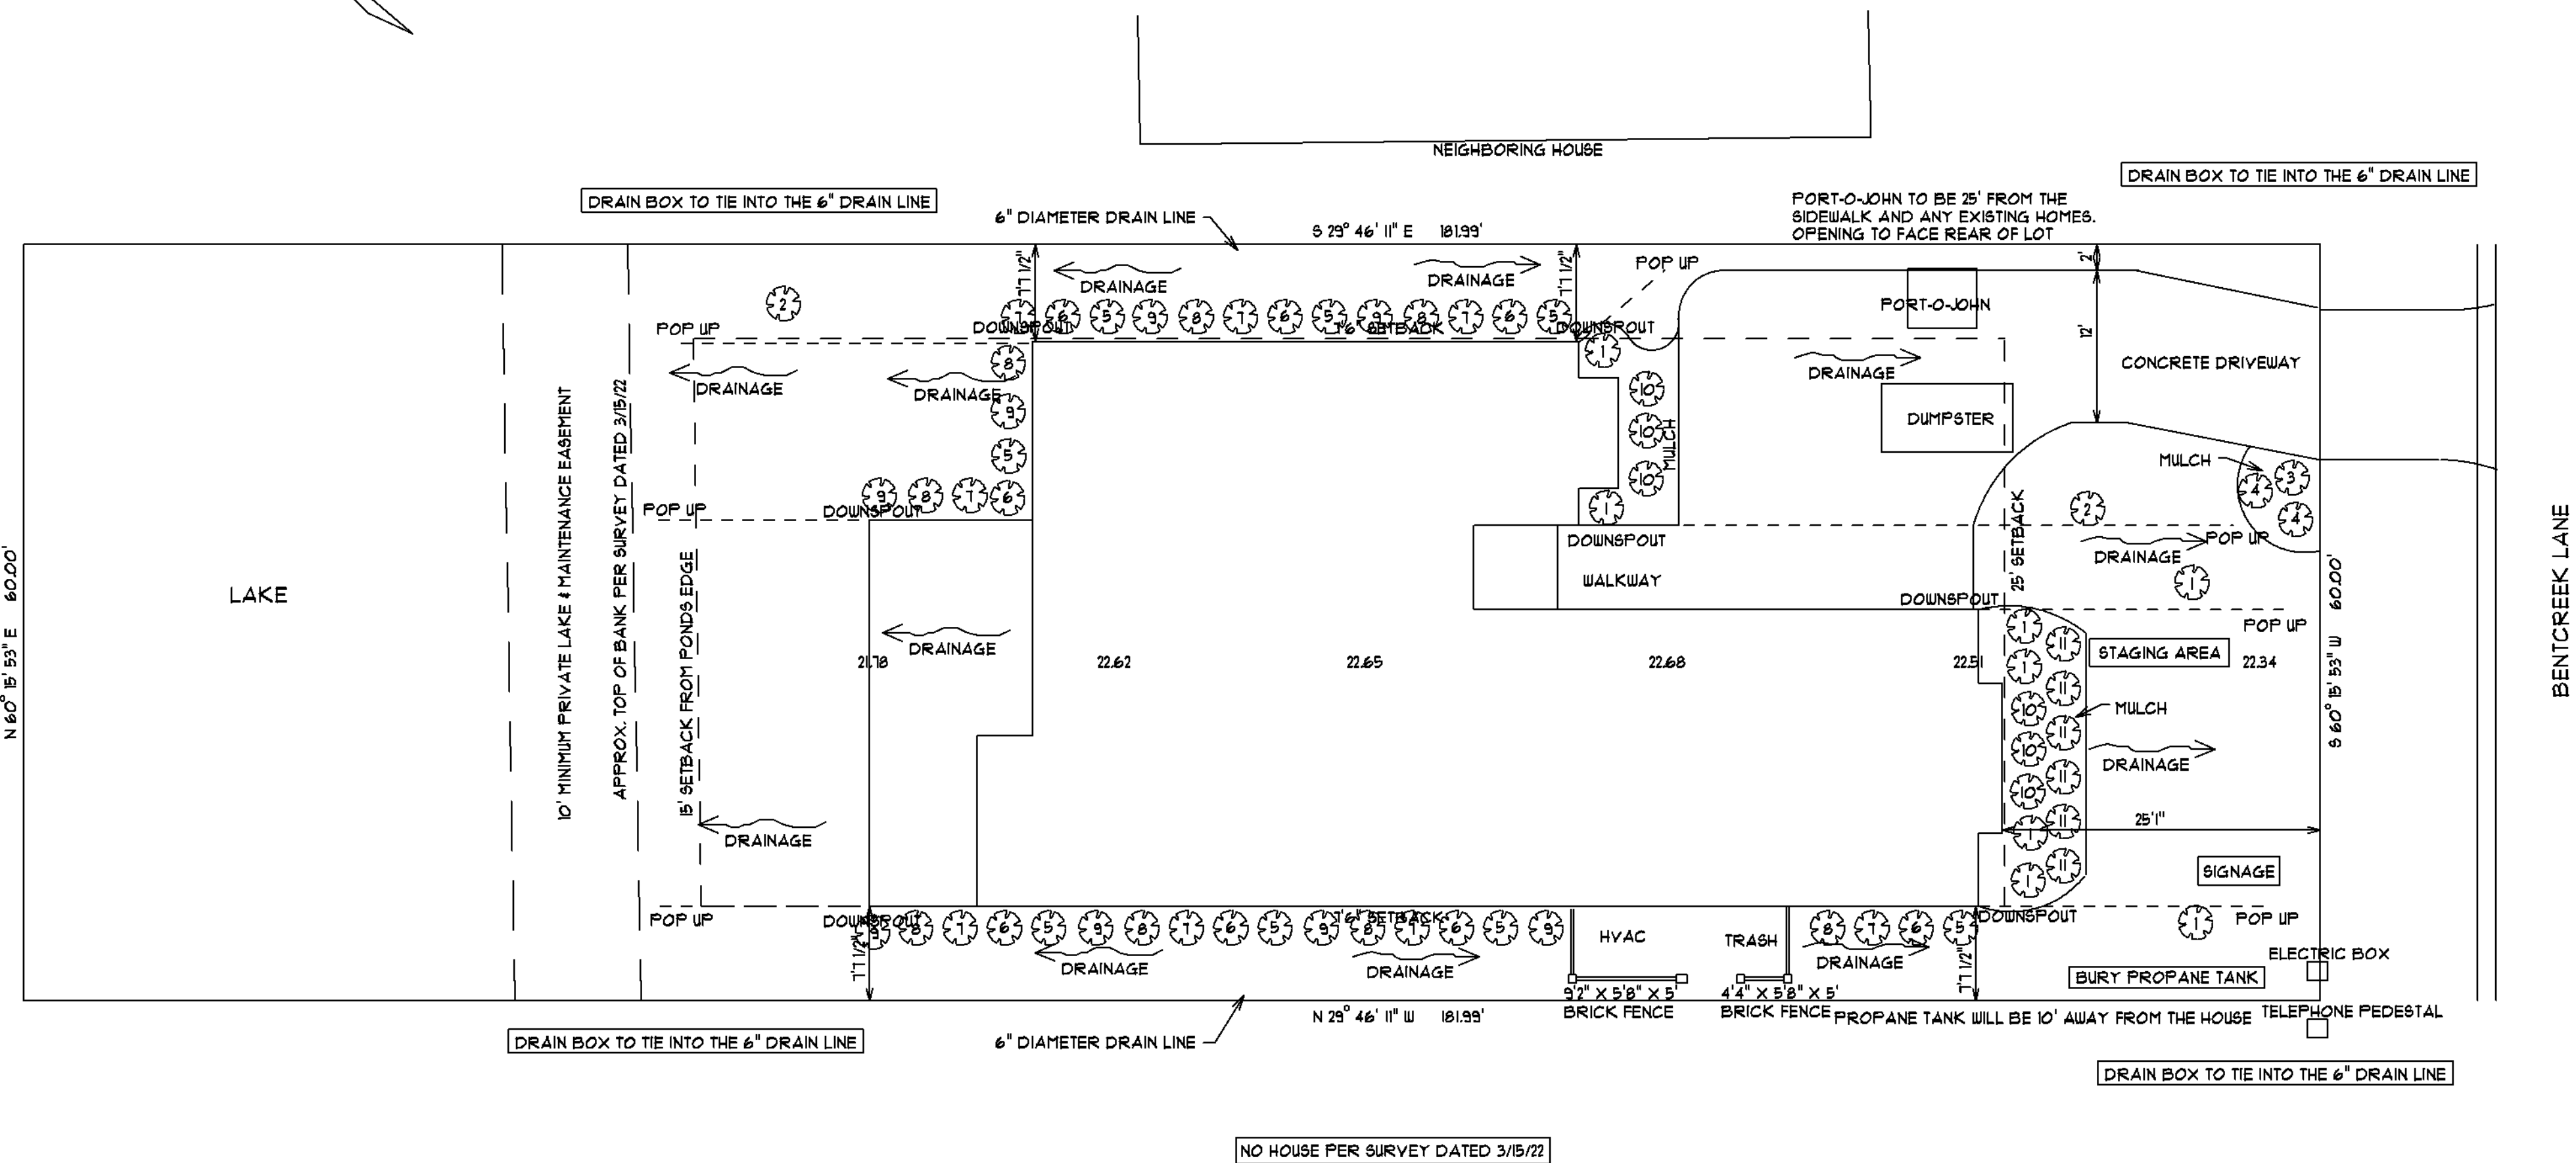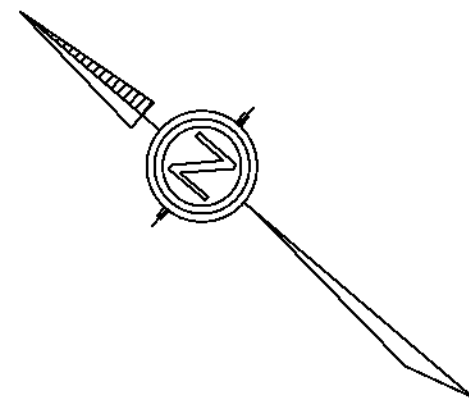

- PLANT LIST:
- TOTAL OF 8 - 12' TALL FAN PALM
 - TOTAL OF 2 - MIN. 4" CALIPER/10' TALL PALM
 - TOTAL OF 1 - 3 GALLON OLEANDER
 - TOTAL OF 2 - 3 GALLON SWEET GRASS
 - TOTAL OF 8 - 1 GALLON MIN. AZALEA
 - TOTAL OF 8 - 3 GALLON BOXWOOD
 - TOTAL OF 8 - 1 GALLON MIN. KNOCK OUT ROSE
 - TOTAL OF 8 - 1 GALLON MIN. EVERGREEN
 - TOTAL OF 8 - 1 GALLON MIN. TEA OLIVE
 - TOTAL OF 6 - JACK FROST
 - TOTAL OF 6 - HAWAII TI

PAULA BURGIN
341 CROOKED OAK DRIVE
PAULEY'S ISLAND, SC 29585
C (843) 283 - 5500
BURGINPAULA@AOL.COM

BUILDERS
DRAFTING & DESIGN

SCALE: 1" = 10'

DATE: 4/5/24

SHEET #10

LANDSCAPE
PLAN

JOB LOCATION:
LOT 333 BENTCREEK LANE
CAROLINA WATERWAY PLANTATION
MYRTLE BEACH, SC

SQUARE FOOTAGE:	2105	110	2815	1030	624	44	333	4906
1ST FLOOR HEATED								
2ND FLOOR HEATED								
TOTAL HEATED SPACE								
UNHEATED/UNHEATED								
STORAGE								
GARAGE								
ENTRY PORCH								
COVERED PORCH								
TOTAL UNDER ROOF								

- NOTES:
1. 600' WHOLE YARD
 2. IRRIGATION SYSTEM W/AUTOMATIC TIMER TO BE INSTALLED TO PROVIDE FULL COVERAGE TO ALL GRASS & PLANTS
 3. INSTALL 6" DIAMETER FRENCH DRAINS ALONG PROPERTY LINE TO CARRY ALL WATER FLOW FROM UNDER GROUND. TIE IN ROOF GUTTER DOWNSPOUTS. ALL WATER FLOW MUST SHED TOWARD FRONT OF THE PROPERTY.

SNT HOLDINGS
LLC