




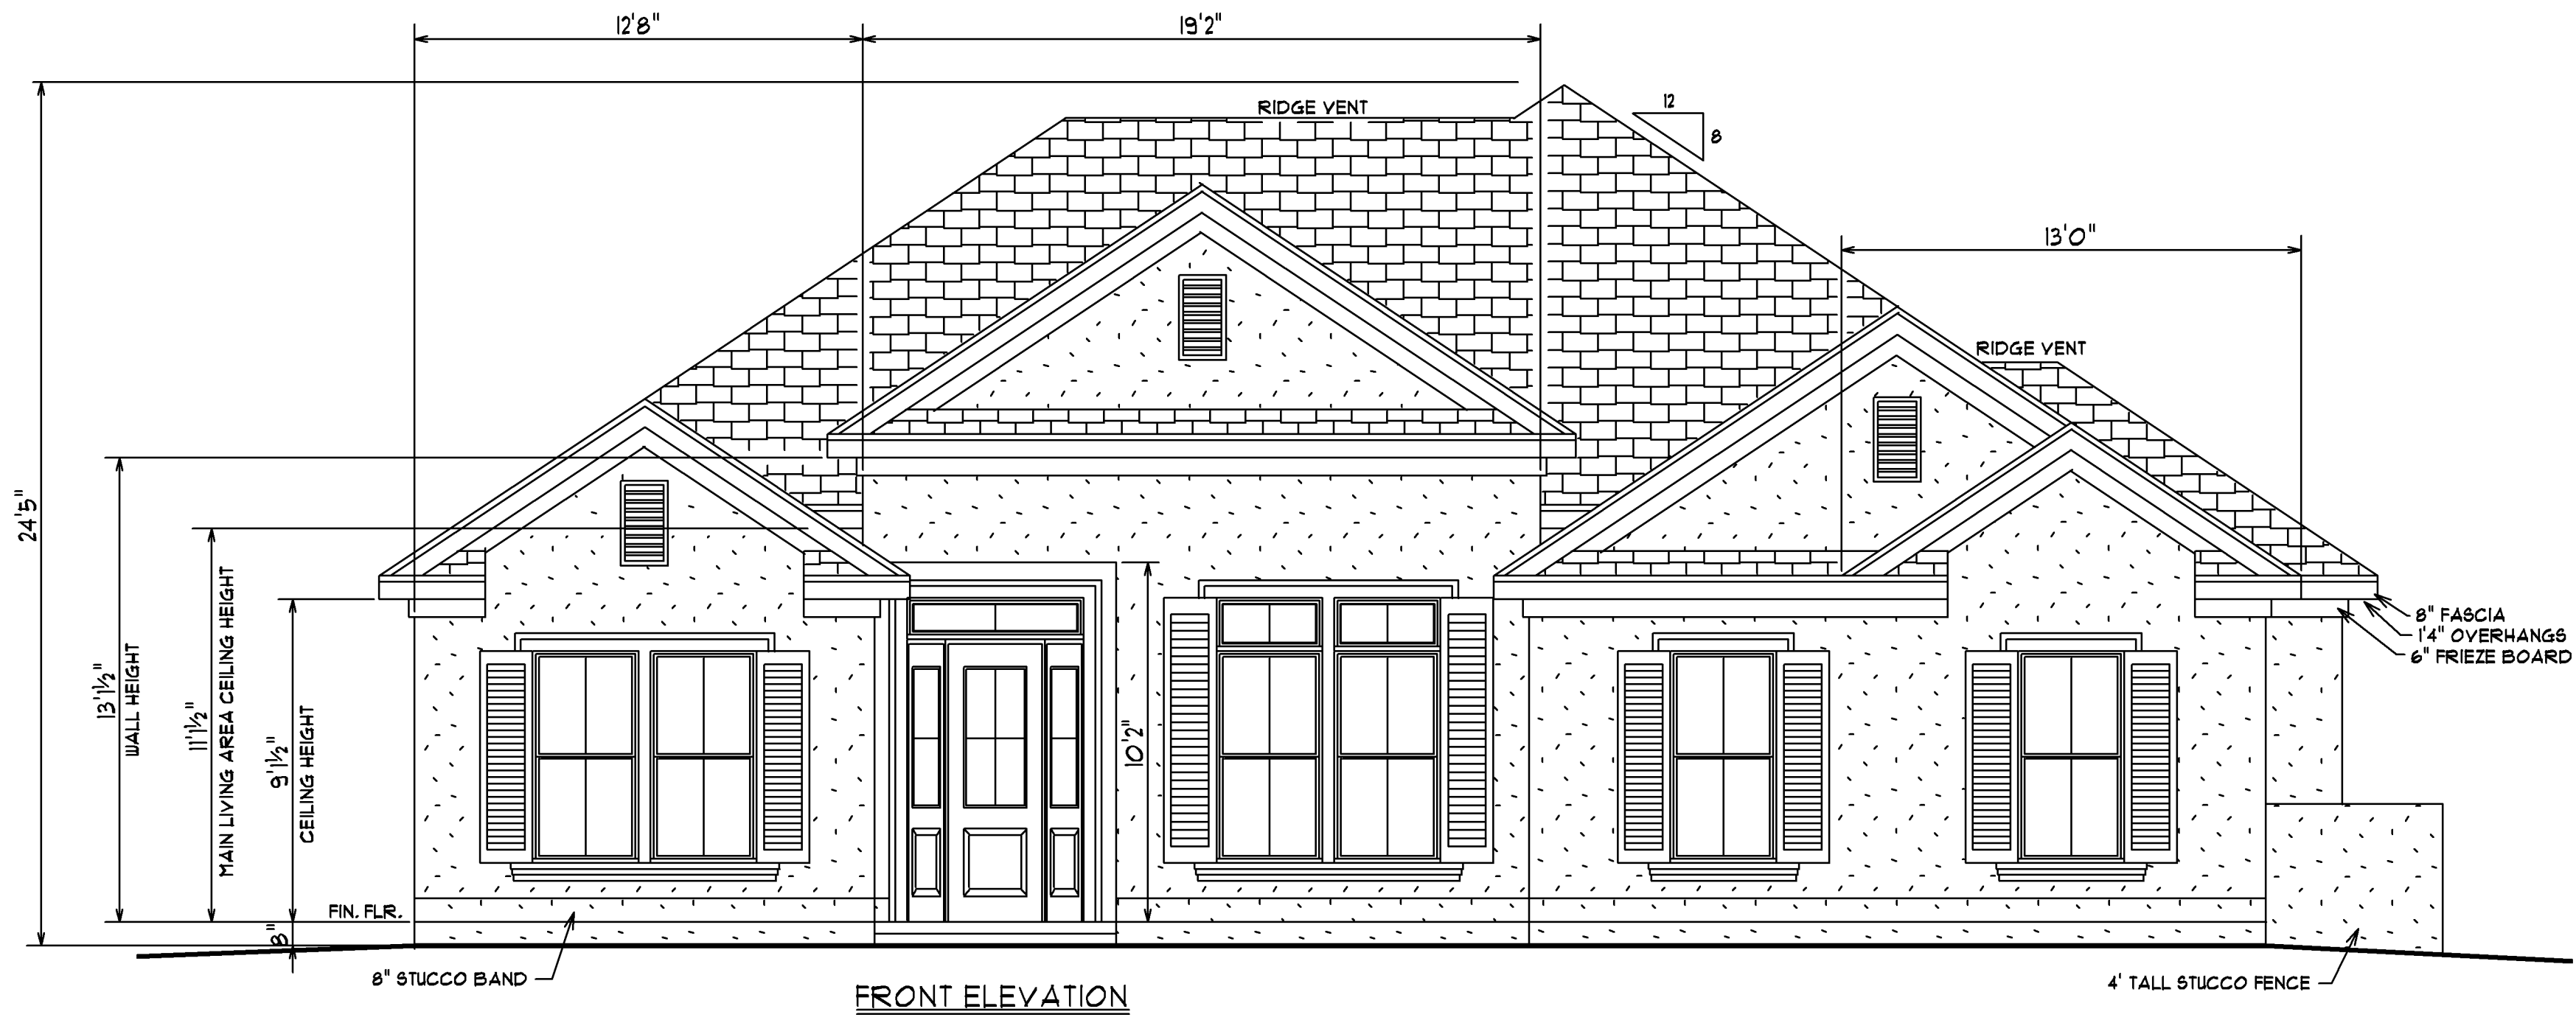


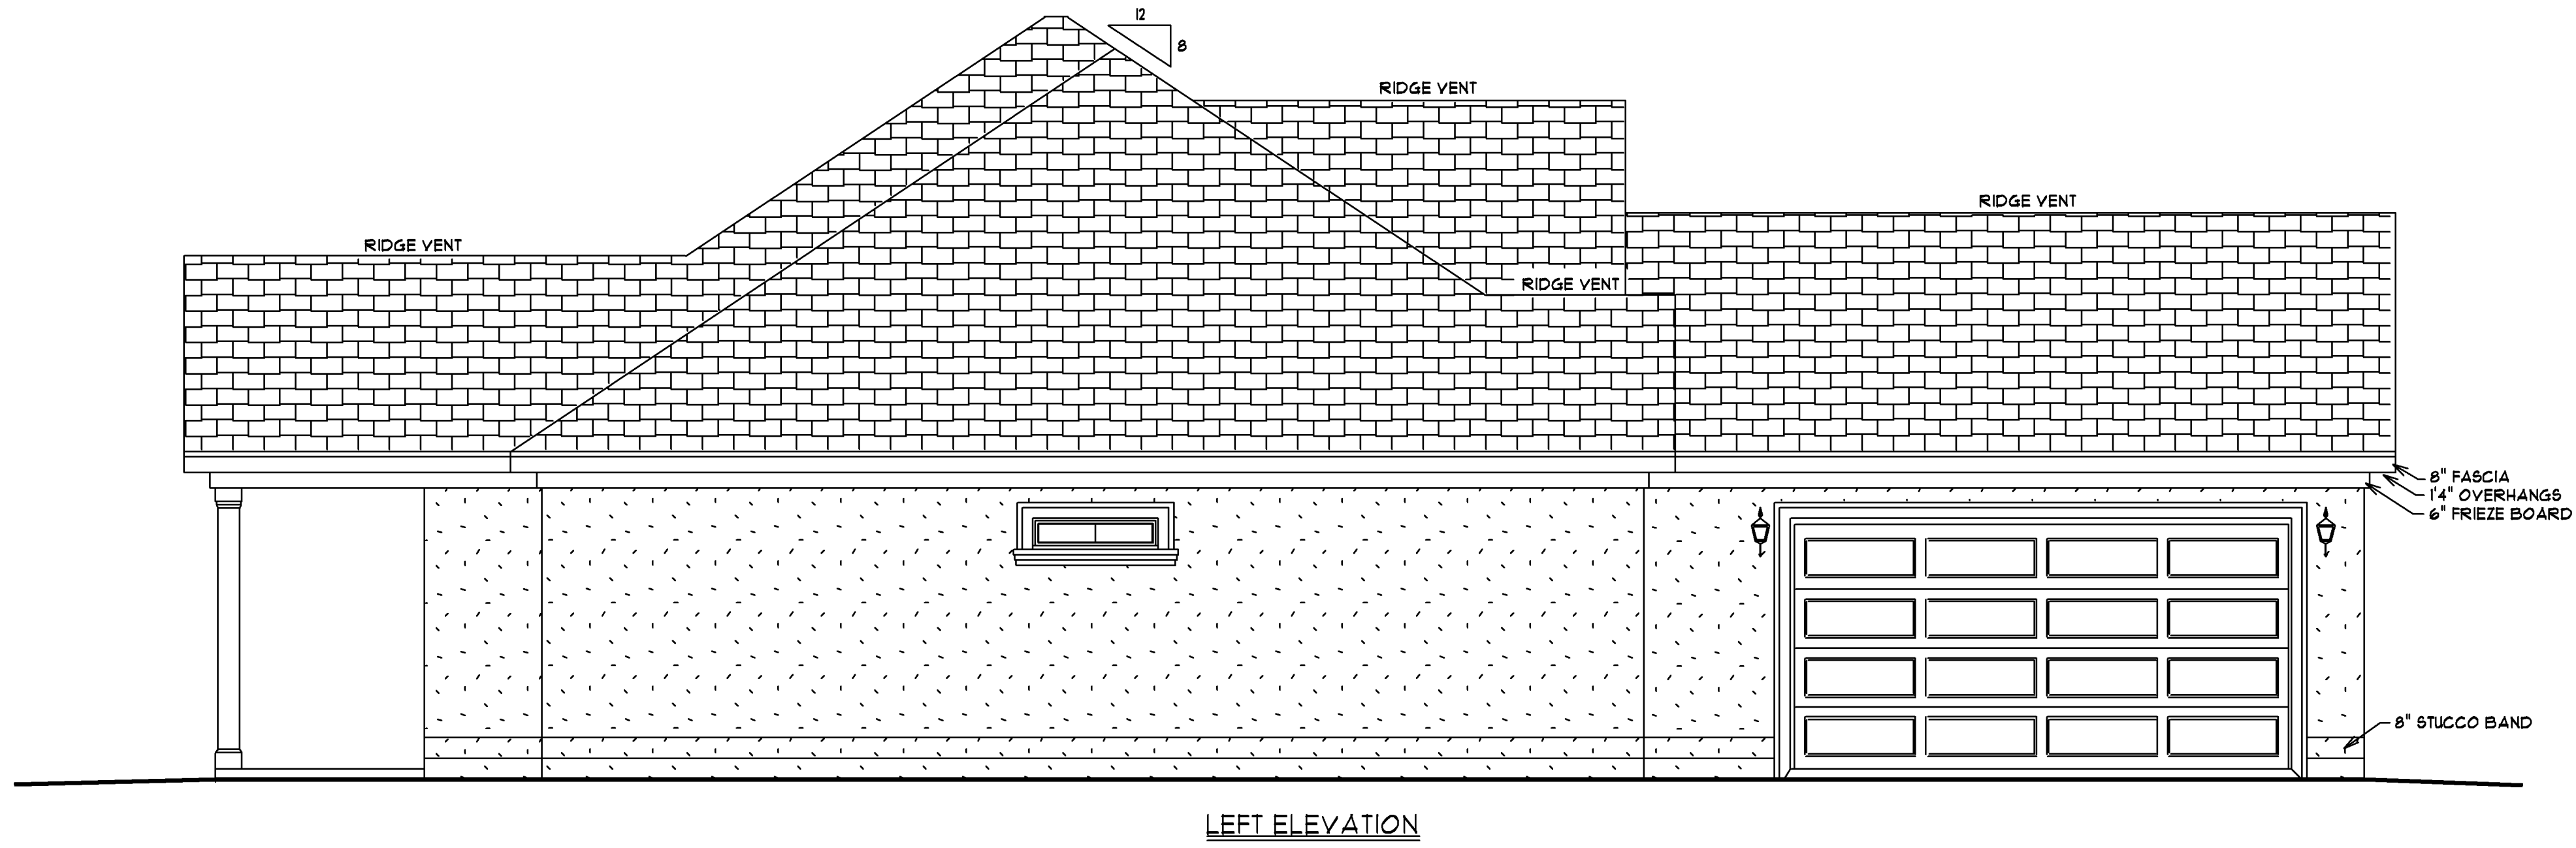


LEFT ELEVATION

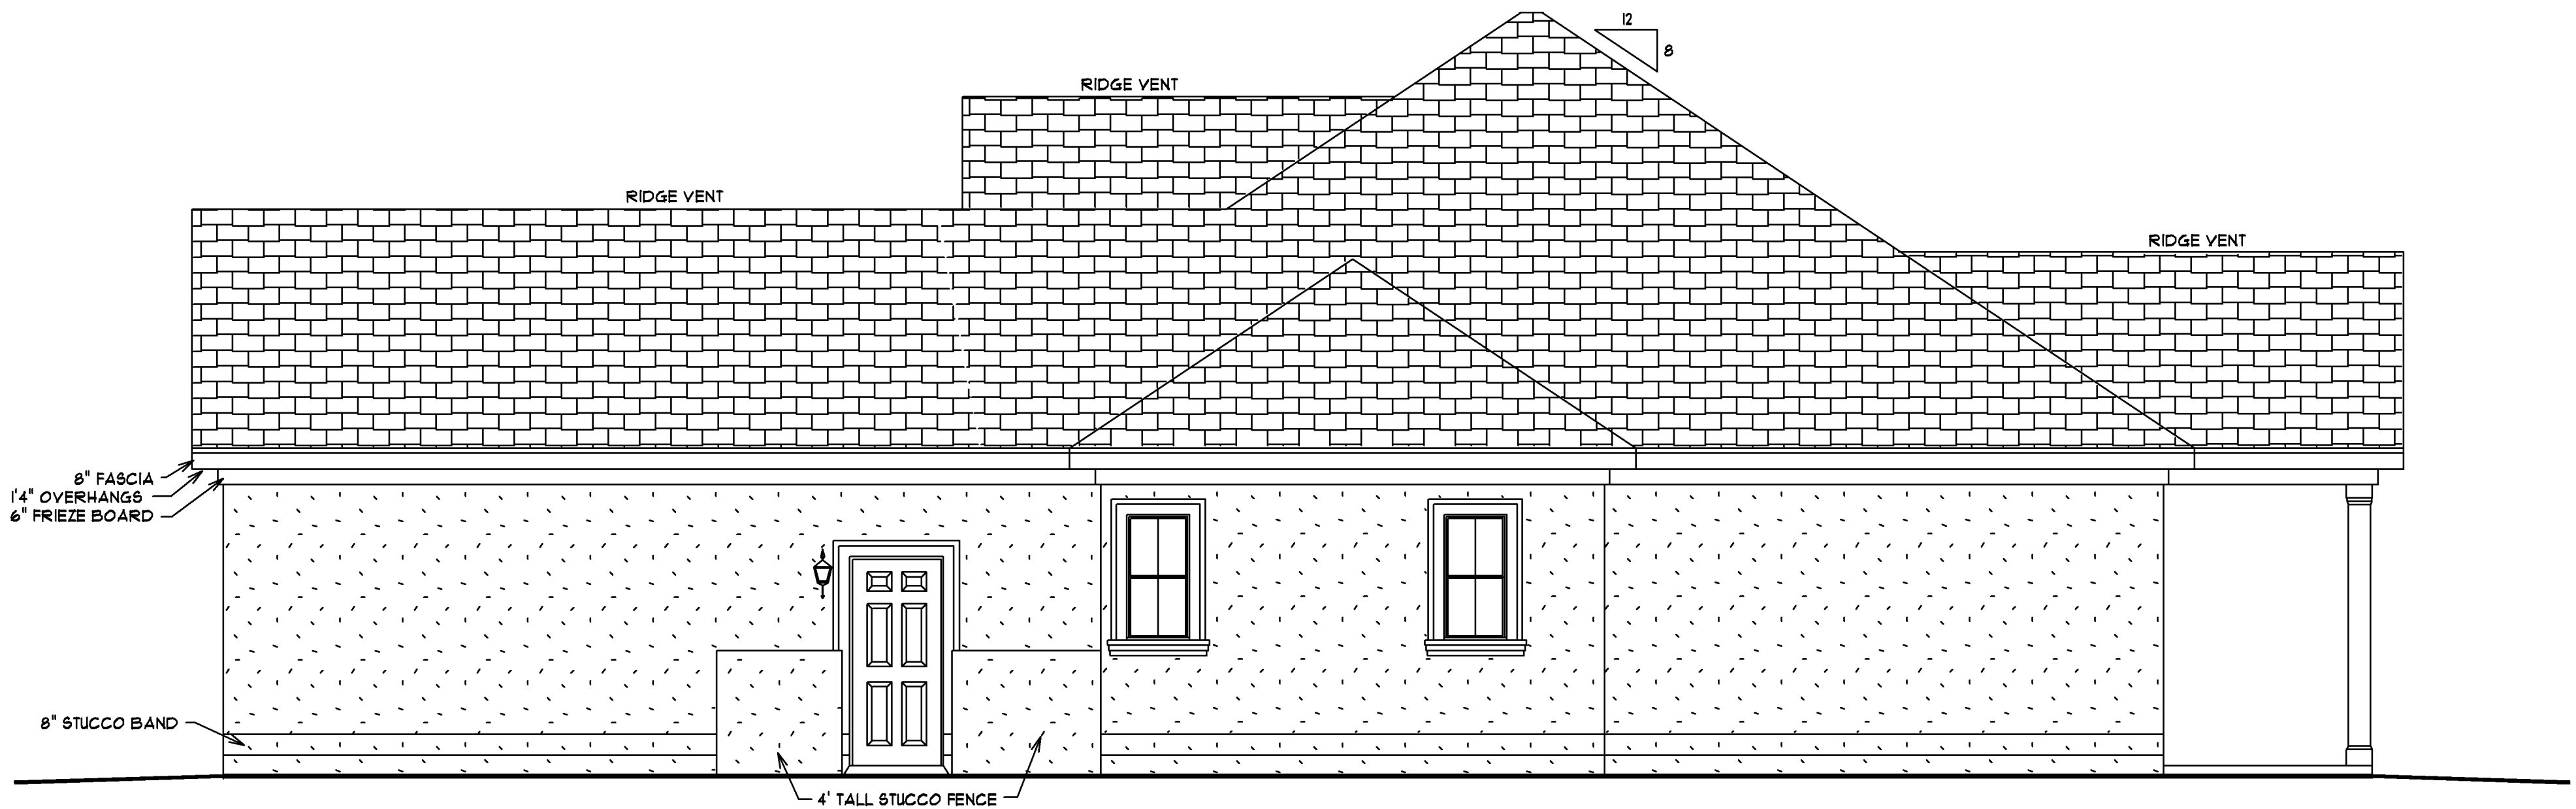


RIGHT ELEVATION

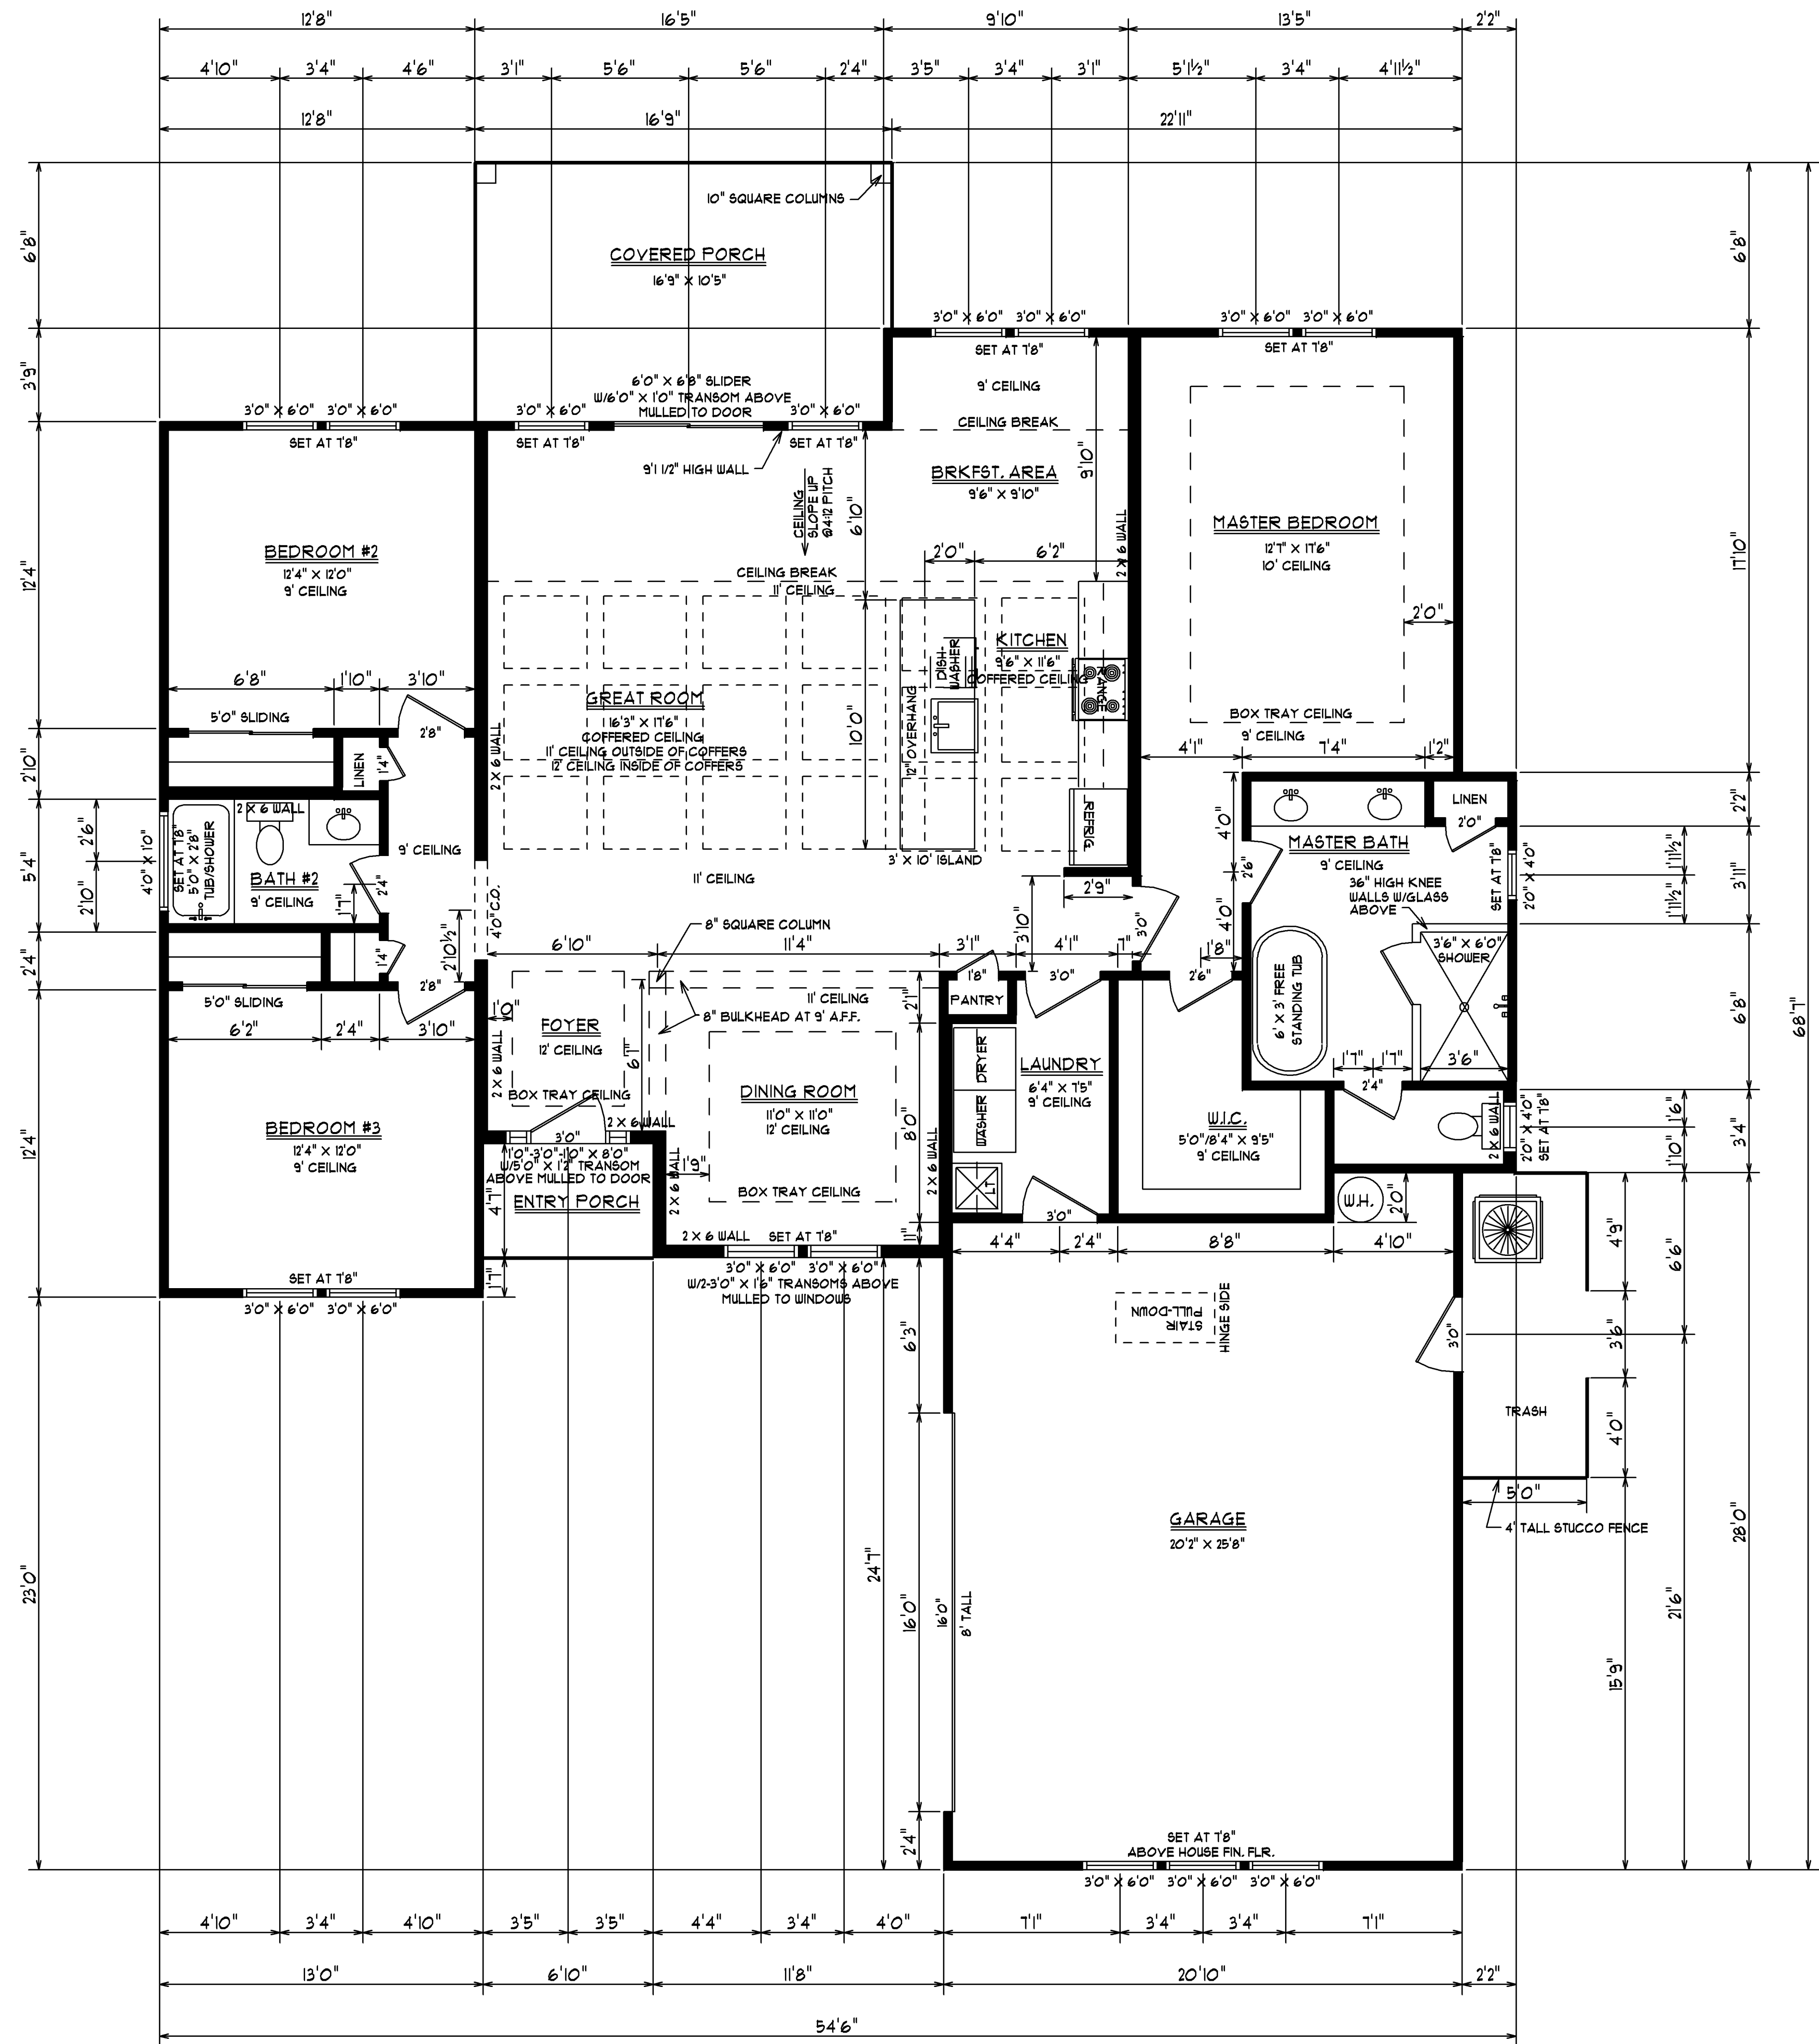

ELECTRICAL LEGEND	
SYMBOL	DESCRIPTION
	LIGHT
	RECESSED CAN LIGHT
	SWITCH
	3-WAY SWITCH
	220 OUTLET
	110 OUTLET
	GROUND FAULT INTERRUPTER
	TELEVISION
	TELEPHONE
	BATH FAN/LIGHT
	BATH FAN ONLY
	GARBAGE DISPOSAL
	SPEAKER
	DOORBELL BUTTON
	SMOKE DETECTOR
	DOUBLE FLOOD LIGHT
	HOSE BIB
	PREWIRED FAN/LIGHT

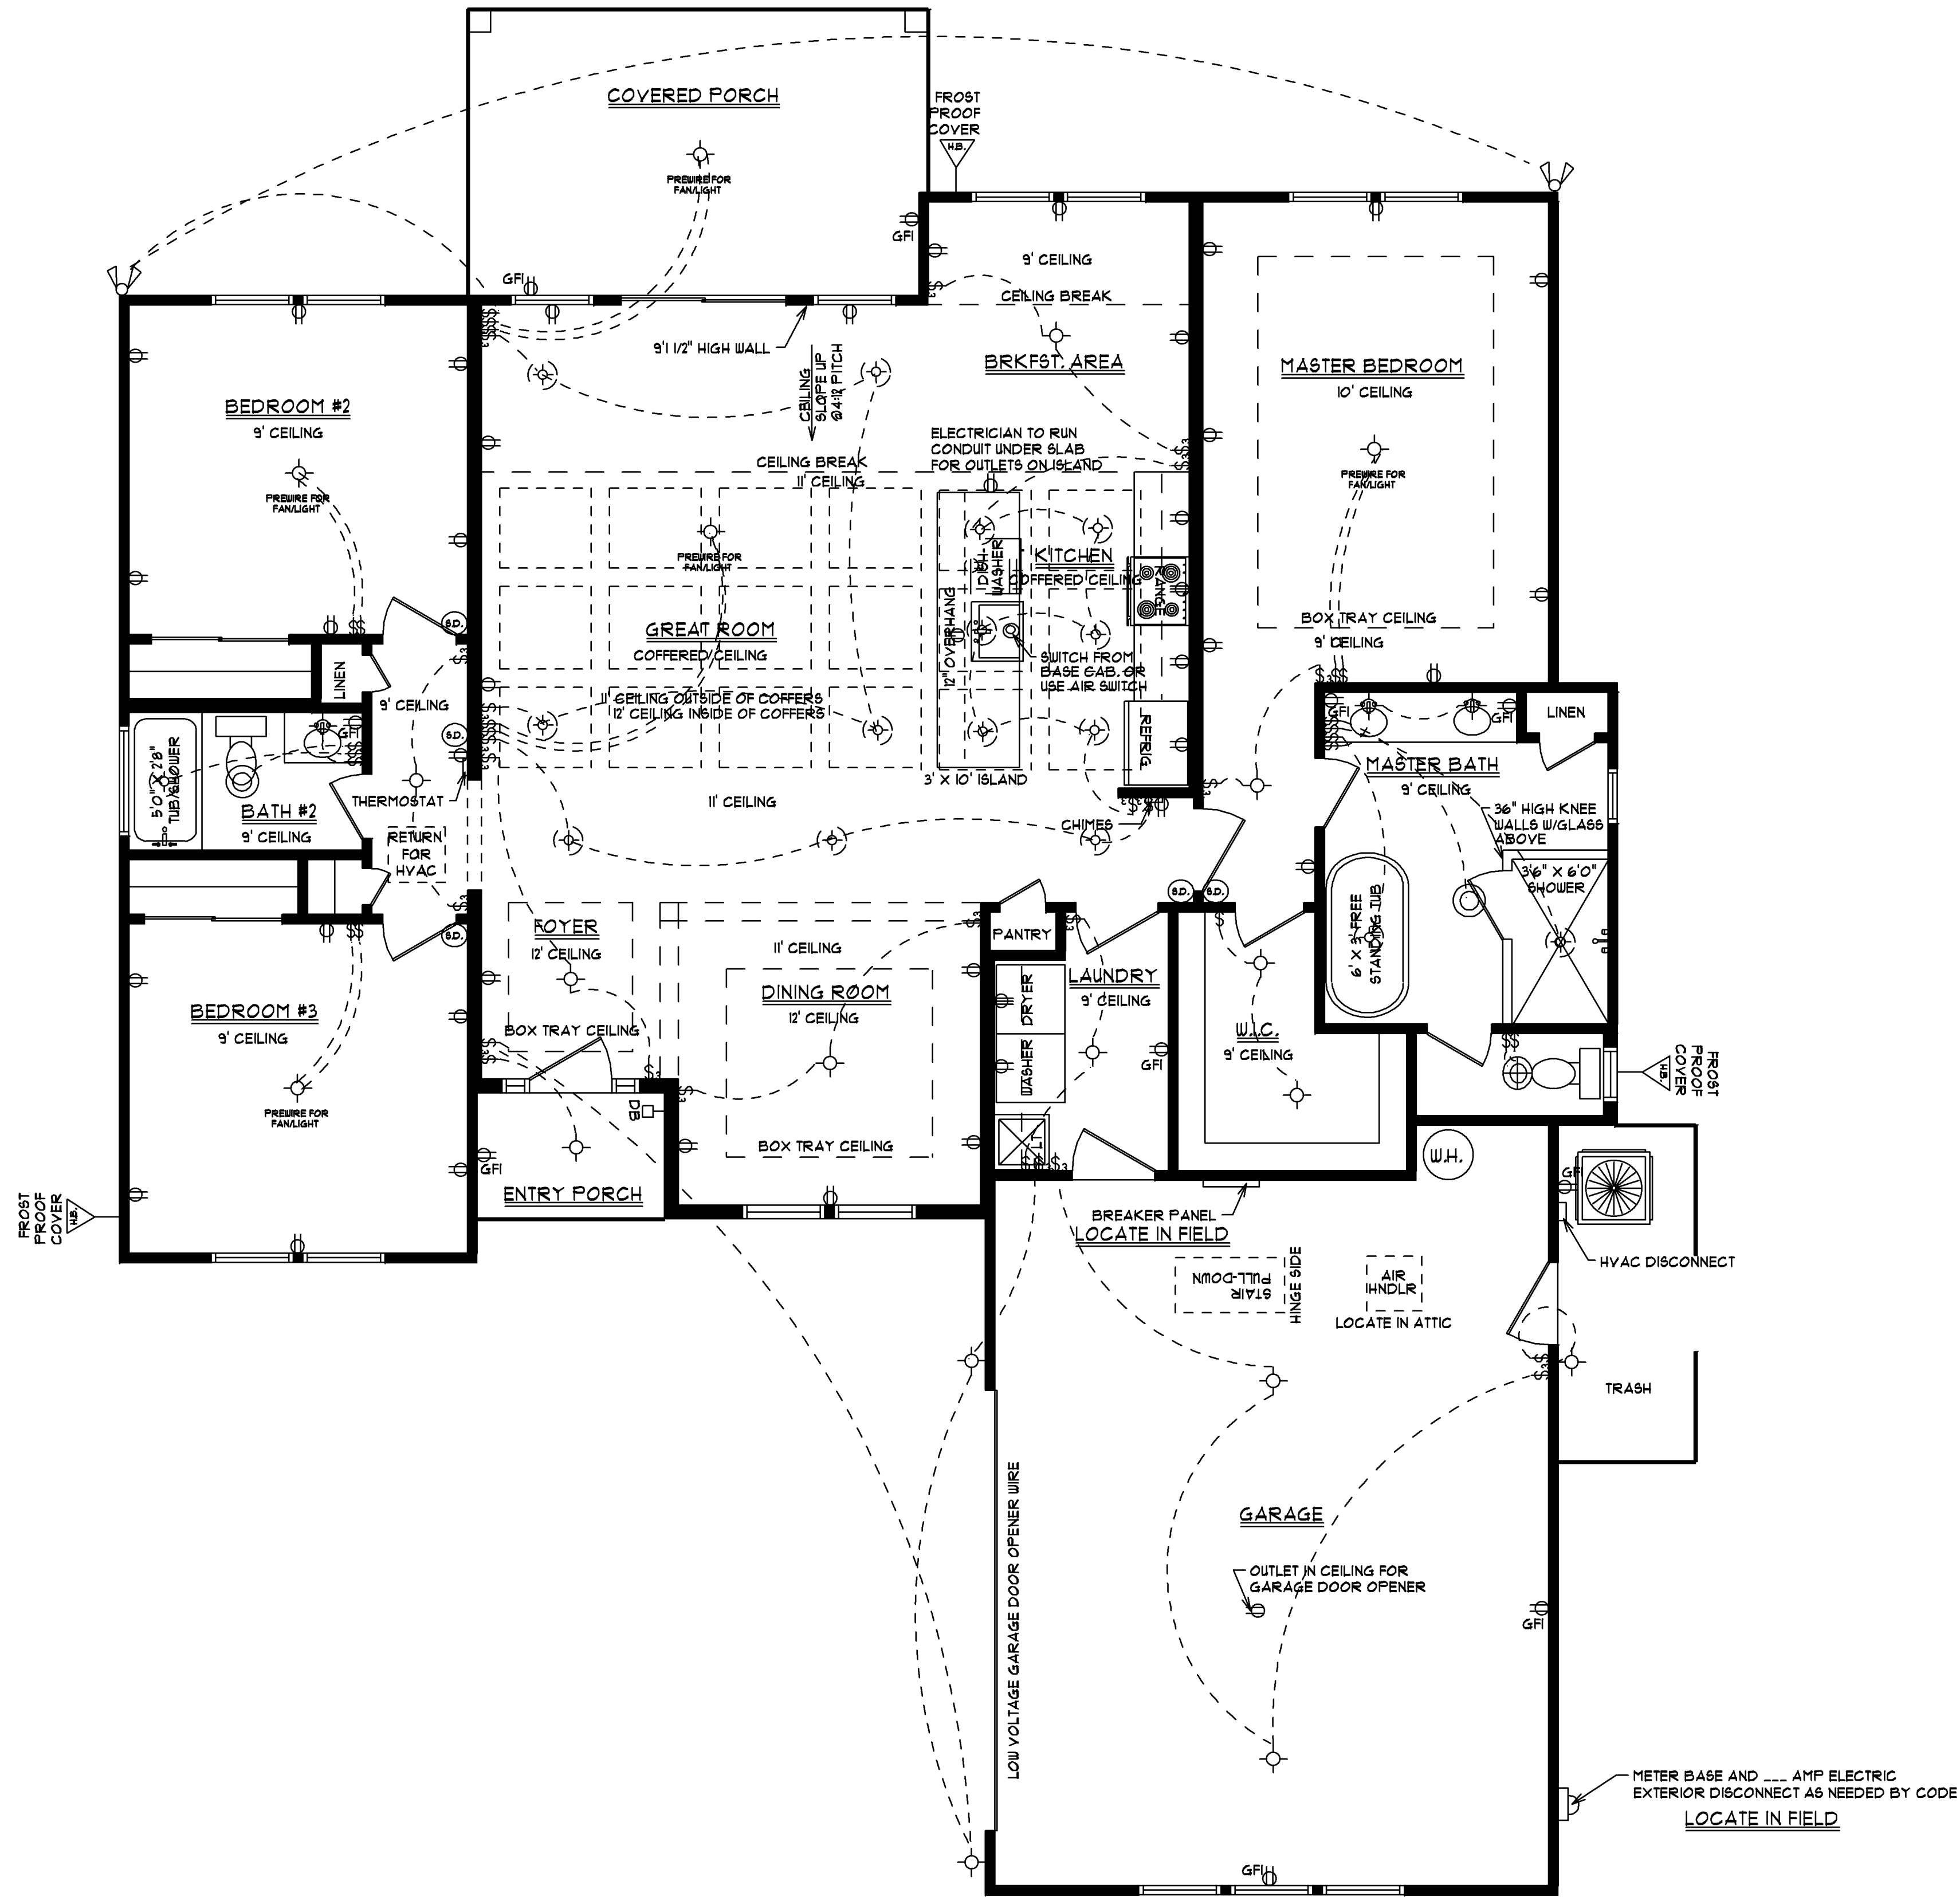

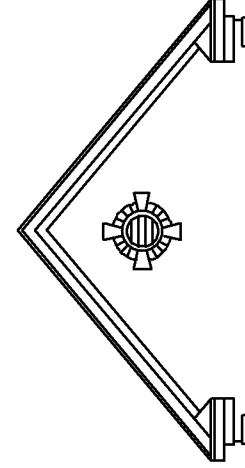

PAULA BURGIN
BUILDERS
DRAFTING & DESIGN

SCALE: 1/4" = 1'0"

DATE: 11/26/23




SHEET #4

ELECTRICAL

JOB LOCATION: LOT 182 HENRY JAMES DRIVE COVINGTON LAKES EAST MYRTLE BEACH, SC	
SQUARE FOOTAGE: HEATED SPACE GARAGE ENTRY PORCH COVERED PORCH TOTAL UNDER ROOF	1830 551 31 173 2585



PAULA BURGIN
BUILDERS
DRAFTING & DESIGN

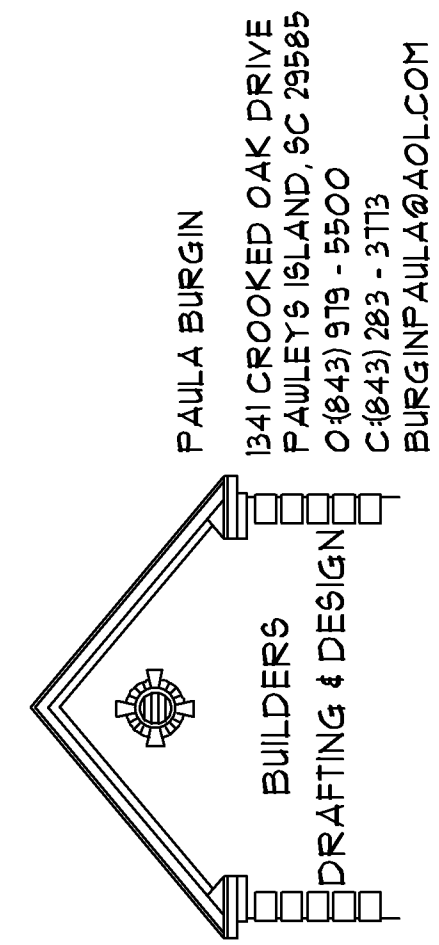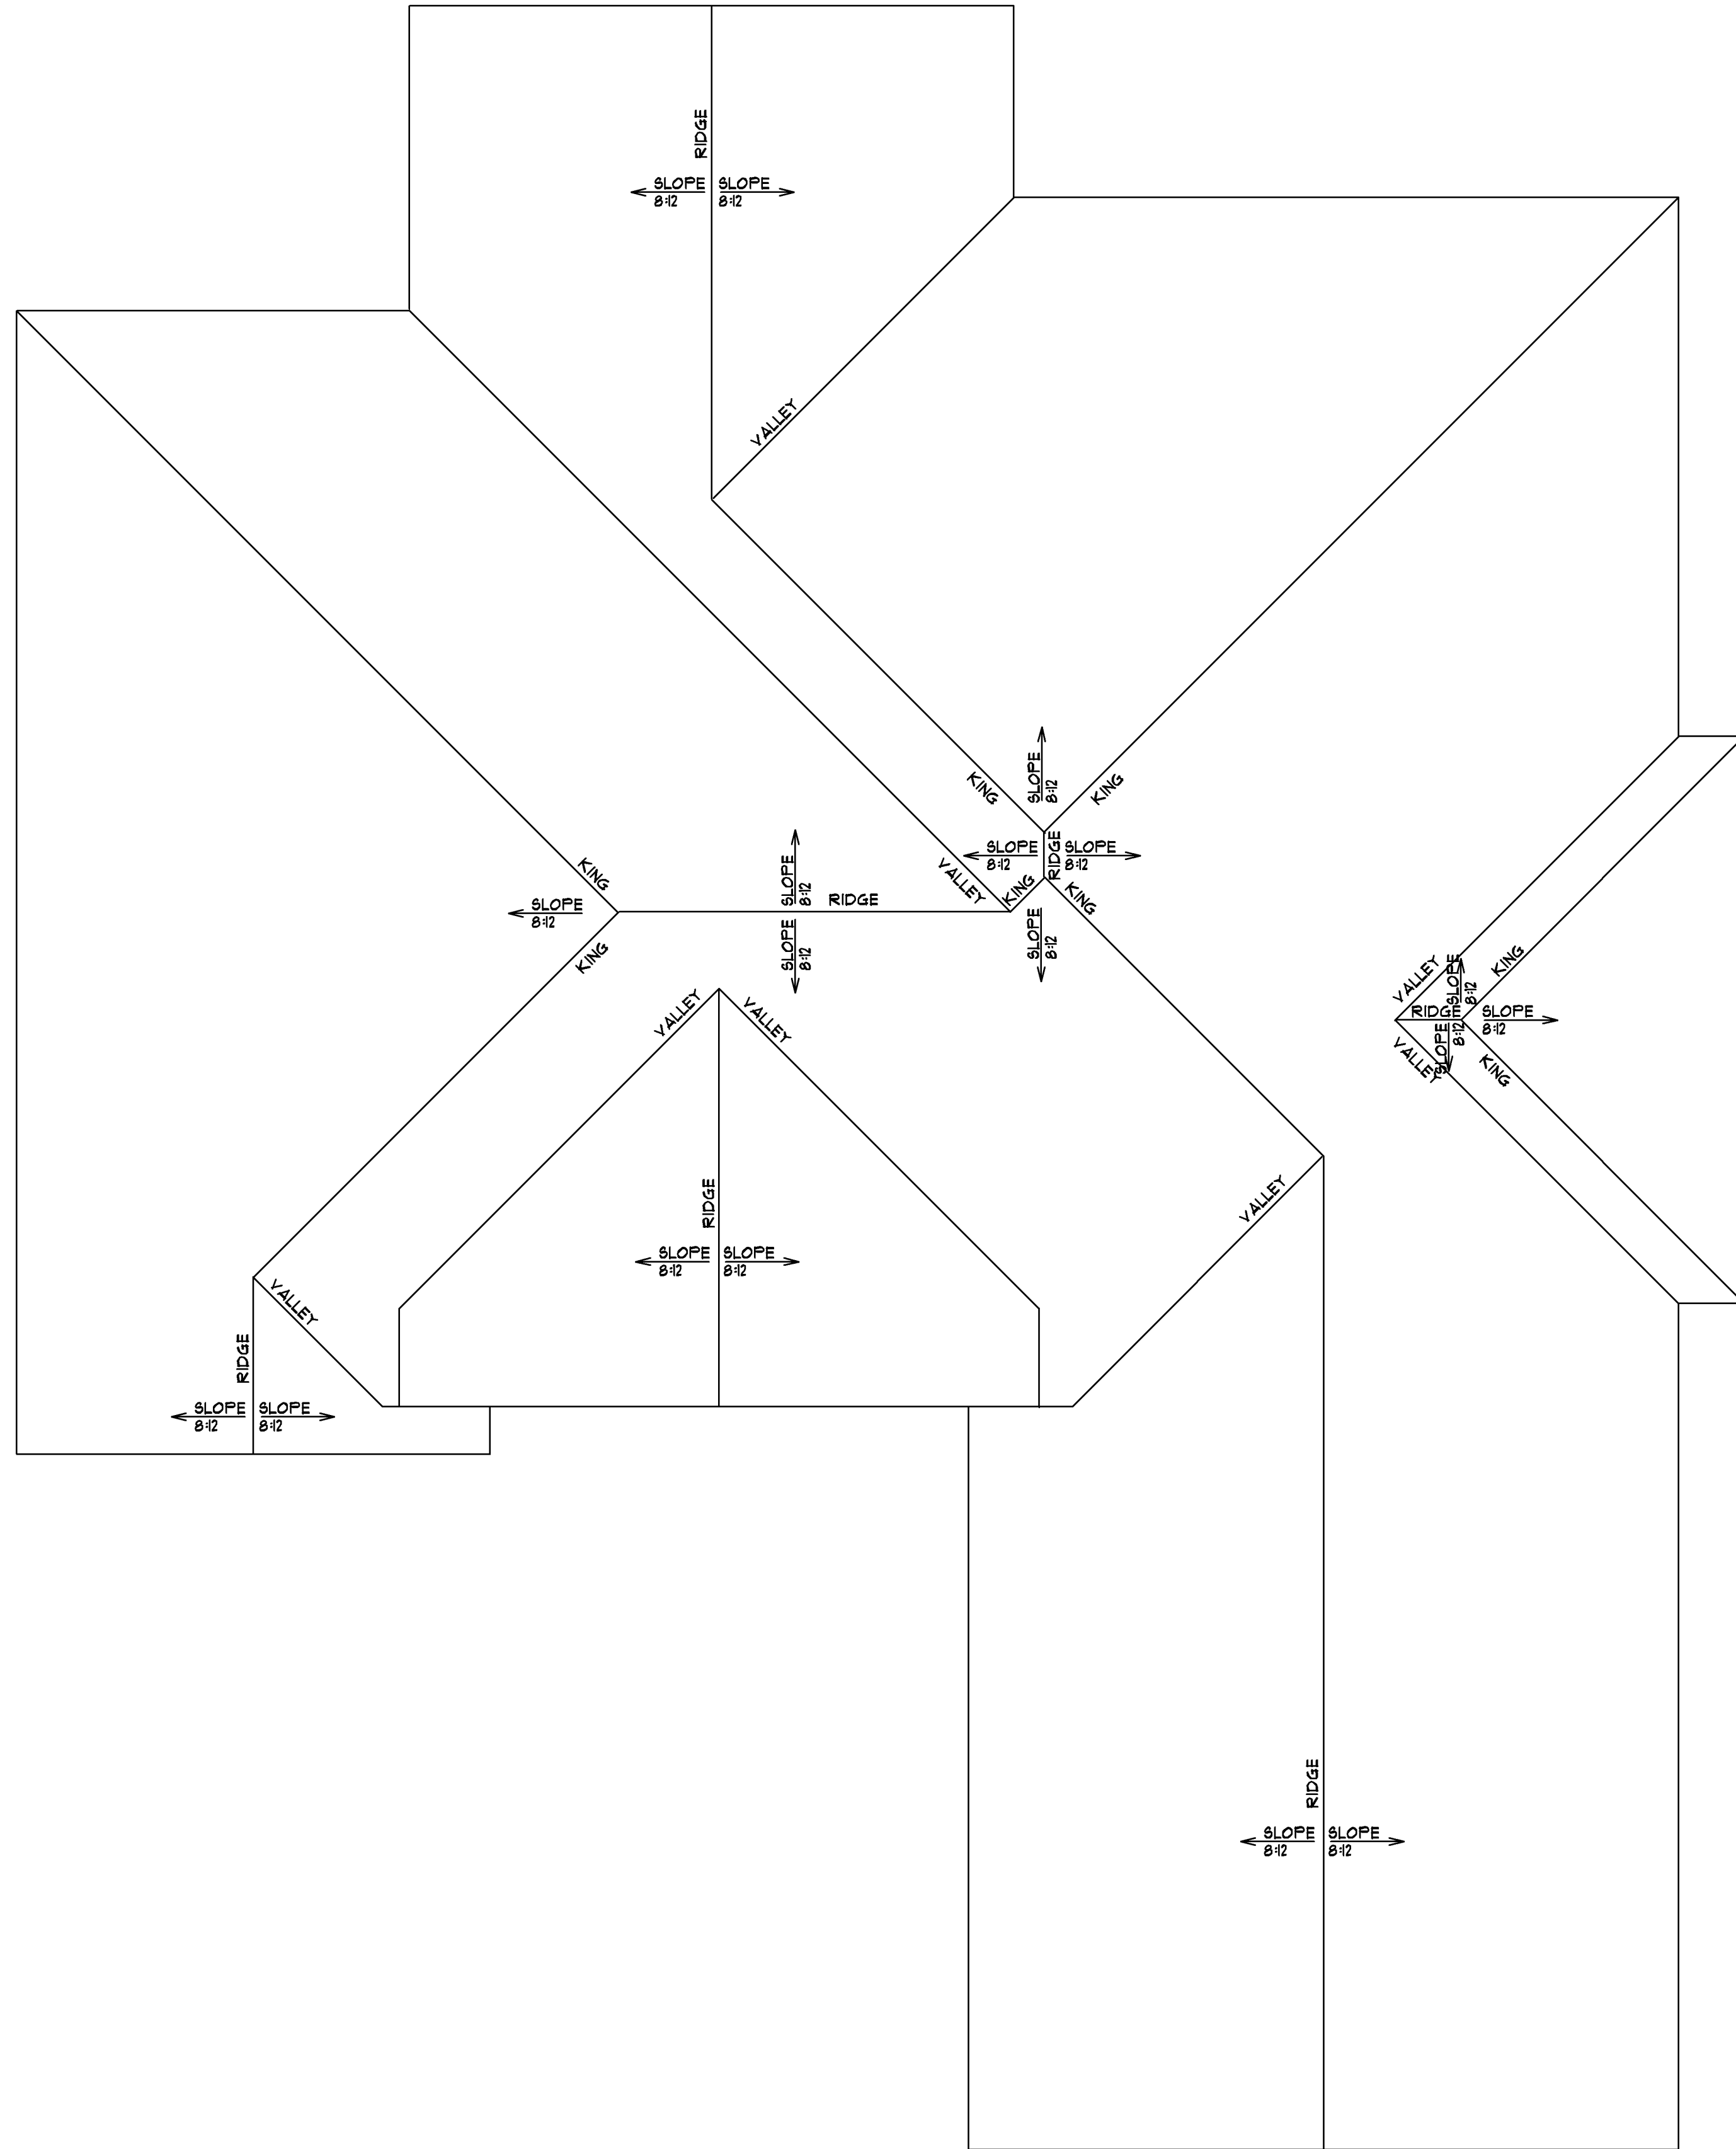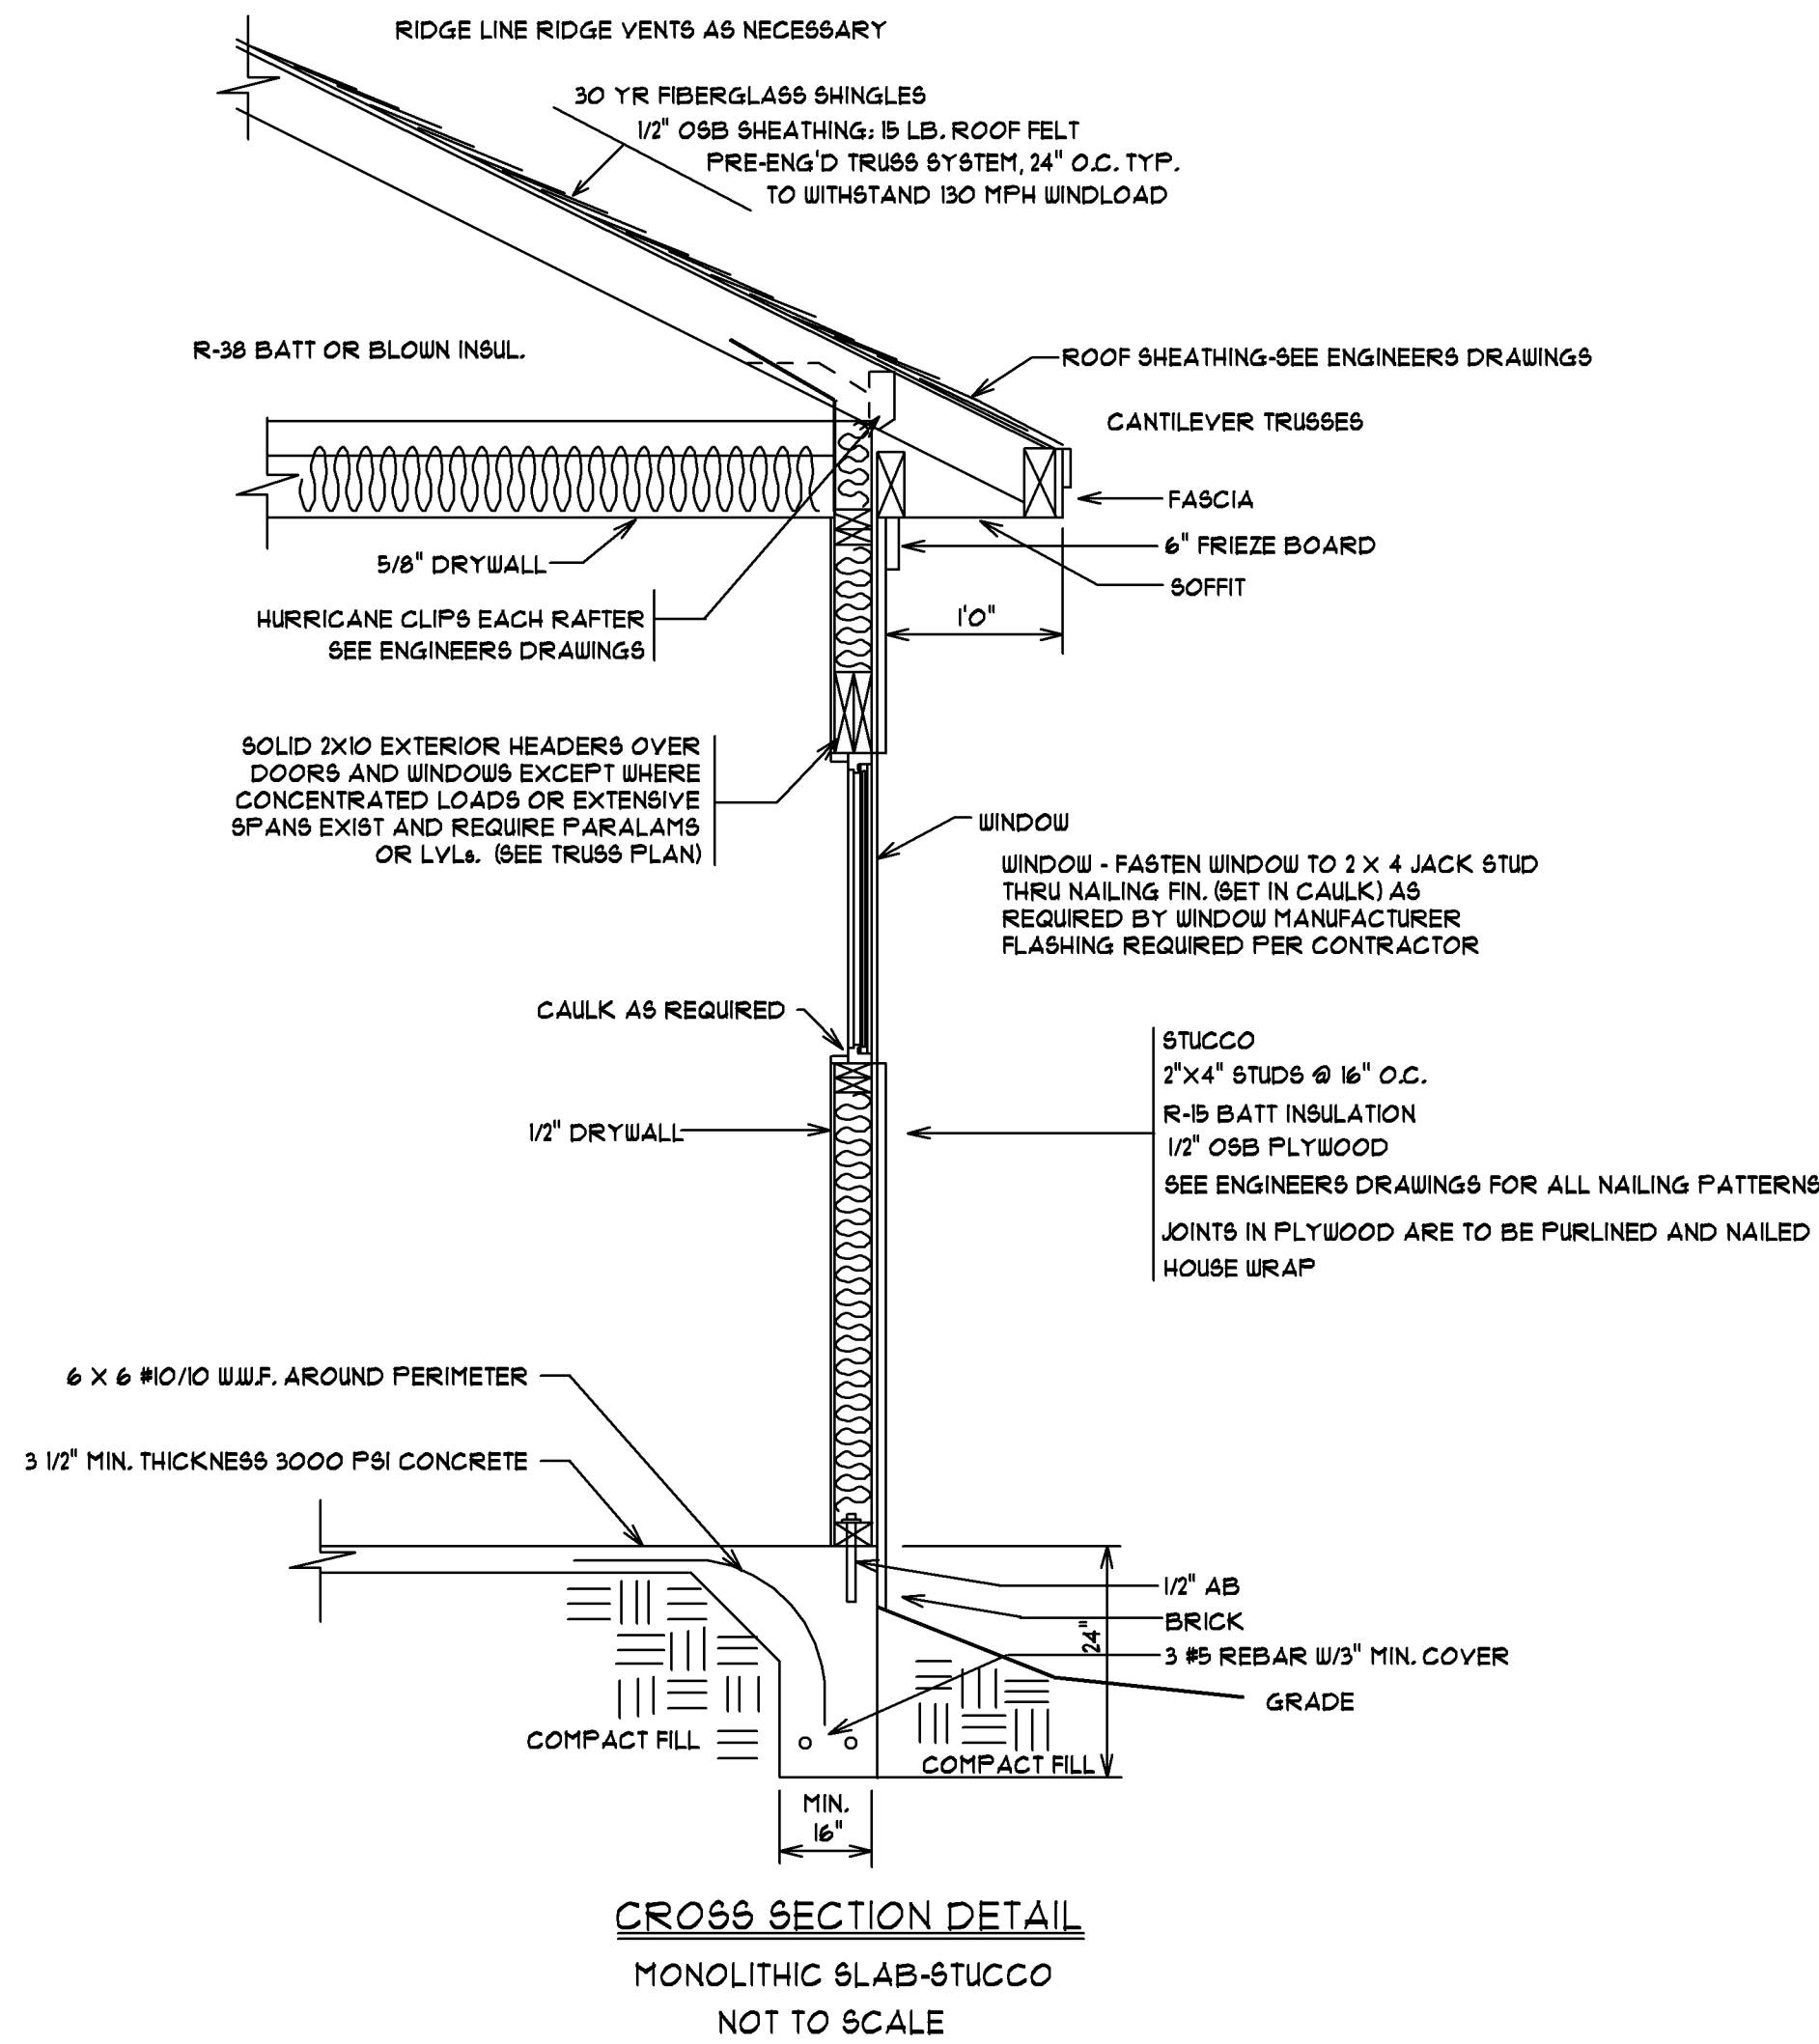

SCALE: 1/4" = 1'0"

DATE: 11/26/23

 

SHEET #5

ROOF PLAN/
DETAIL

JOB LOCATION:
LOT 182 HENRY JAMES DRIVE
COVINGTON LAKES EAST
MYRTLE BEACH, SC

1830
551
31
173
2585

SQUARE FOOTAGE:
HEATED SPACE
GARAGE
ENTRY PORCH
COVERED PORCH
TOTAL UNDER ROOF

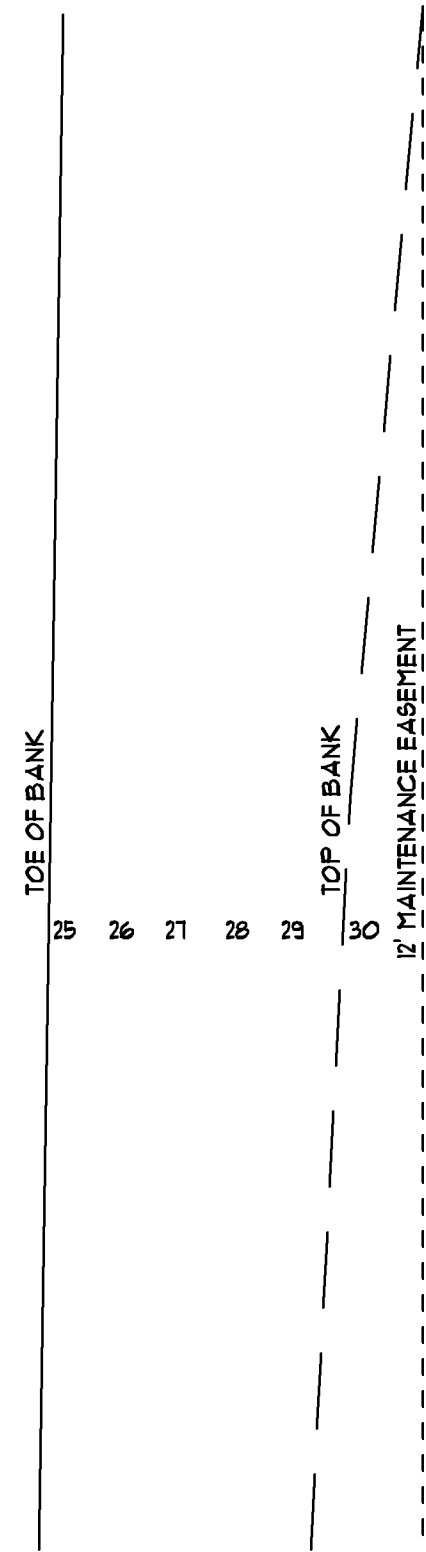

TOTAL OF 2 -		12' TALL FAN PALM
TOTAL OF 2 -		4" CALLIPER LIVE OAK
TOTAL OF 8 -		3 GALLON OLEANDER
TOTAL OF 8 -		3 GALLON SWEET GRASS
TOTAL OF 13 -		1 GALLON MIN. AZALEA
TOTAL OF 13 -		3 GALLON BOXWOOD
TOTAL OF 6 -		1 GALLON MIN. KNOCK OUT ROSE
TOTAL OF 6 -		1 GALLON MIN. EVERGREEN
TOTAL OF 6 -		1 GALLON MIN. TEA OLIVE

SQUARE FOOTAGE:	
HEATED SPACE	1830
GARAGE	551
ENTRY PORCH	31
COVERED PORCH	173
TOTAL UNDER ROOF	<u>2585</u>

JOB LOCATION:
LOT 182 HENRY JAMES DRIVE
COVINGTON LAKES EAST
MYRTLE BEACH, SC


6

T
T
T
T
S

NOTES

SCALE: 1" = 10'

DATE:11/26/23

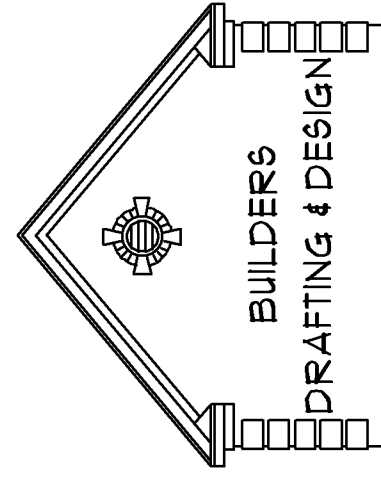

PAULA BURGIN
1341 CROOKED OAK DRIVE
PAWLEY'S ISLAND, SC 29585
O(843) 979 - 5500
C(843) 283 - 3773
BURGINPAULA@AOL.COM