



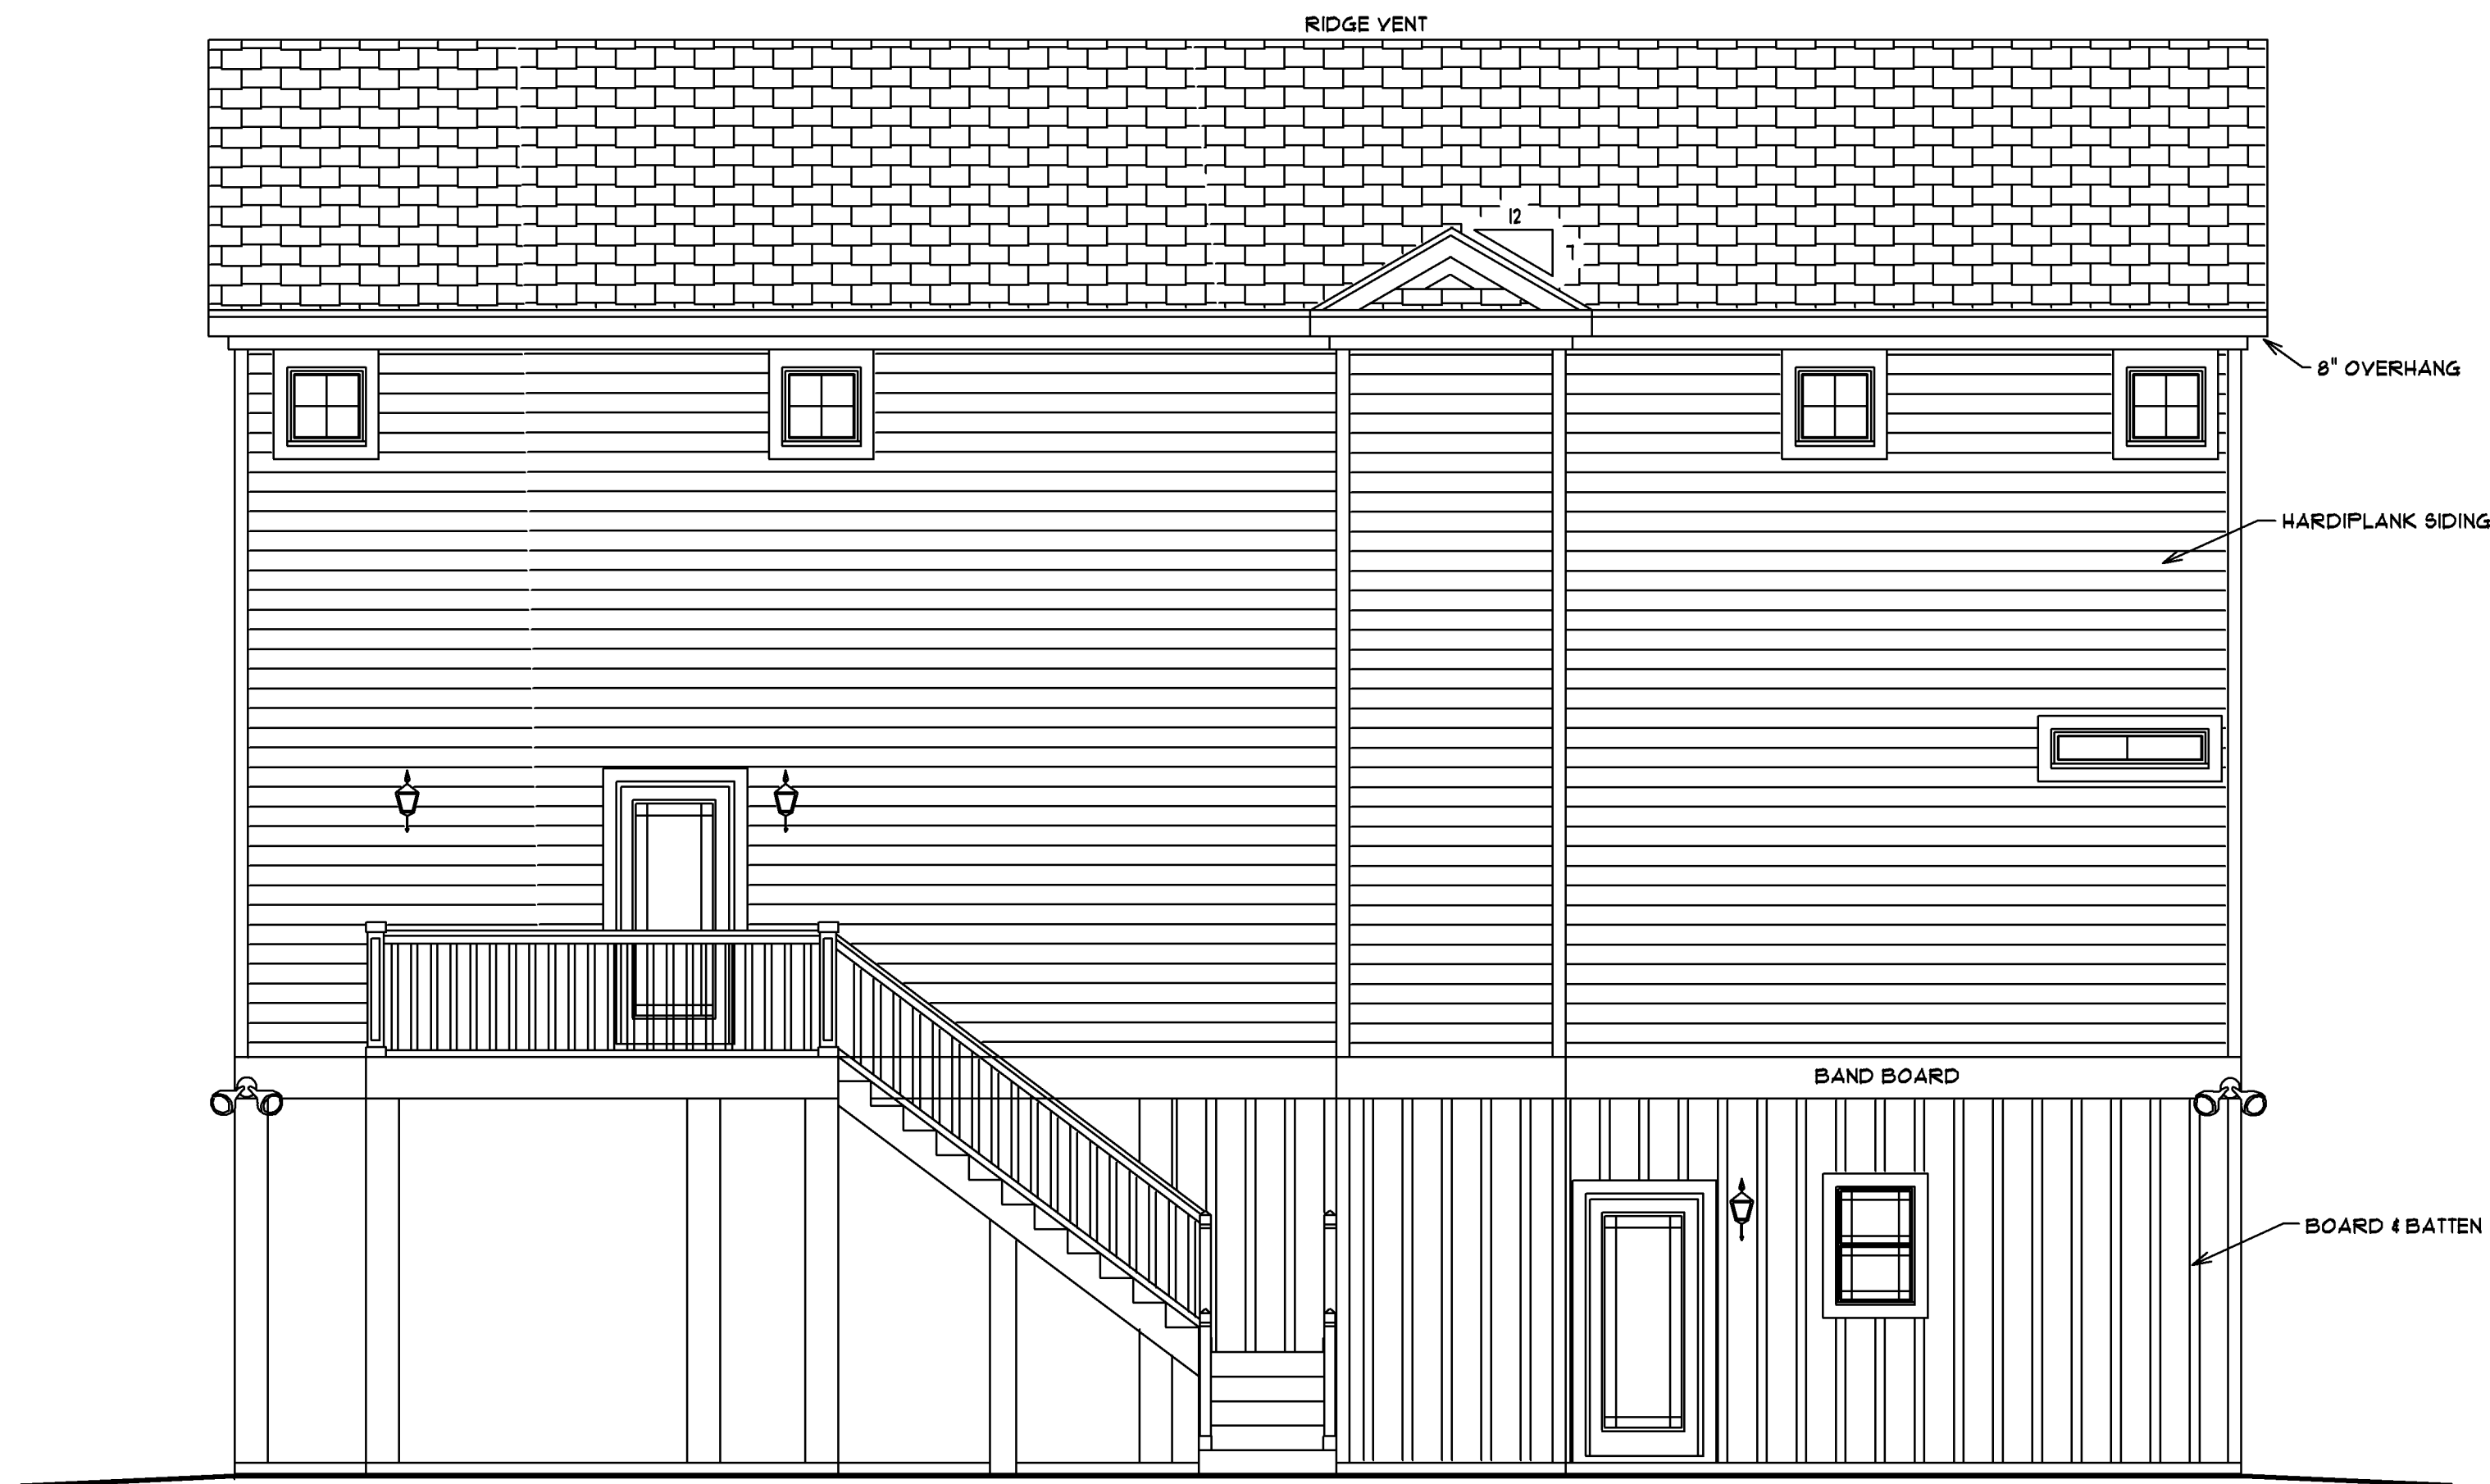

FRONT ELEVATION



REAR ELEVATION

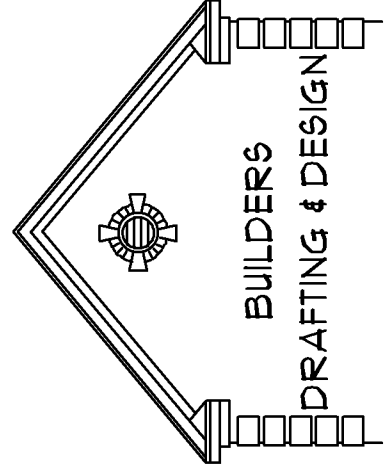

PAULA BURGIN
1341 CROOKED OAK DRIVE
PAULINE ISLAND, SC 29585
C18431 979 - 5500
BURGINPAULA@AOL.COM

SCALE: 1/4" = 1'0"

DATE 5/8/24


SHEET #1

ELEVATIONS

JOB LOCATION:
514 VISTA DRIVE
GARDEN CITY, SC

SQUARE FOOTAGE:	640
1ST FLOOR HEATED	1154
2ND FLOOR HEATED	1106
3RD FLOOR HEATED	2900
TOTAL HEATED SF/ACE	TO 4
PARKING	191
COVERED PATIOS	303
COVERED PORCHES	4104
TOTAL UNDER ROOF	72
DECK	


EXPERT
PROPERTIES LLC

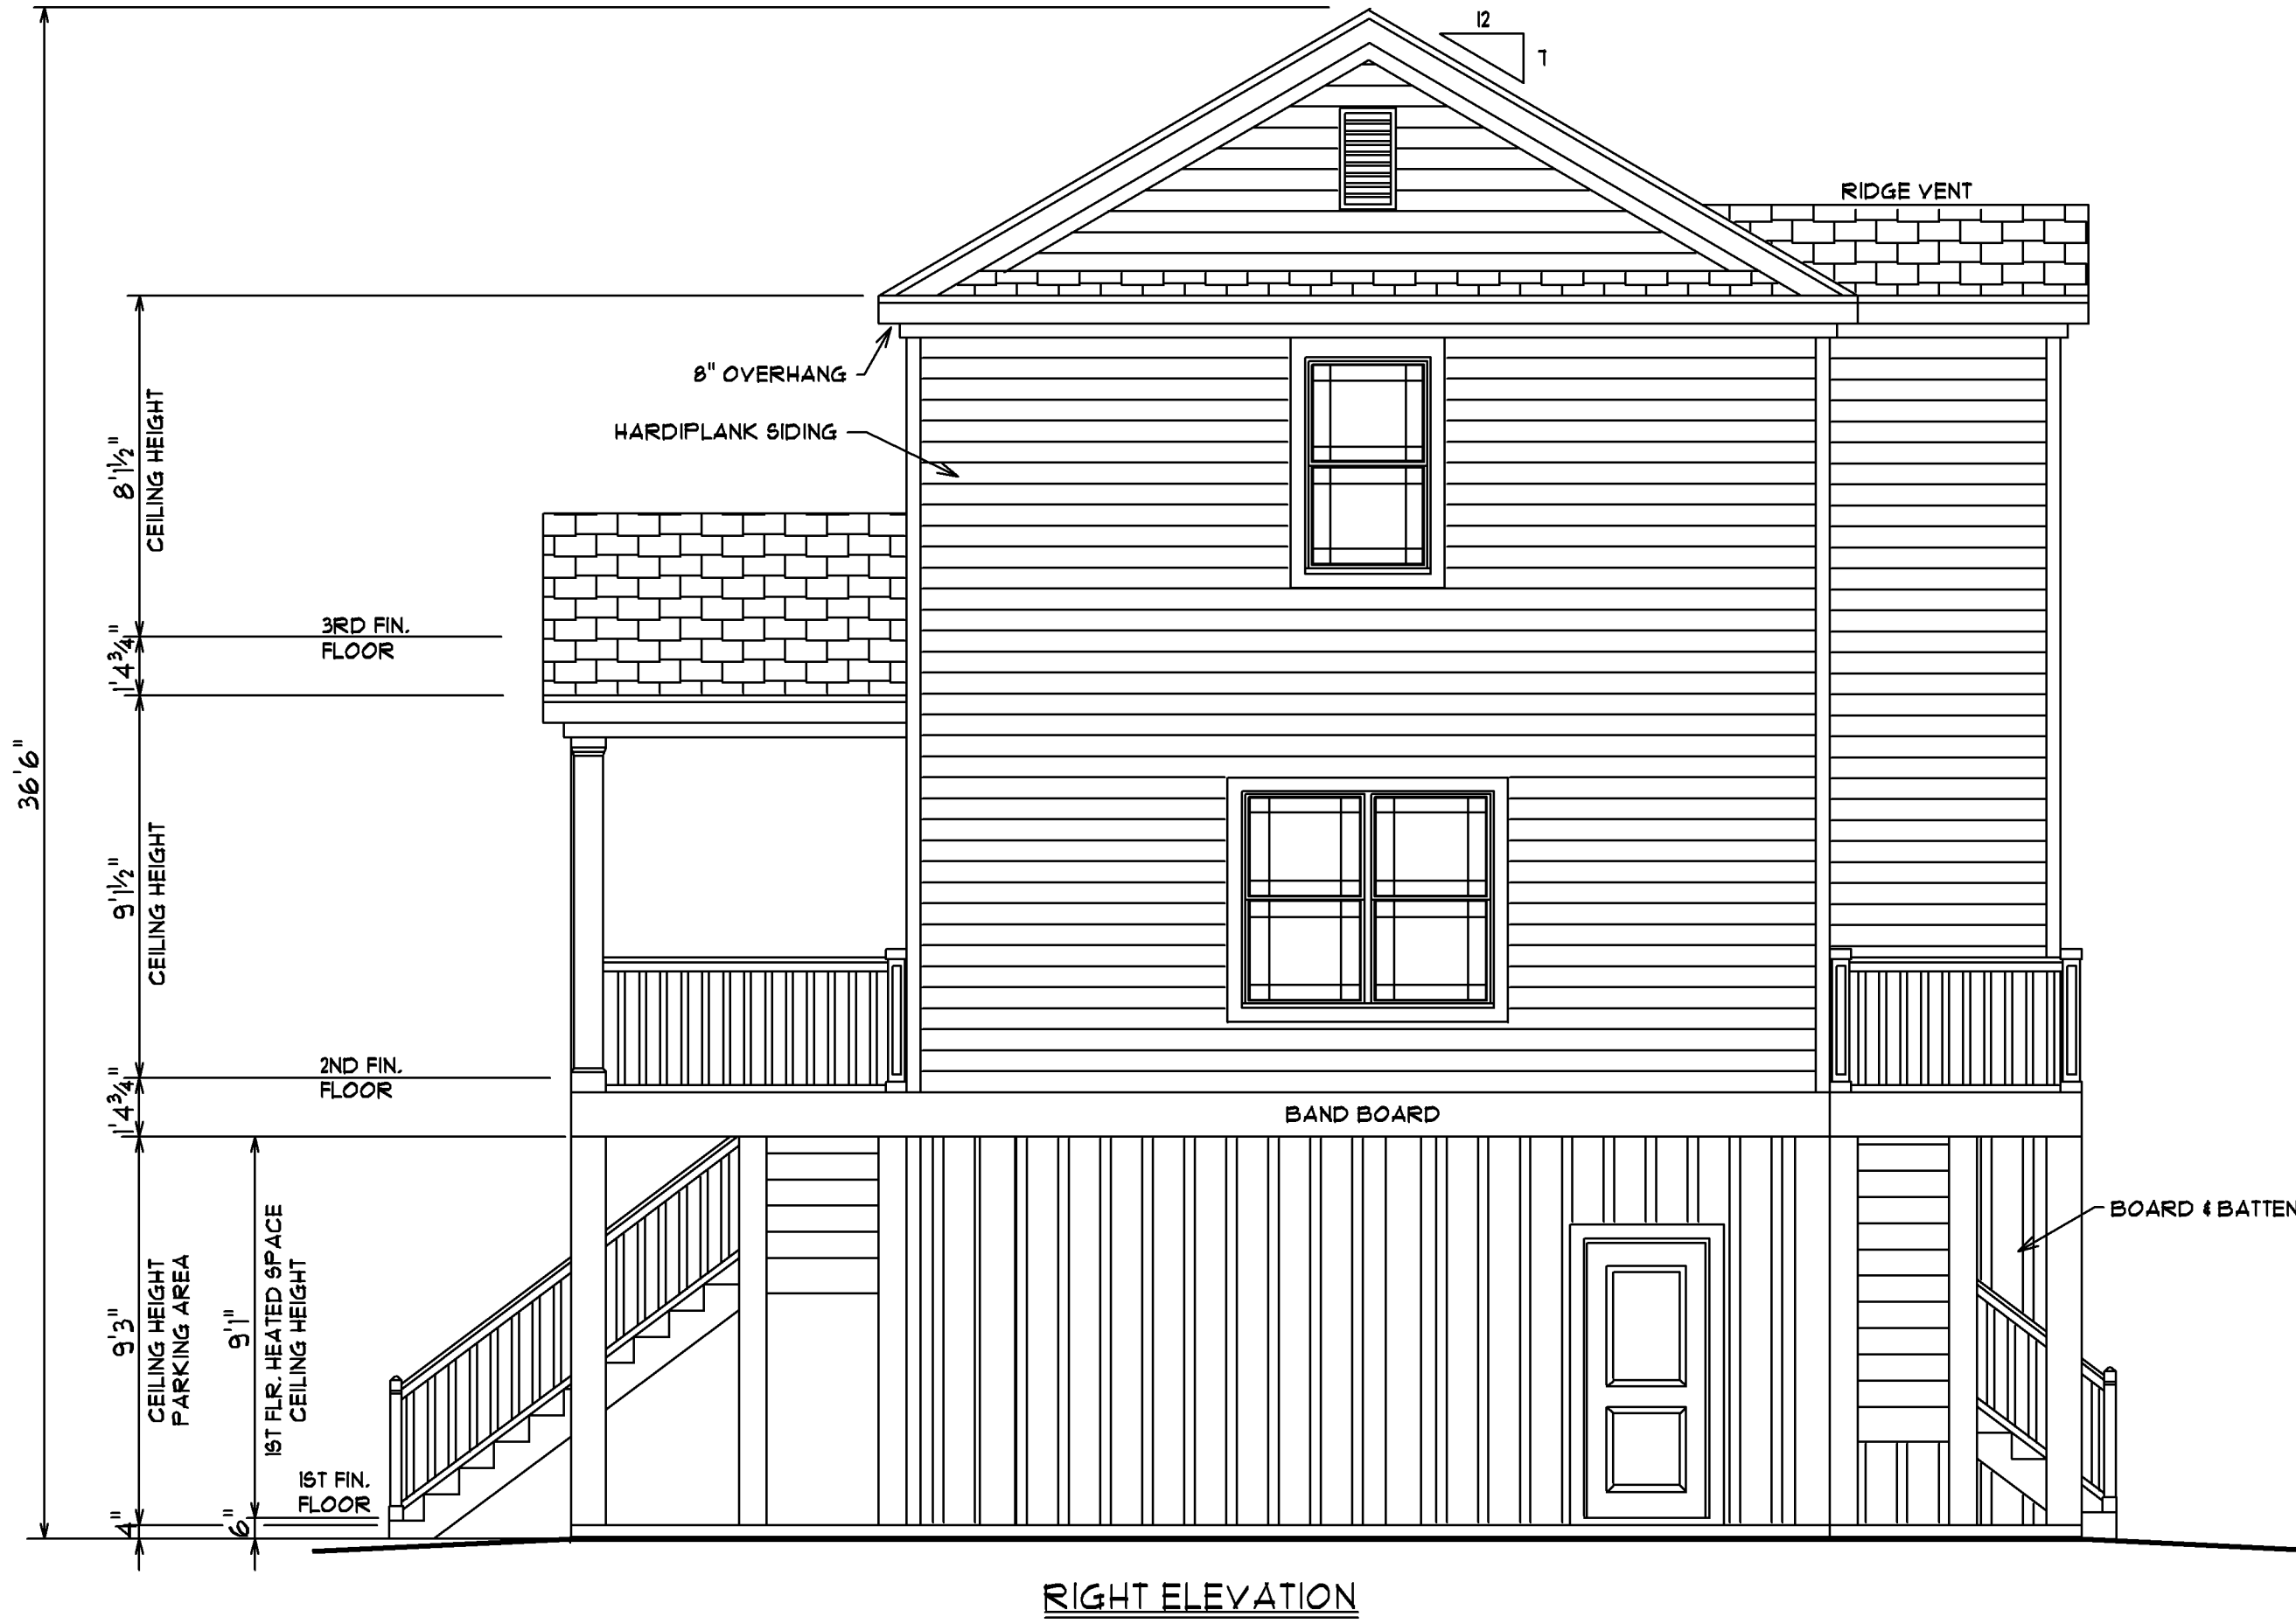

RIGHT ELEVATION



LEFT ELEVATION

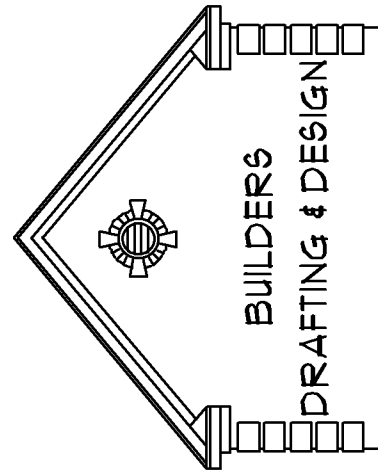

PAULA BURGIN
1341 CROOKED OAK DRIVE
PAULLEY'S ISLAND, SC 29585
C18431 979 - 5500
C18431 283 - 3113
BURGINPAULA@aol.com

SCALE: 1/4" = 1'0"

DATE 5/8/24



SHEET #2

ELEVATIONS

JOB LOCATION:
514 VISTA DRIVE
GARDEN CITY, SC

SQUARE FOOTAGE:	640
1ST FLOOR HEATED	154
2ND FLOOR HEATED	1106
3RD FLOOR HEATED	2300
TOTAL HEATED SPACE	104
PARKING	191
COVERED PATIOS	303
COVERED PORCHES	4104
TOTAL UNDER ROOF	12
DECK	

EXPERT
PROPERTIES LLC

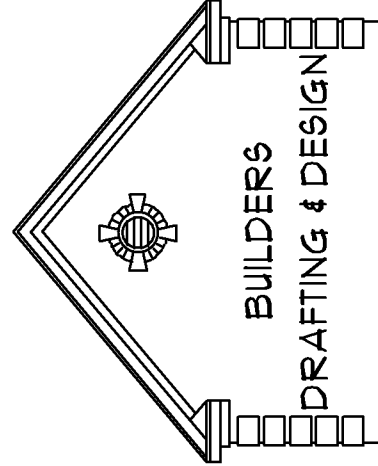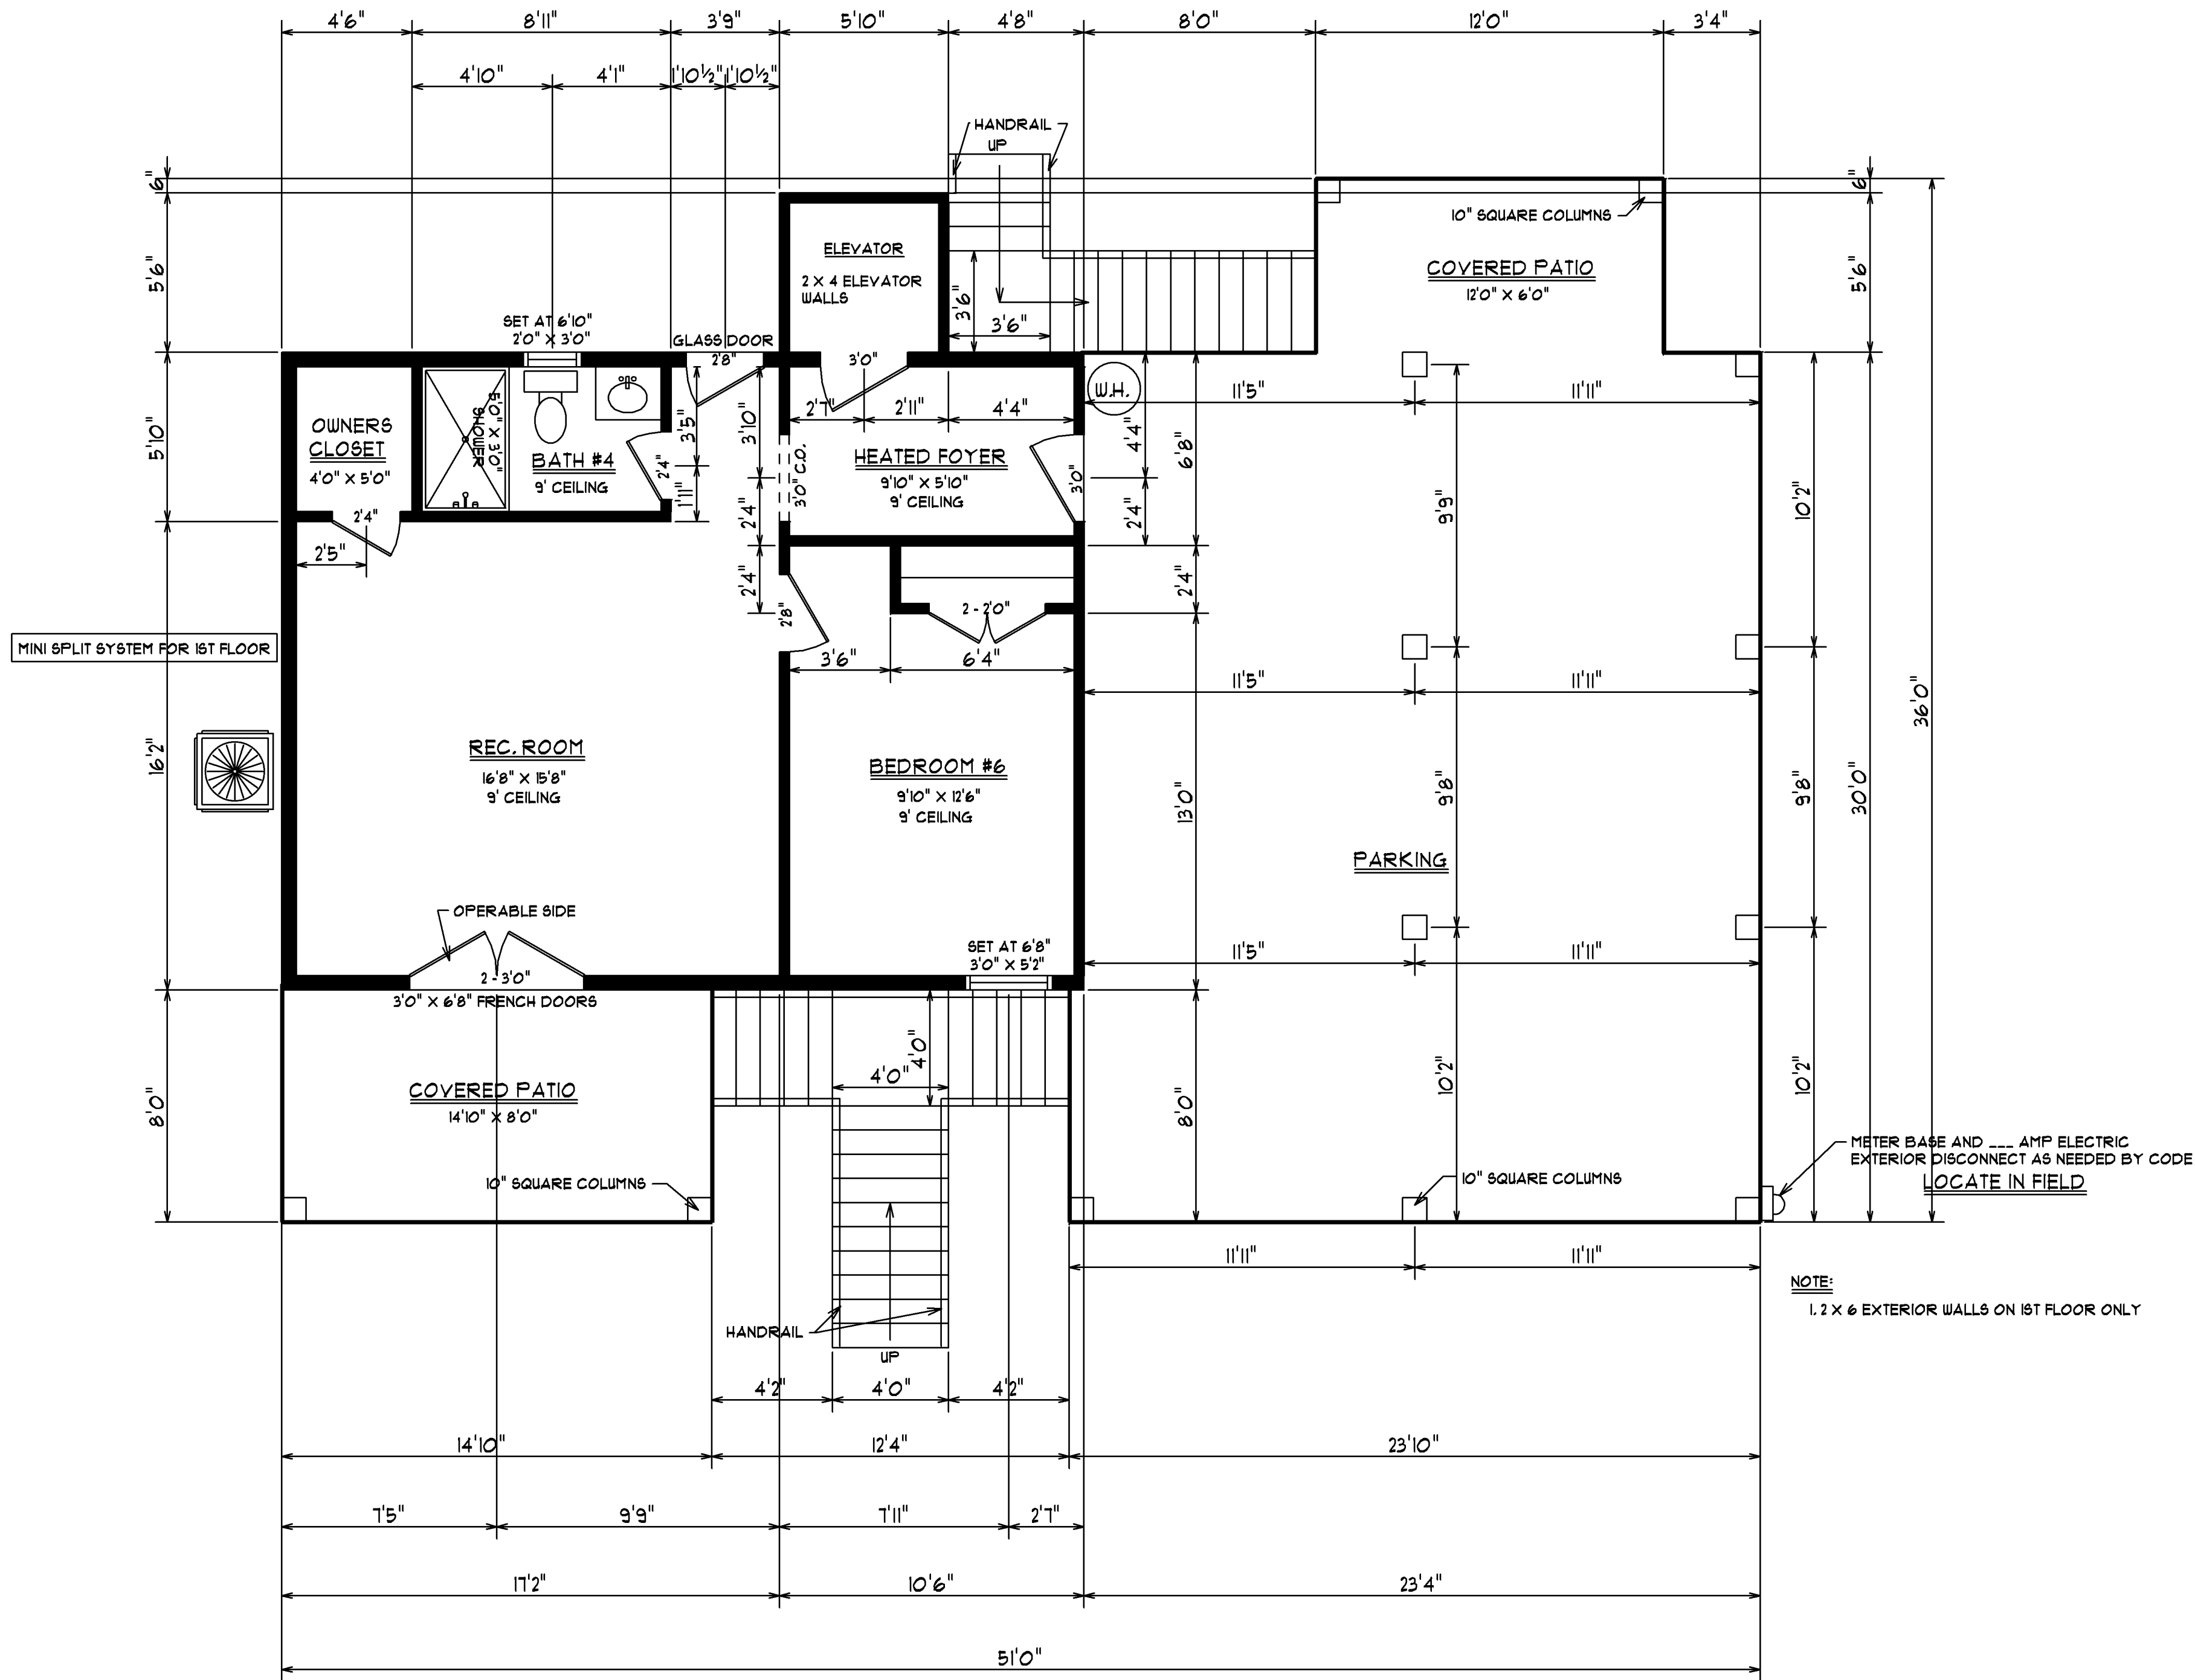

PAULA BURGIN
1341 CROOKED OAK DRIVE
PAULLEY ISLAND, SC 29585
C18431 978 - 5500
C18431 283 - 3713
BURGINPAULA@aol.com

SCALE: 1/4" = 1'0"

DATE 5/8/24



SHEET #3

FIRST FLOOR PLAN

JOB LOCATION:
514 VISTA DRIVE
GARDEN CITY, SC

SQUARE FOOTAGE:	640
1ST FLOOR HEATED	1154
2ND FLOOR HEATED	1106
3RD FLOOR HEATED	2300
TOTAL HEATED SF	4560
PARKING	104
COVERED PATIOS	191
COVERED PORCHES	303
TOTAL UNDER ROOF	4104
DECK	12

EXPERT PROPERTIES LLC

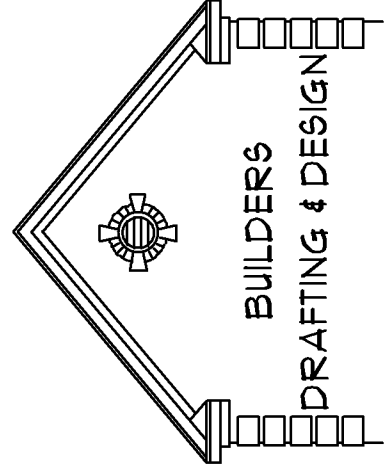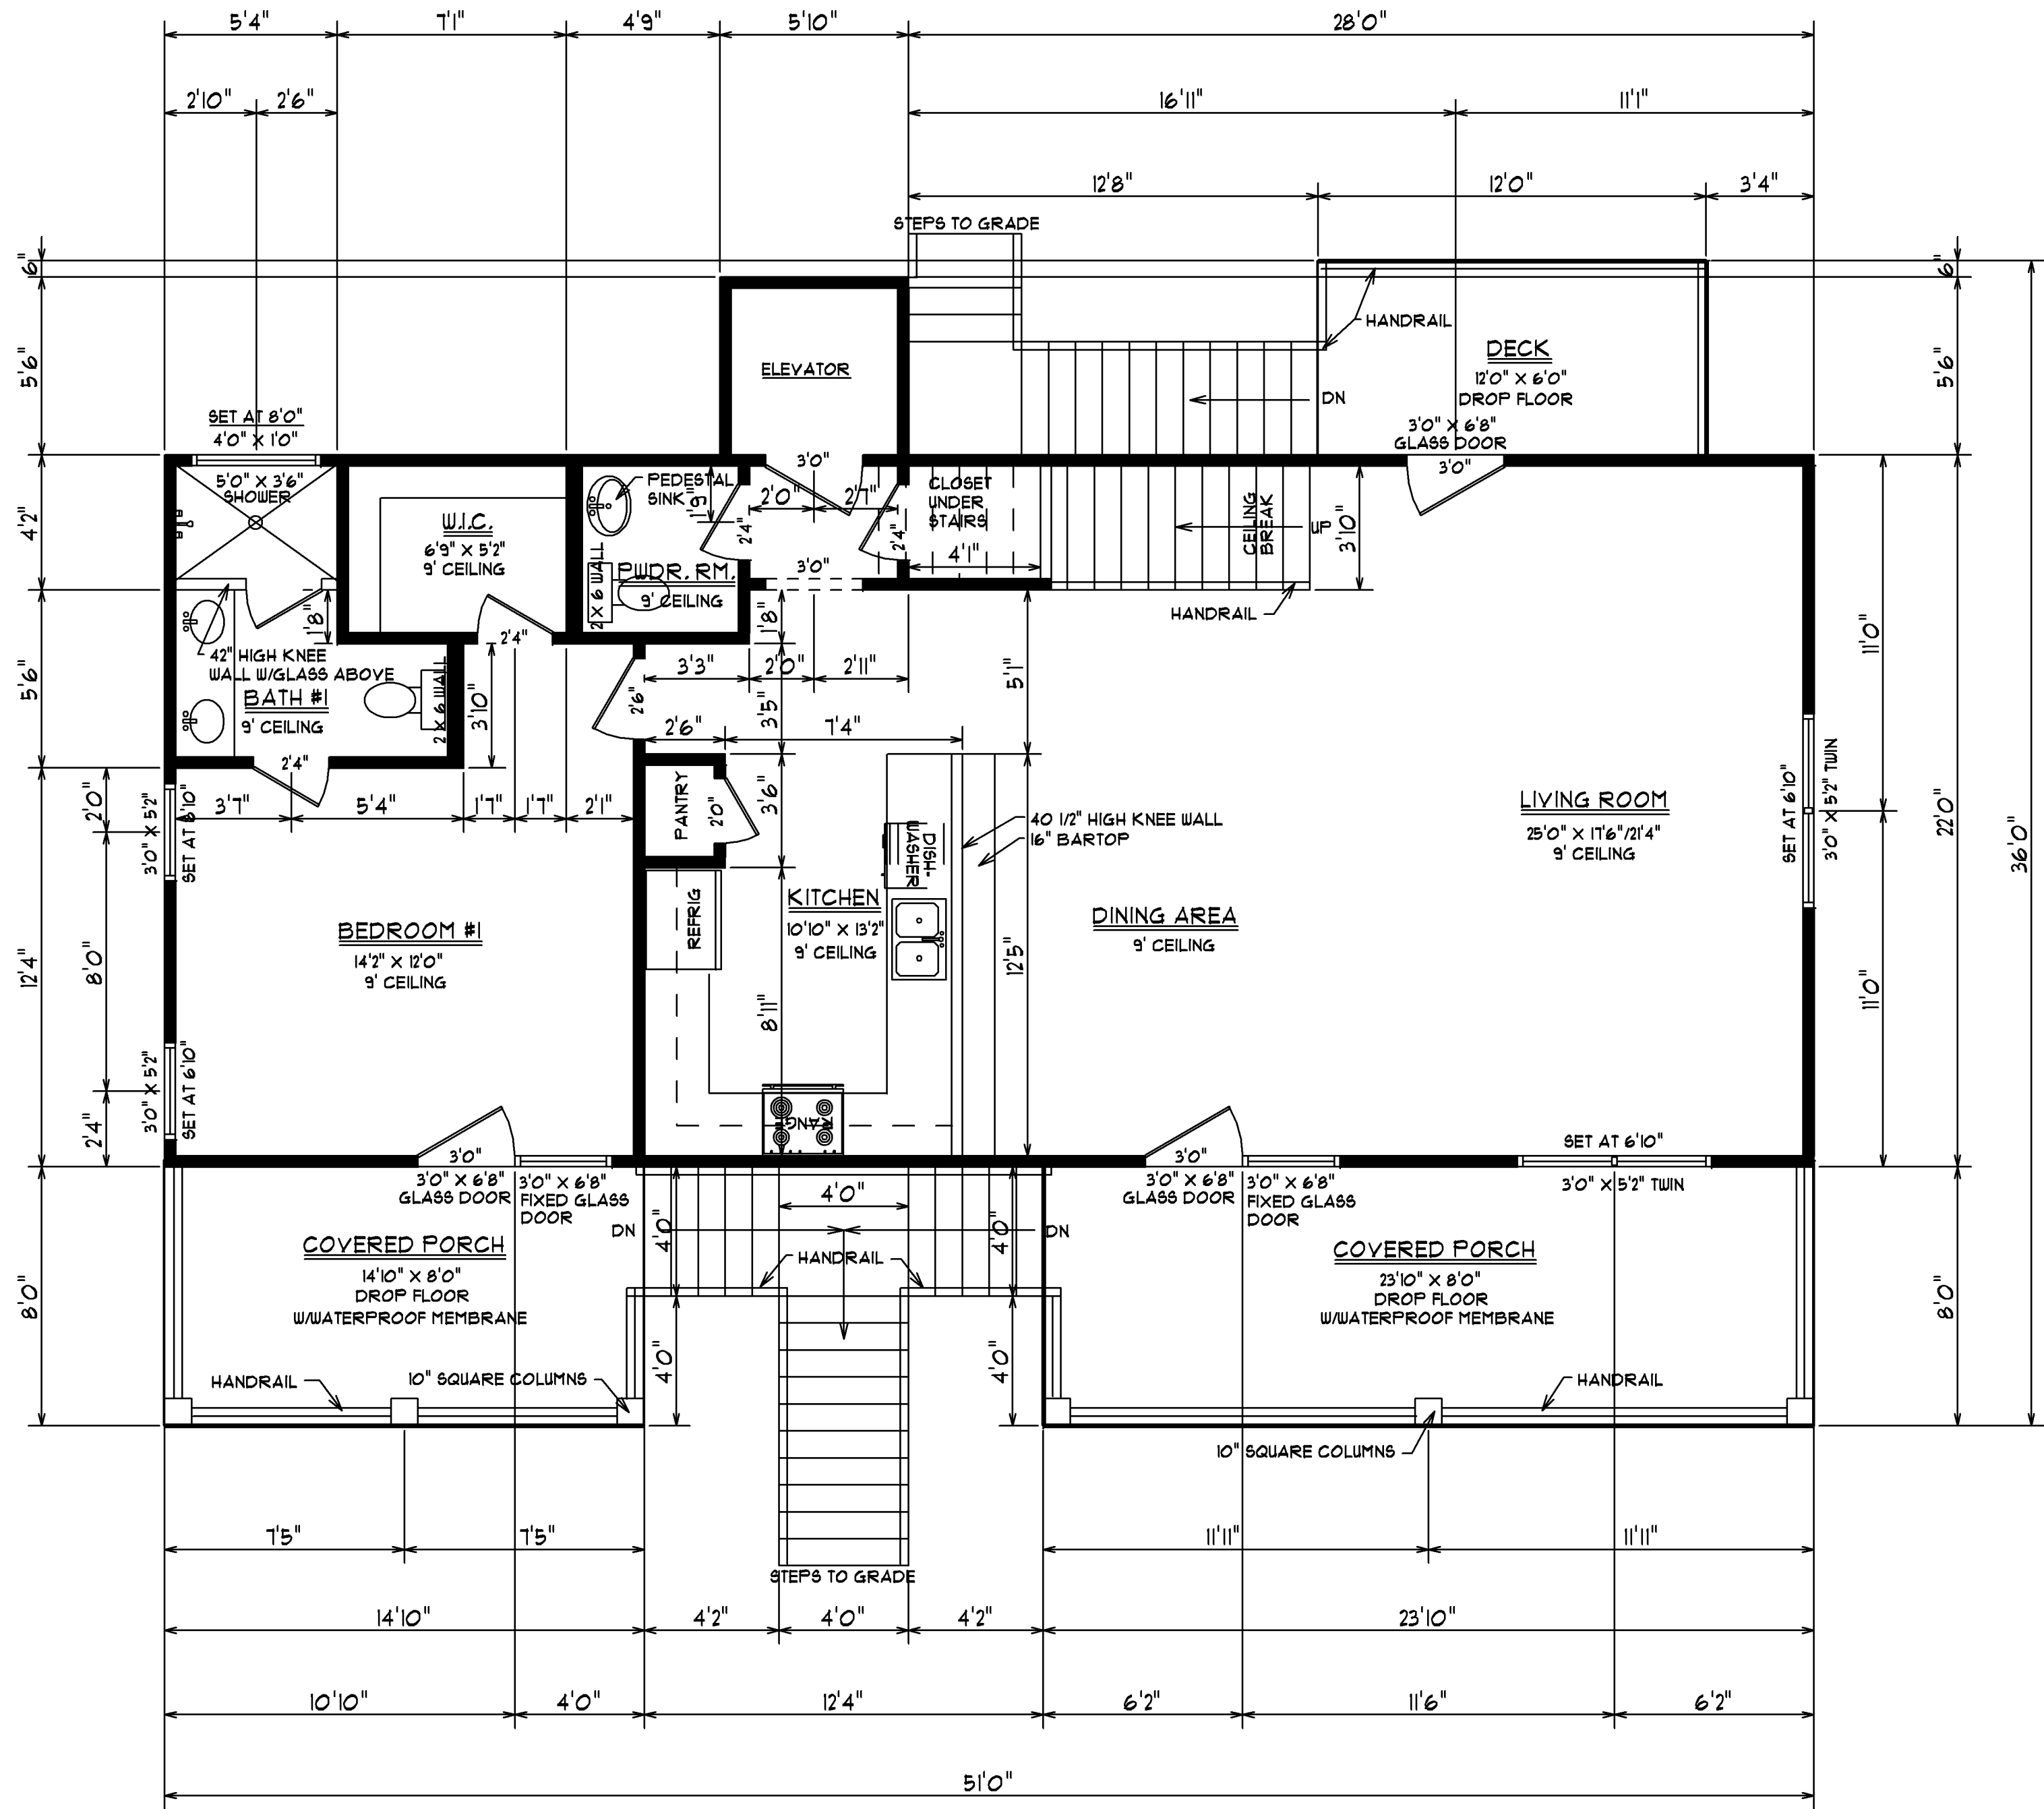

PAULA BURGIN
1341 CROOKED OAK DRIVE
PAULLEY ISLAND, SC 29585
C18431 878 - 5500
C18431 283 - 3113
BURGINPAULA@aol.com

SCALE: 1/4" = 1'0"

DATE 5/8/24


SHEET #4

SECOND FLOOR PLAN



JOB LOCATION:
514 VISTA DRIVE
GARDEN CITY, SC

SQUARE FOOTAGE:	640
1ST FLOOR HEATED	1154
2ND FLOOR HEATED	1106
3RD FLOOR HEATED	2300
TOTAL HEATED SPACE	104
PARKING	191
COVERED PATIOS	303
COVERED PORCHES	4104
TOTAL UNDER ROOF	12
DECK	

EXPERT
PROPERTIES LLC

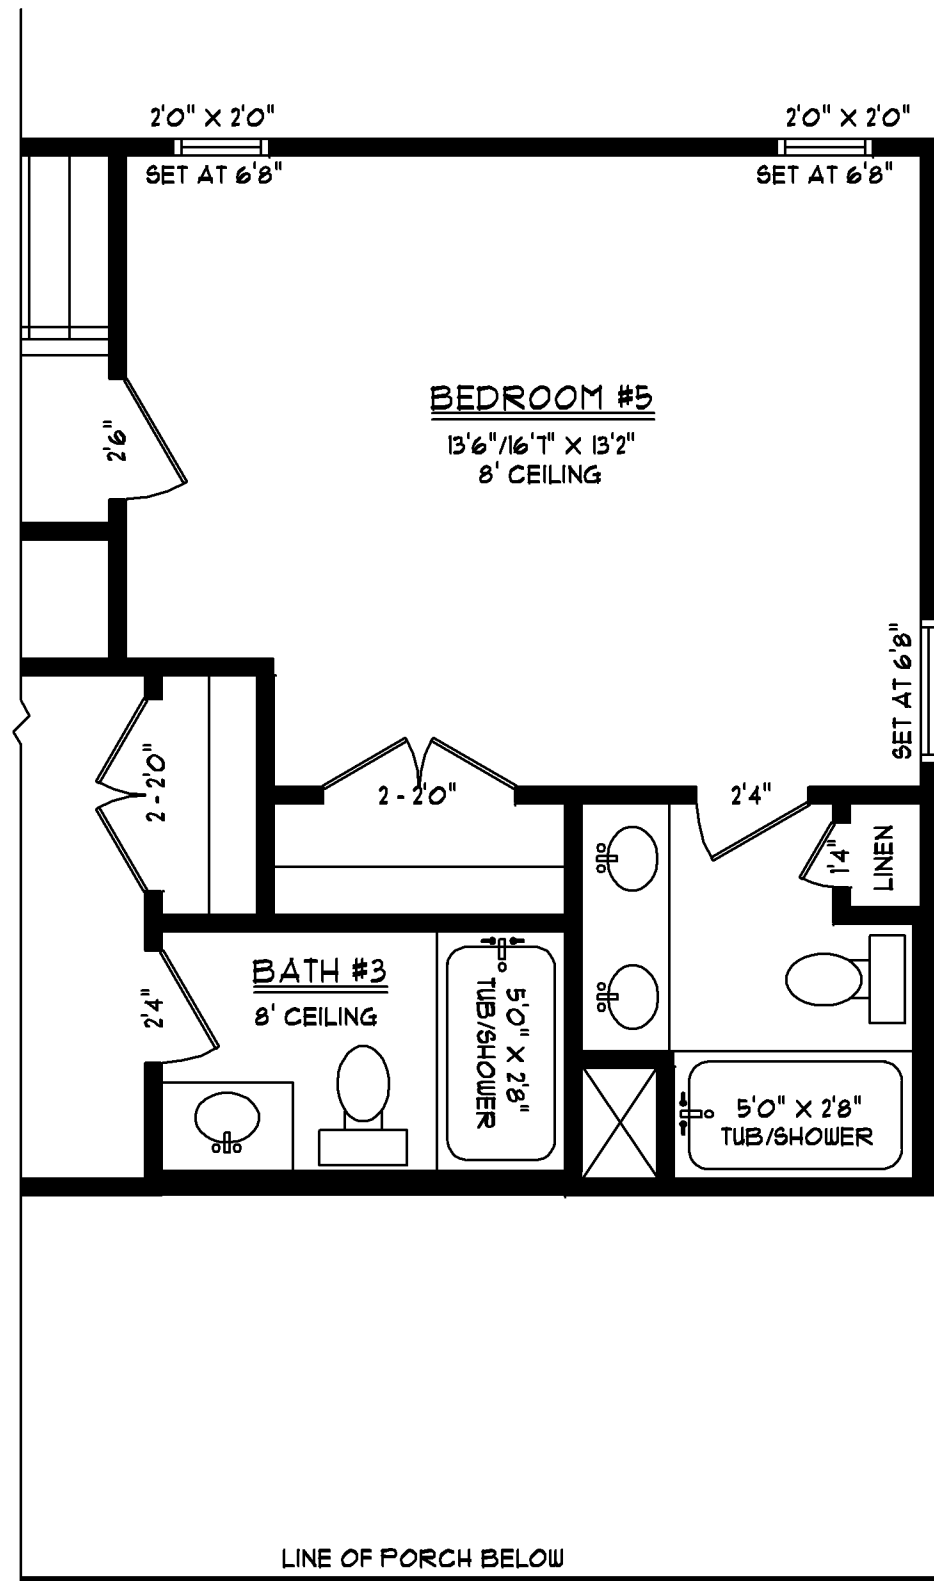

OPTION BATH PLAN

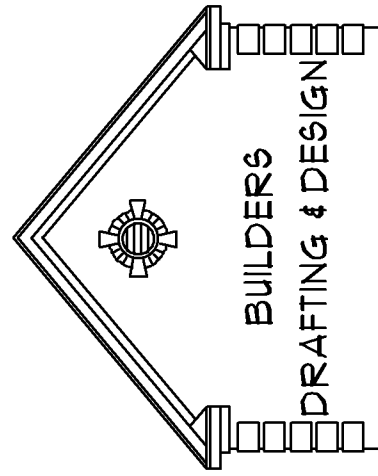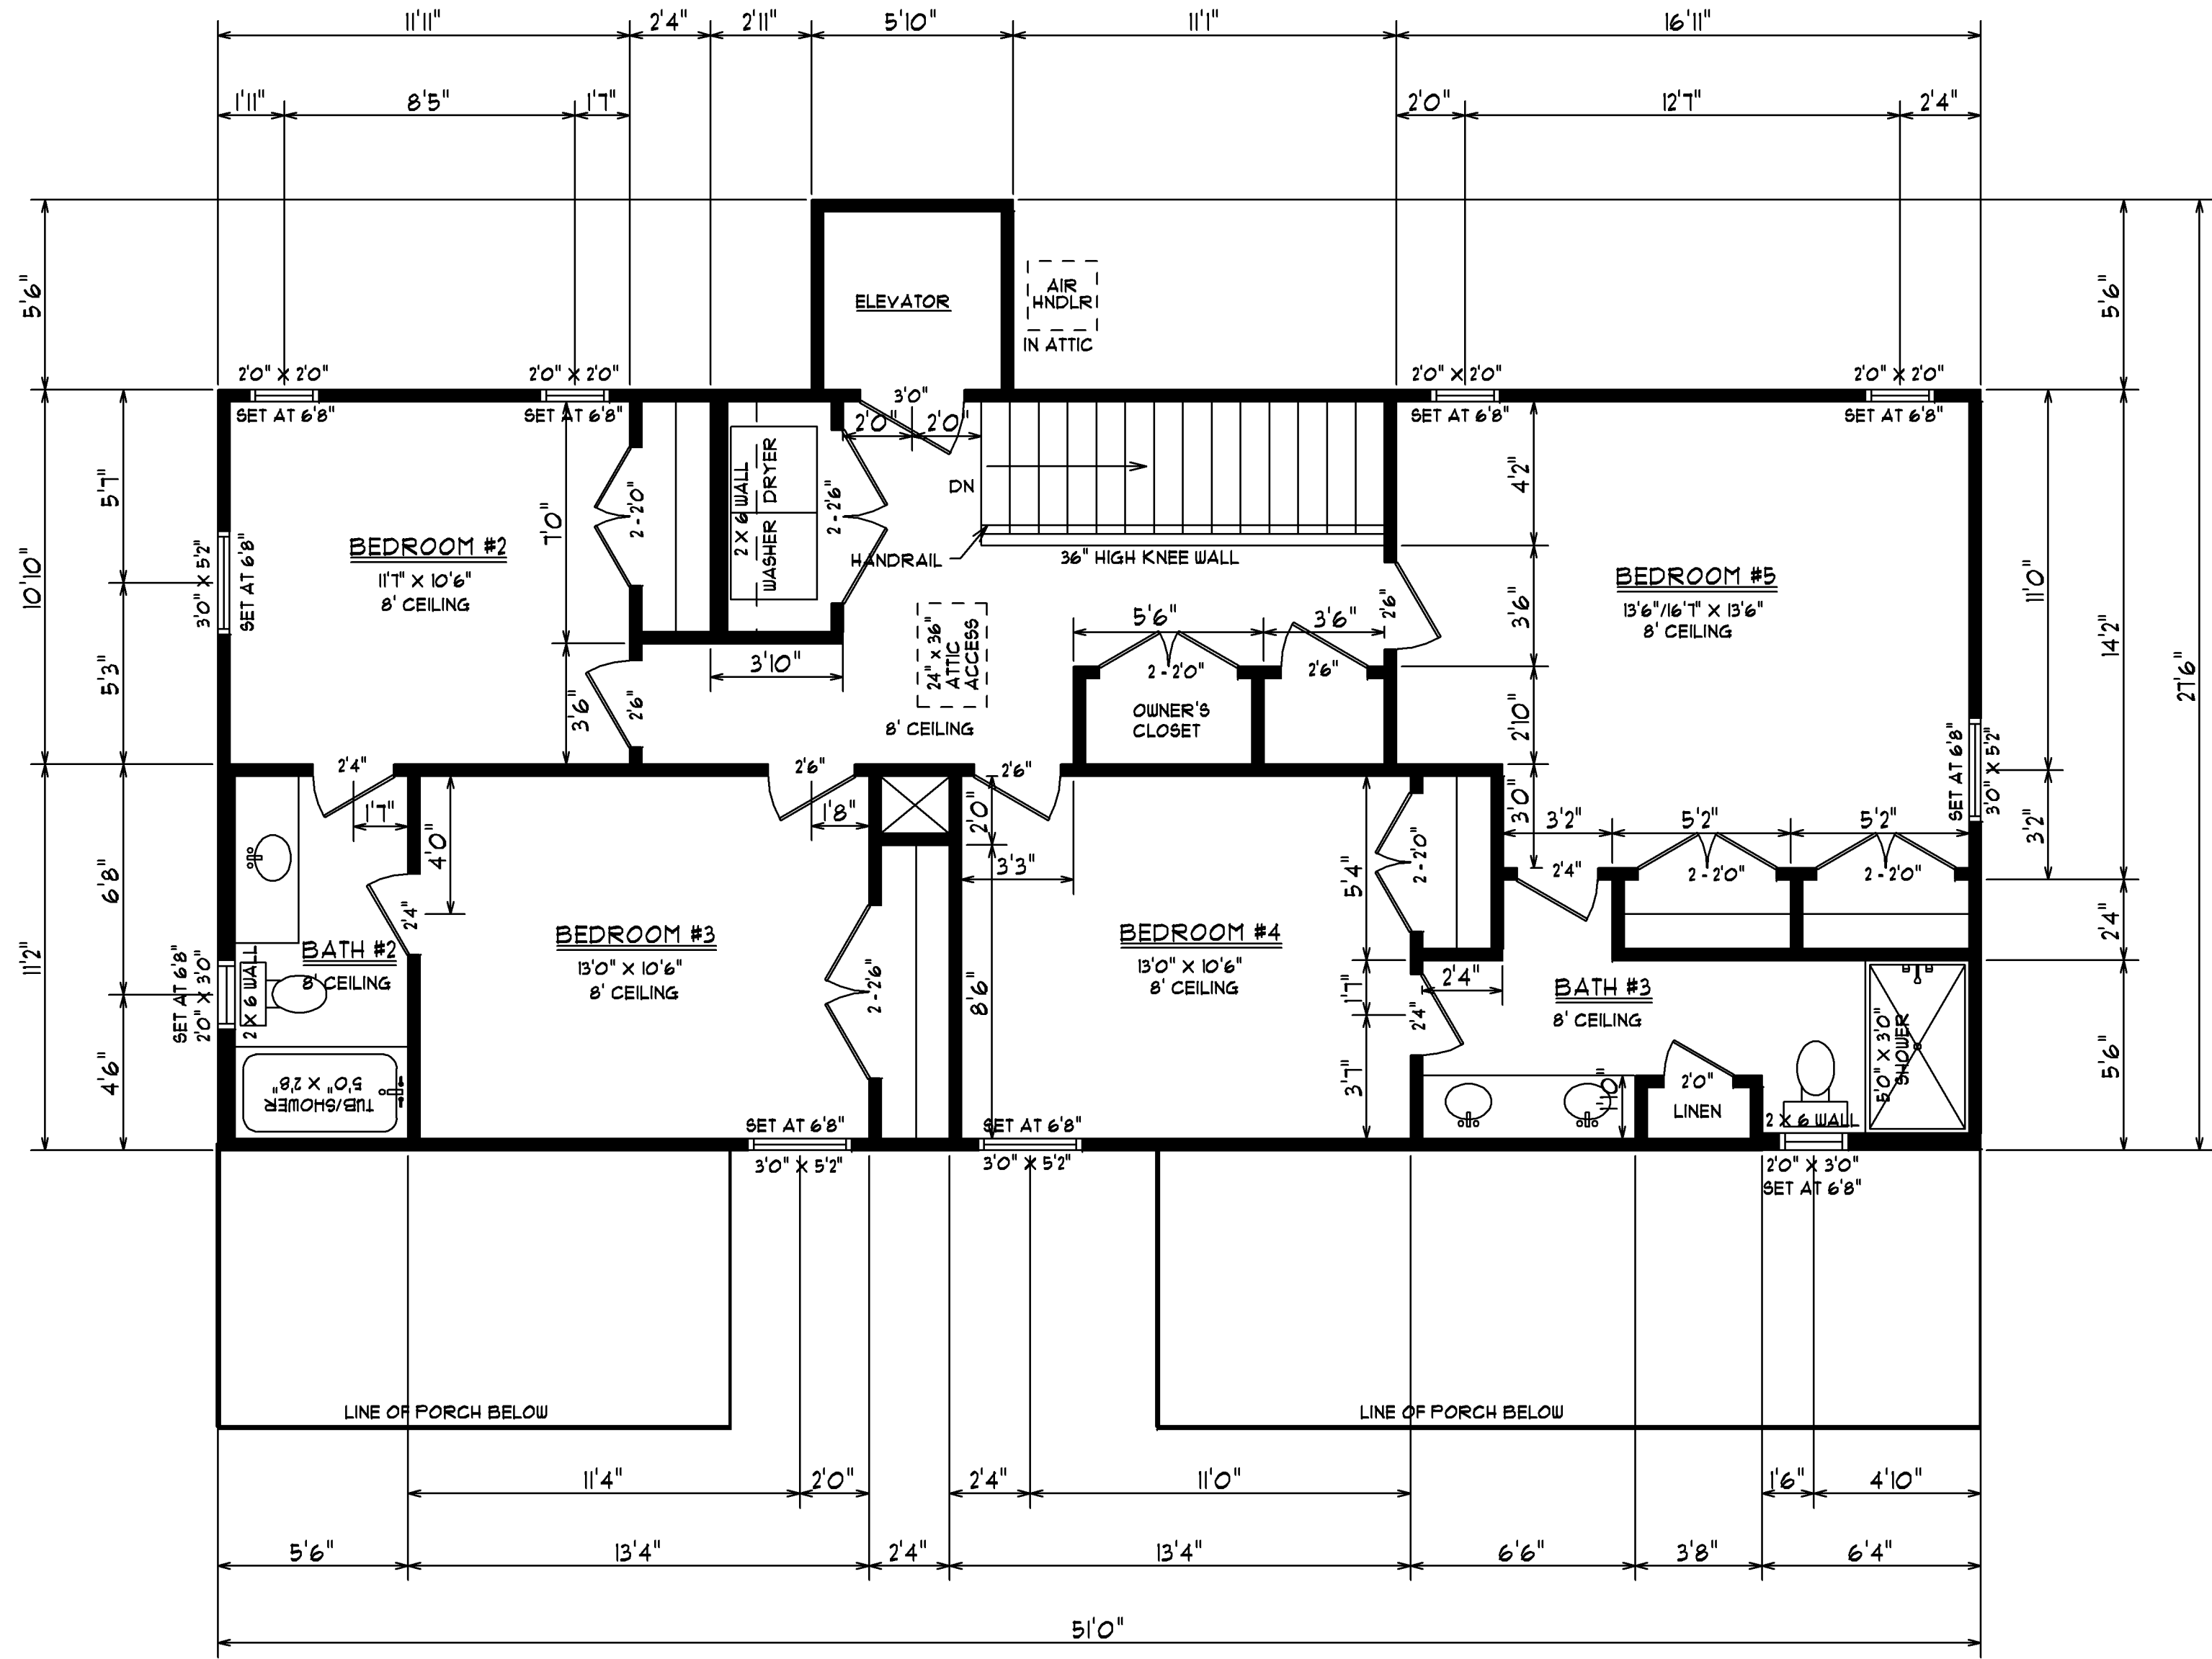

SCALE: 1/4" = 1'0"

DATE 5/8/24


SHEET #5
THIRD
FLOOR PLAN

JOB LOCATION:
514 VISTA DRIVE
GARDEN CITY, SC

SQUARE FOOTAGE:	640
1ST FLOOR HEATED	1154
2ND FLOOR HEATED	1106
3RD FLOOR HEATED	2300
TOTAL HEATED SF SPACE	104
PARKING	191
COVERED PATIOS	303
COVERED PORCHES	4104
TOTAL UNDER ROOF	12
DECK	

EXPERT
PROPERTIES LLC

ELECTRICAL LEGEND	
SYMBOL	DESCRIPTION
	LIGHT
	RECESSED CAN LIGHT
	SWITCH
	3-WAY SWITCH
	220 OUTLET
	110 OUTLET
	GROUND FAULT INTERRUPTER
	TELEVISION
	TELEPHONE
	BATH FAN/LIGHT
	BATH FAN ONLY
	GARBAGE DISPOSAL
	SPEAKER
	DOORBELL BUTTON
	SMOKE DETECTOR
	DOUBLE FLOOD LIGHT
	HOSE BIB
	PREWIRED FAN/LIGHT

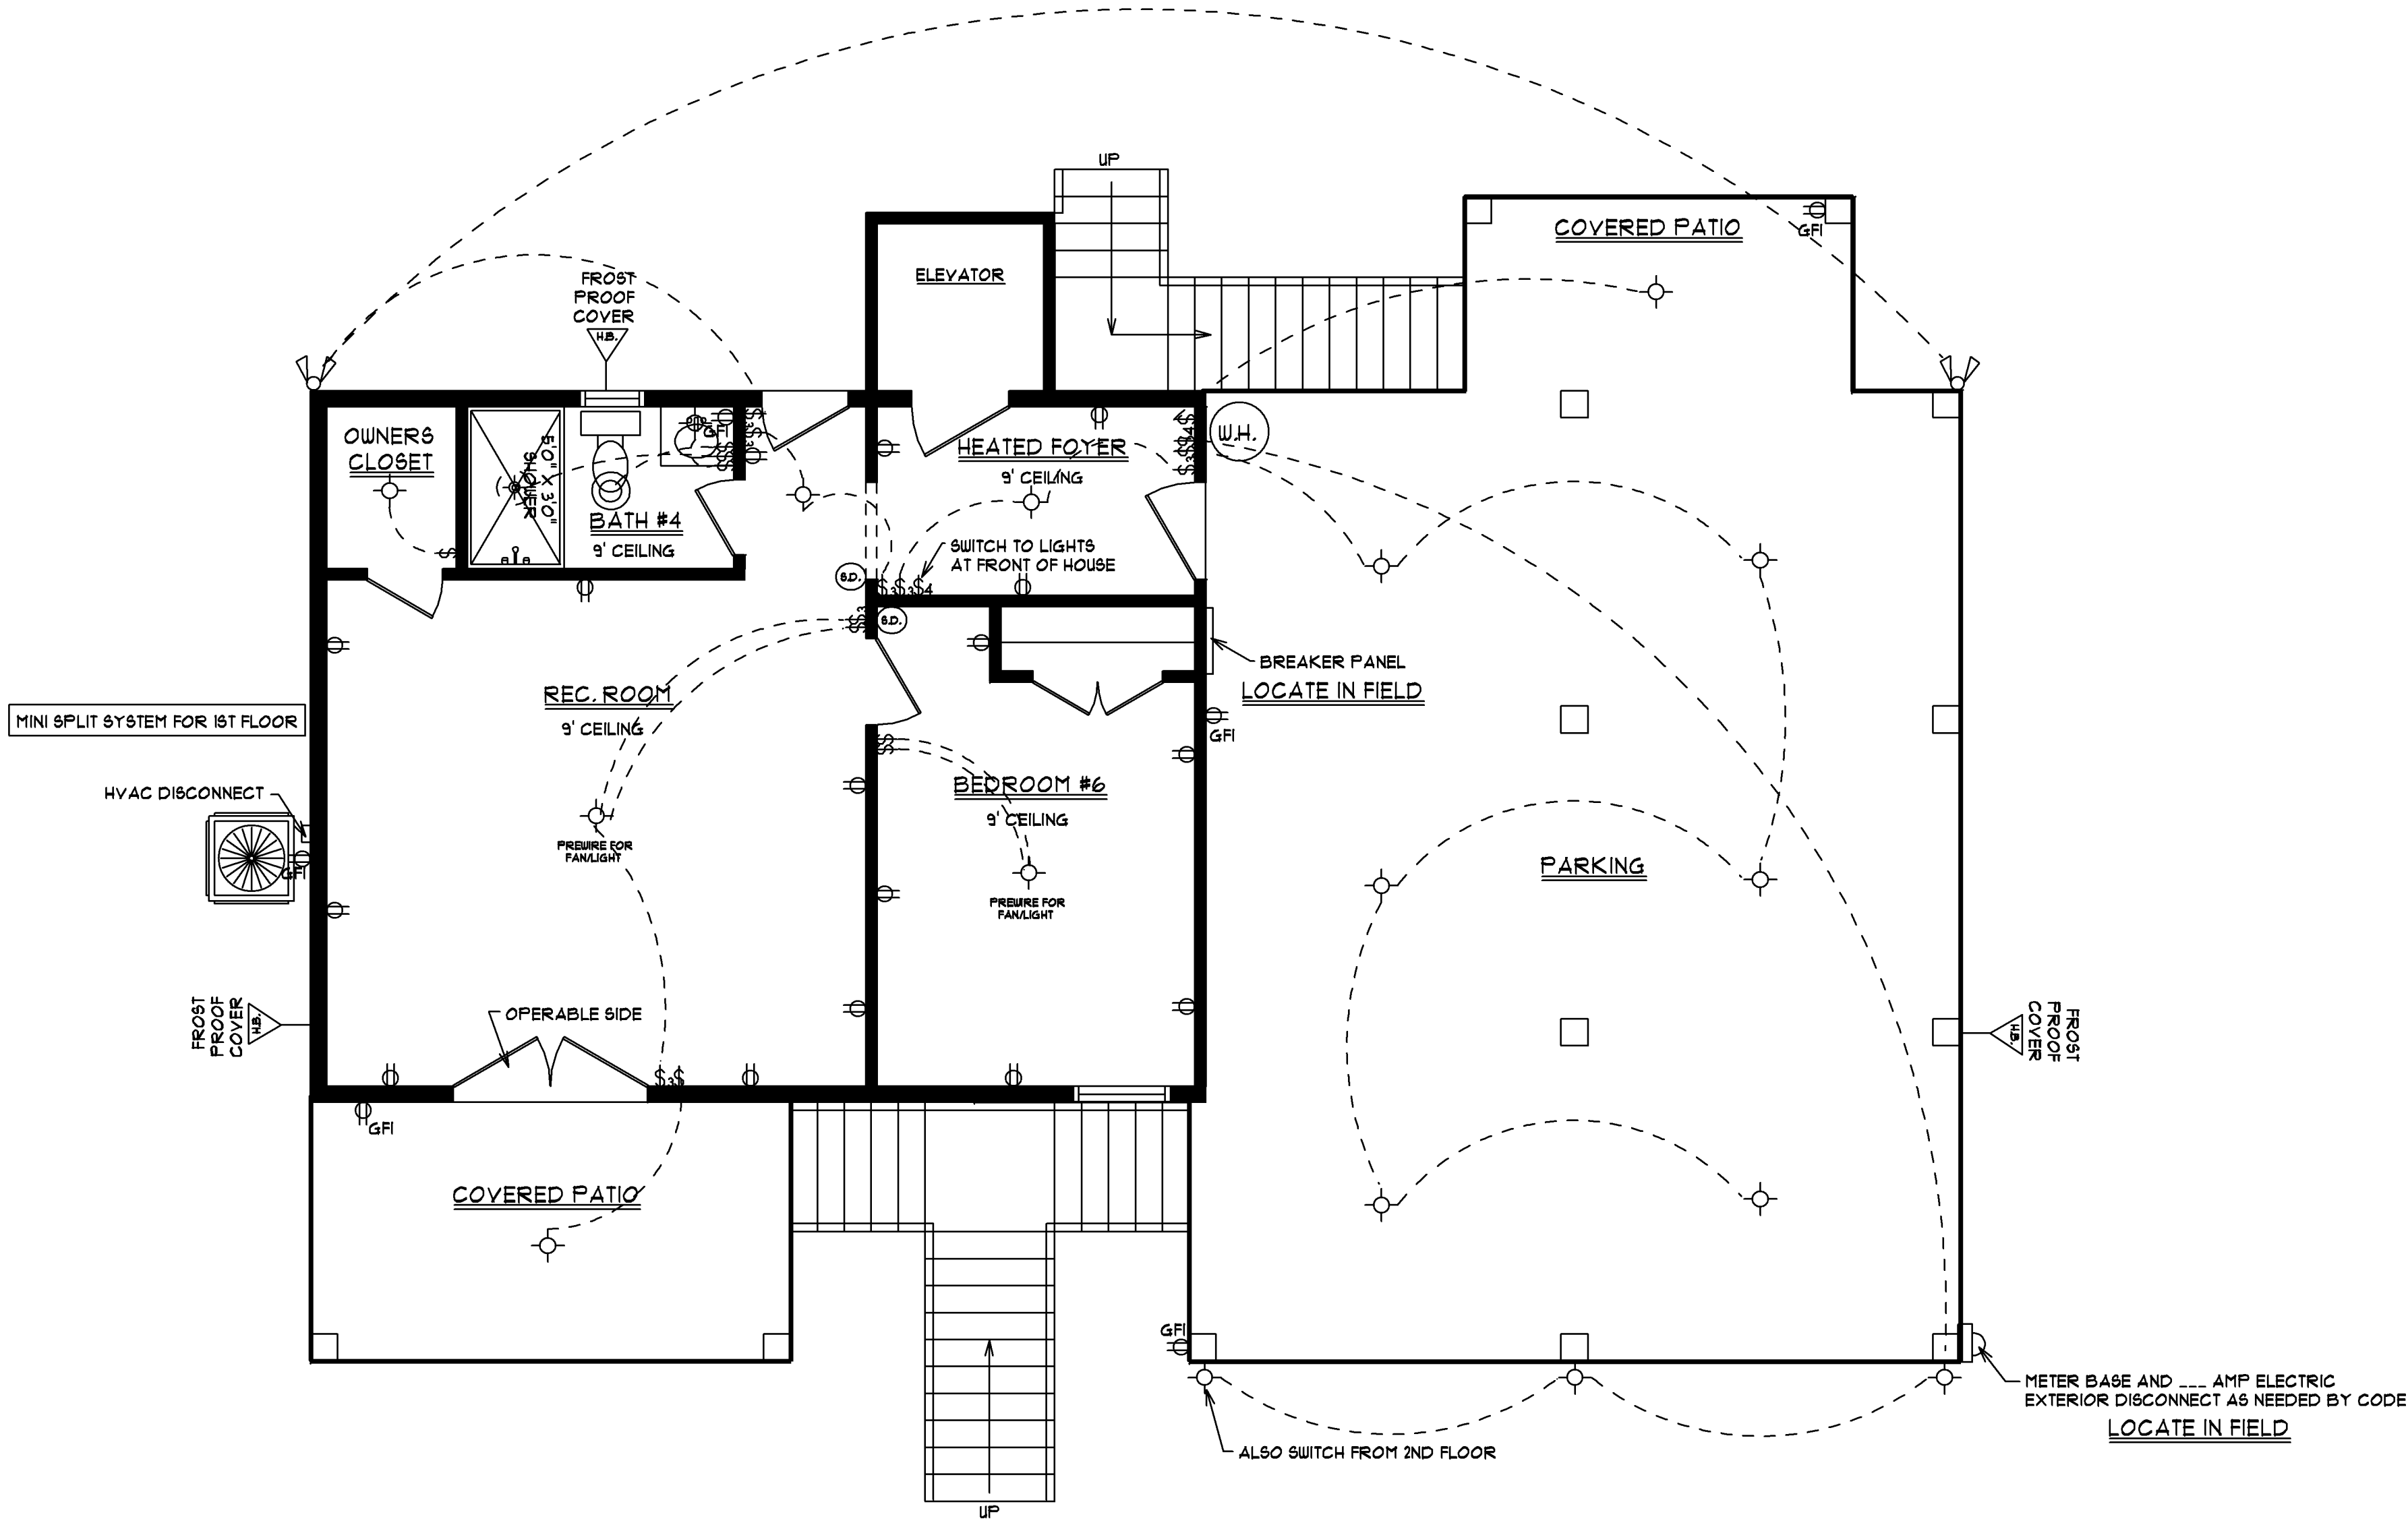

PAULA BURGIN
1341 CROOKED OAK DRIVE
PAULLEY'S ISLAND, SC 29585
C18431 978 - 5500
C18431 283 - 3713
BURGINPAULA@AOL.COM

BUILDERS
DRAFTING & DESIGN

SCALE: 1/4" = 1'0"

DATE 5/8/24



SHEET #6
1ST FLOOR
ELECTRICAL

JOB LOCATION:
514 VISTA DRIVE
GARDEN CITY, SC

SQUARE FOOTAGE:	640
	1154
	1106
	2300
	104
1ST FLOOR HEATED	181
2ND FLOOR HEATED	309
3RD FLOOR HEATED	4104
TOTAL HEATED SPACE	
PARKING	
COVERED PATIOS	
COVERED PORCHES	
TOTAL UNDER ROOF	
DECK	72

EXPERT
PROPERTIES LLC

ELECTRICAL LEGEND	
SYMBOL	DESCRIPTION
	LIGHT
	RECESSED CAN LIGHT
	SWITCH
	3-WAY SWITCH
	220 OUTLET
	110 OUTLET
	GROUND FAULT INTERRUPTER
	TELEVISION
	TELEPHONE
	BATH FAN/LIGHT
	BATH FAN ONLY
	GARBAGE DISPOSAL
	SPEAKER
	DOORBELL BUTTON
	SMOKE DETECTOR
	DOUBLE FLOOD LIGHT
	HOSE BIB
	PREWIRED FAN/LIGHT

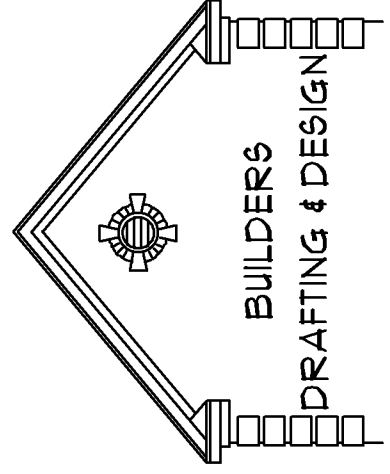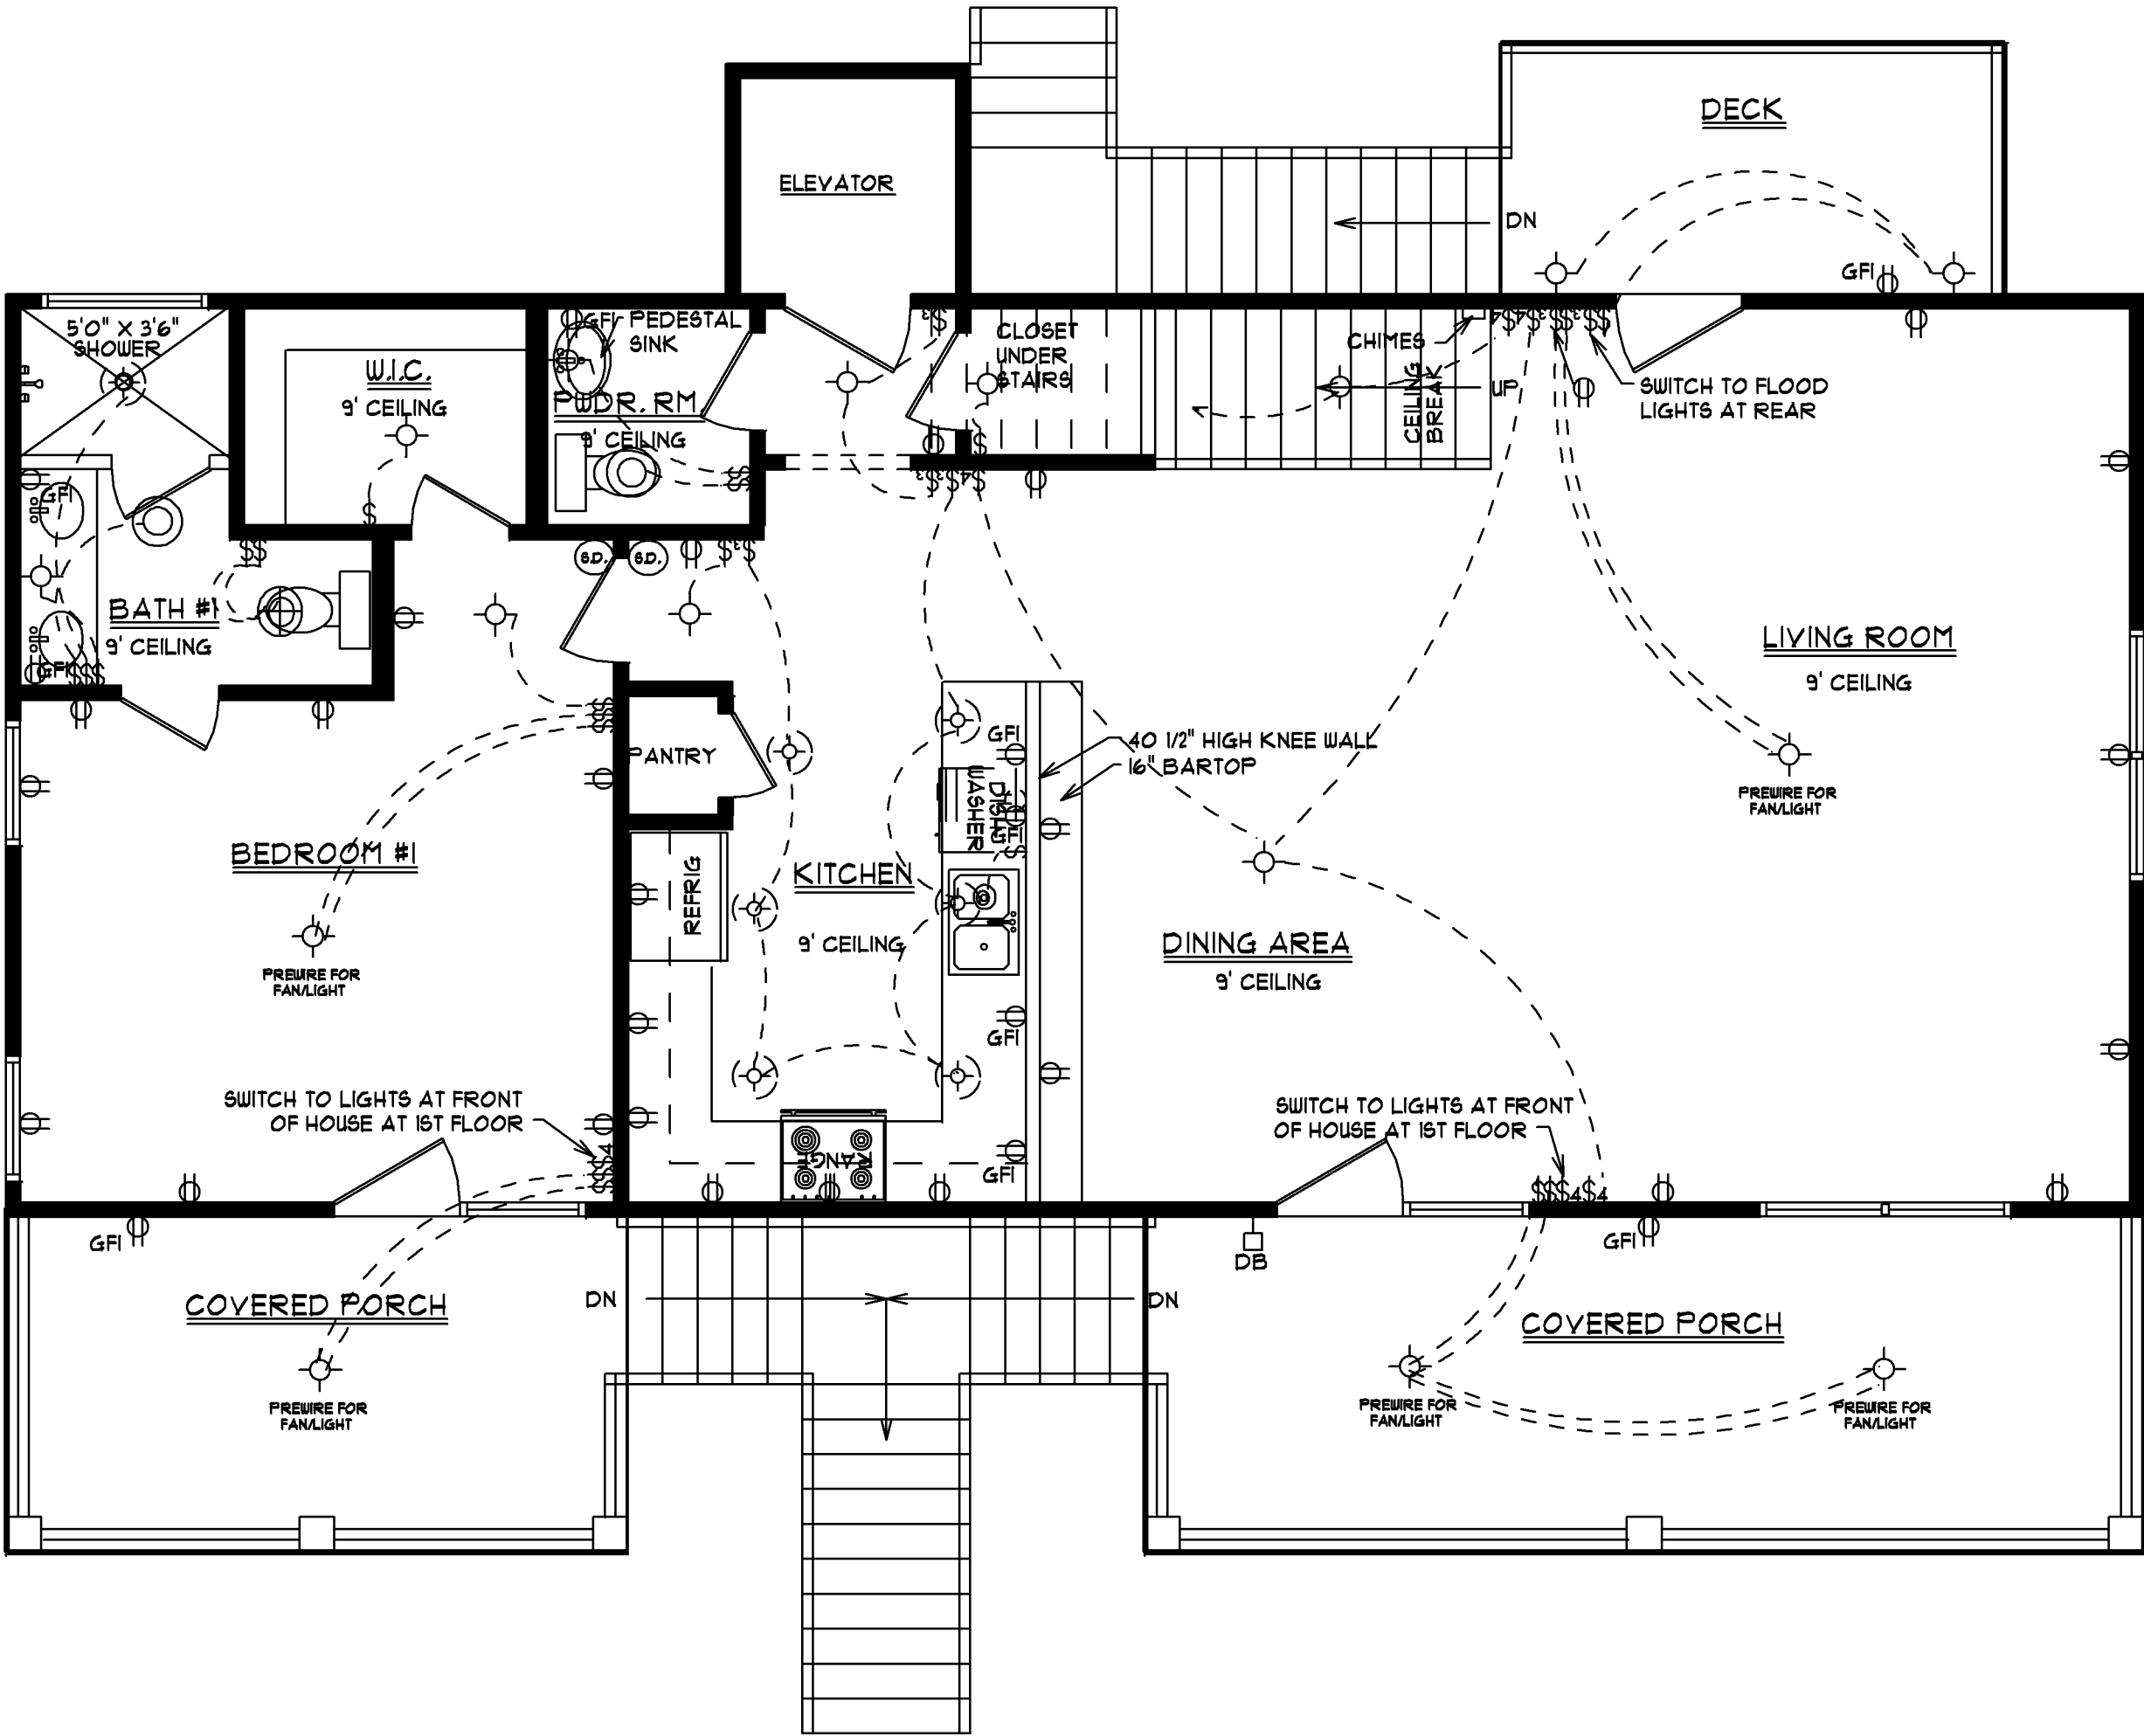

PAULA BURGIN
1341 CROOKED OAK DRIVE
PAULLEY ISLAND, SC 29585
C18431 978 - 5500
C18431 283 - 3713
BURGINPAULA@AOL.COM

SCALE: 1/4" = 1'0"

DATE 5/8/24



SHEET #1
2ND FLOOR
ELECTRICAL

JOB LOCATION:
514 VISTA DRIVE
GARDEN CITY, SC

SQUARE FOOTAGE:	640
	1154
	1106
	2500
	104
	181
TOTAL UNDER ROOF	303
	4104
DECK	72

EXPERT
PROPERTIES LLC

ELECTRICAL LEGEND	
SYMBOL	DESCRIPTION
	LIGHT
	RECESSED CAN LIGHT
	SWITCH
	3-WAY SWITCH
	220 OUTLET
	110 OUTLET
	GROUND FAULT INTERRUPTER
	TELEVISION
	TELEPHONE
	BATH FAN/LIGHT
	BATH FAN ONLY
	GARBAGE DISPOSAL
	SPEAKER
	DOORBELL BUTTON
	SMOKE DETECTOR
	DOUBLE FLOOD LIGHT
	HOSE BIB
	PREWIRED FAN/LIGHT

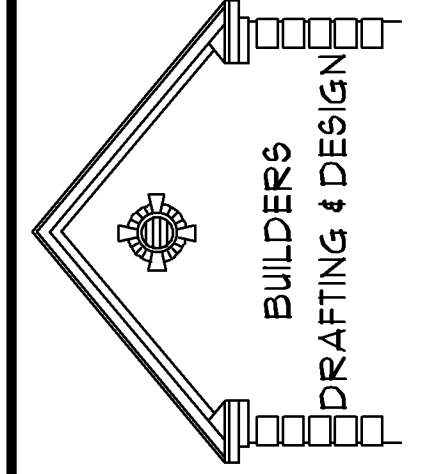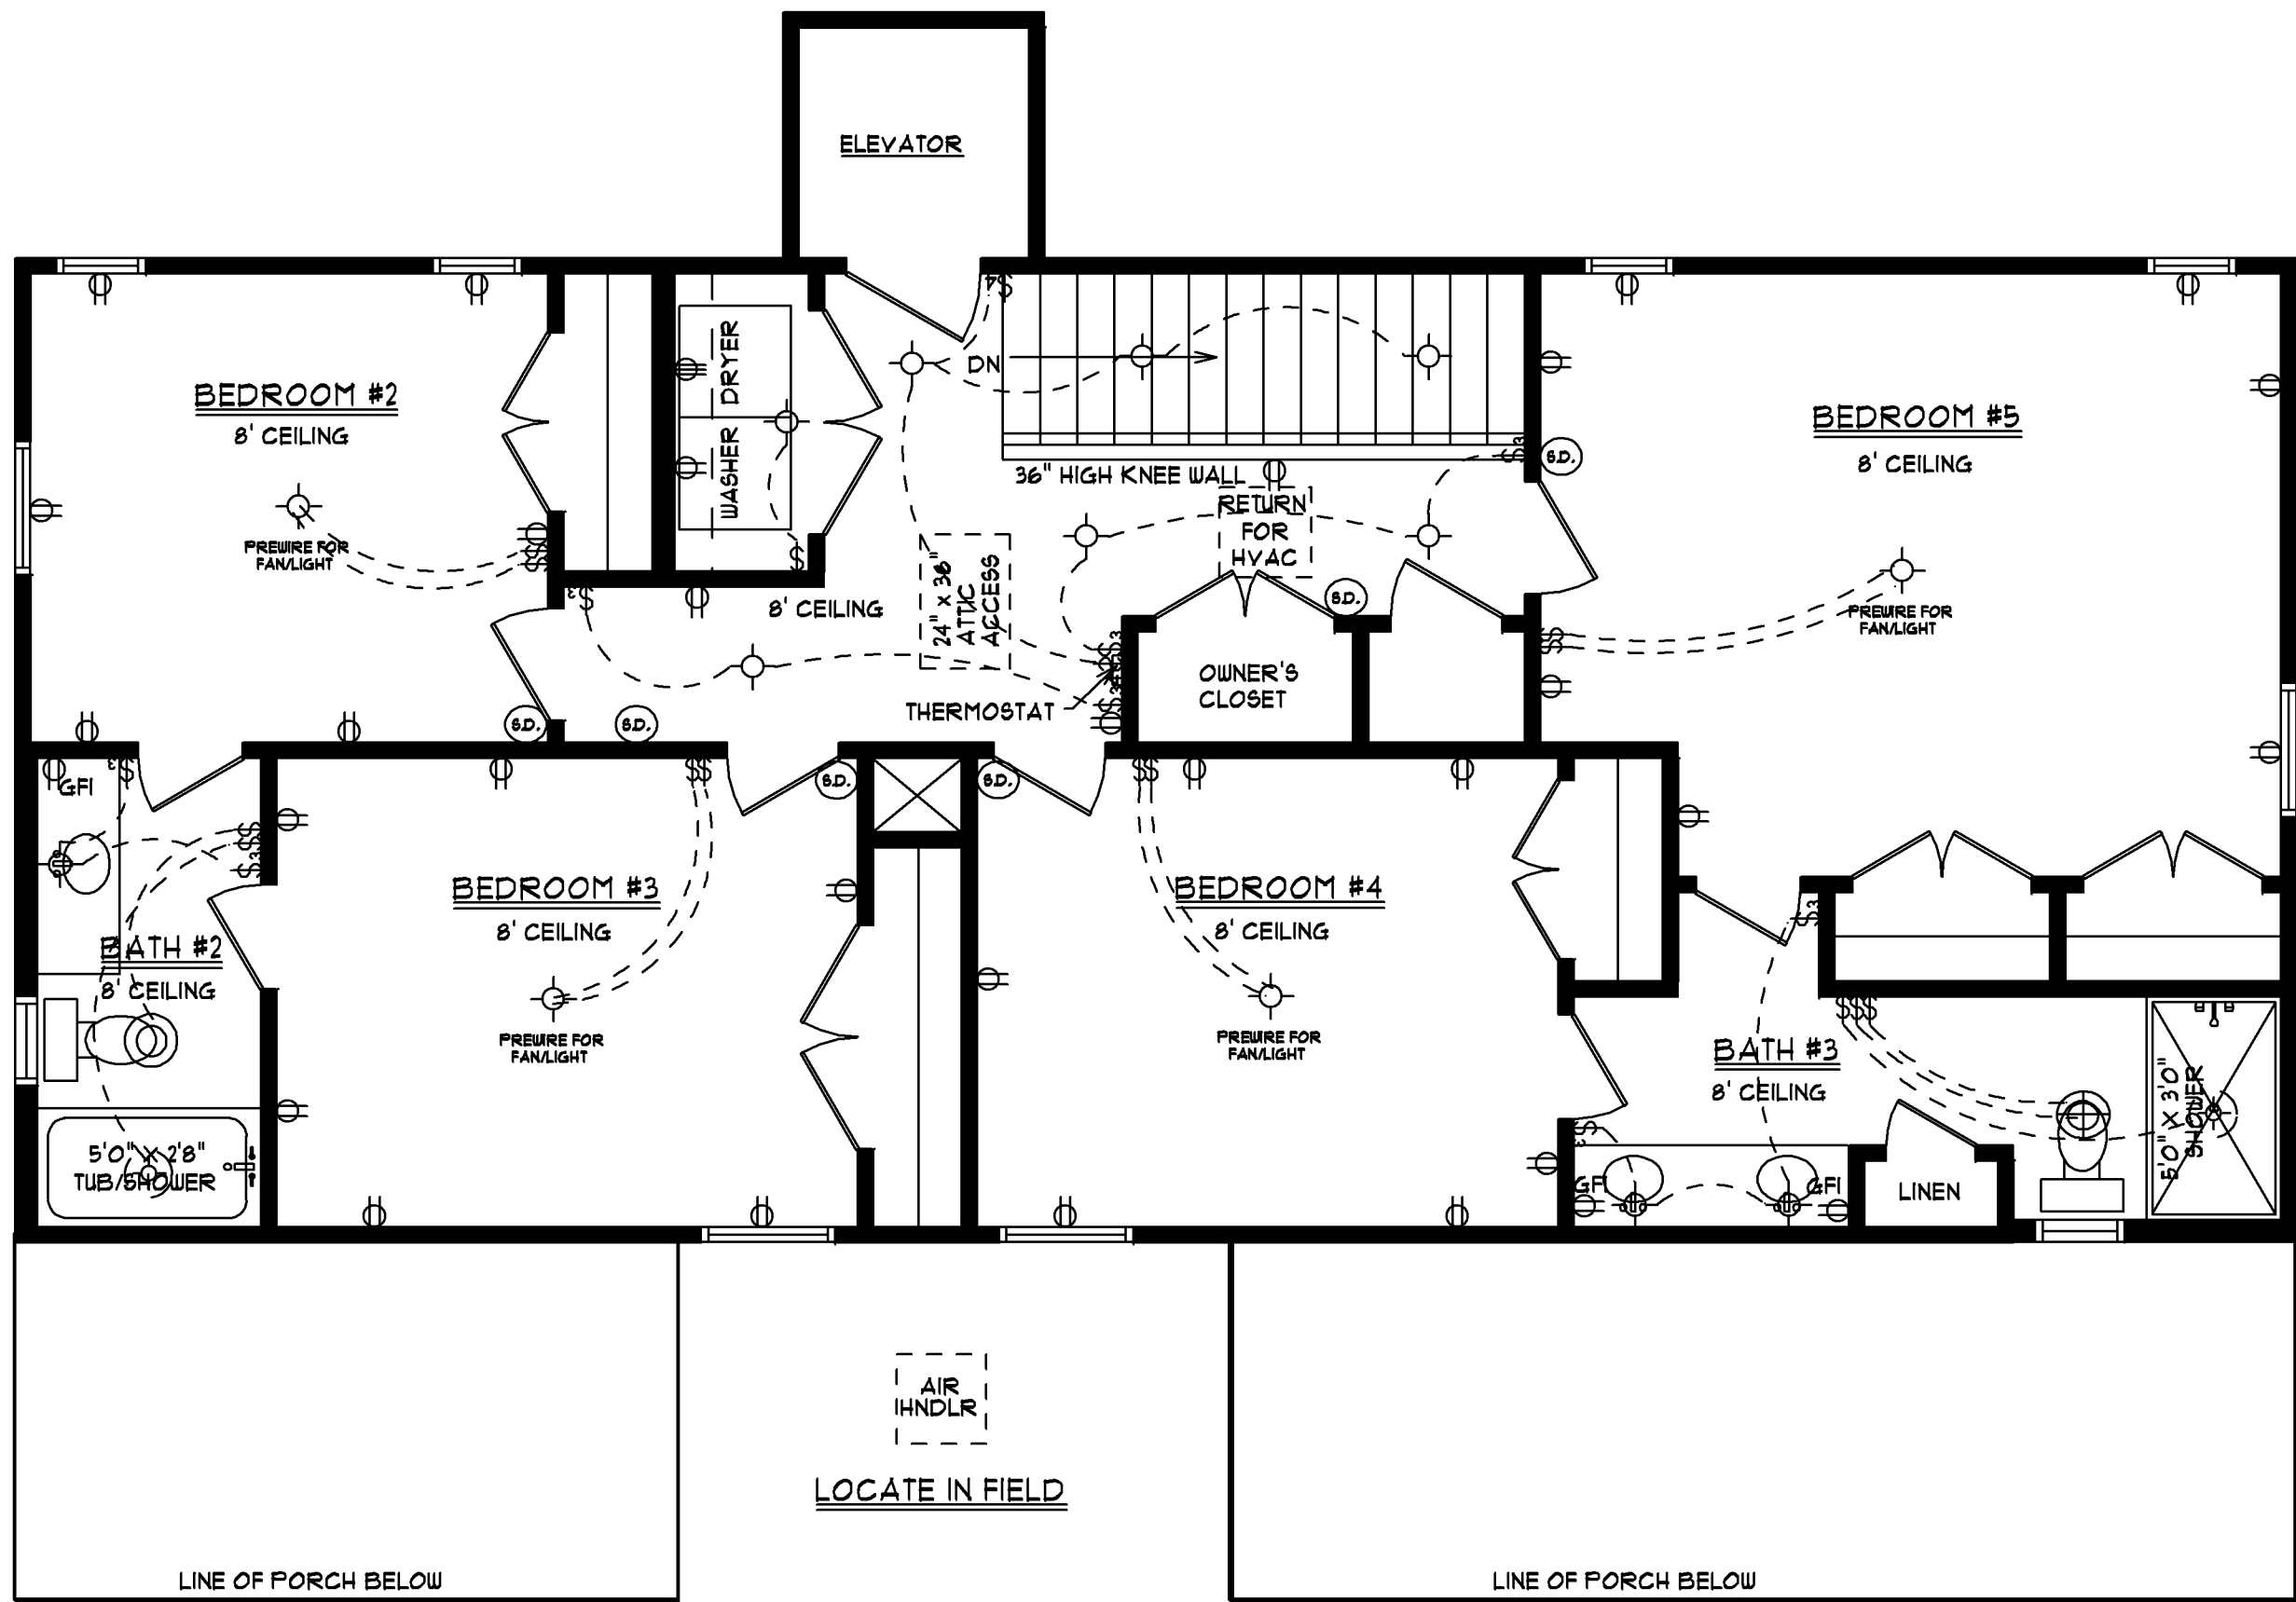

PAULA BURGIN
1341 CROOKED OAK DRIVE
PAULLEY'S ISLAND, SC 29565
C18431 979 - 5500
BURGINPAULA@AOL.COM

SCALE: 1/4" = 1'0"

DATE 5/8/24

SHEET #8
3RD FLOOR
ELECTRICAL

JOB LOCATION:
514 VISTA DRIVE
GARDEN CITY, SC

640
1154
1106
2900
104
181
309
4104
72

SQUARE FOOTAGE:
1ST FLOOR HEATED
2ND FLOOR HEATED
3RD FLOOR HEATED
TOTAL HEATED SPACE
PARKING
COVERED PATIOS
COVERED PORCHES
TOTAL UNDER ROOF
DECK

EXPERT
PROPERTIES LLC

EXPERT
PROPERTIES LLC

JOB LOCATION:
514 VISTA DRIVE
GARDEN CITY, SC


SQUARE FOOTAGE:	640
1ST FLOOR HEATED	1154
2ND FLOOR HEATED	1106
3RD FLOOR HEATED	2900
TOTAL HEATED SPACE	104
PARKING	191
COVERED PATIOS	303
COVERED PORCHES	4104
TOTAL UNDER ROOF	12
DECK	

SHEET #9

ROOF PLAN

SCALE: 1/4" = 1' 0"

DATE 5/8/24

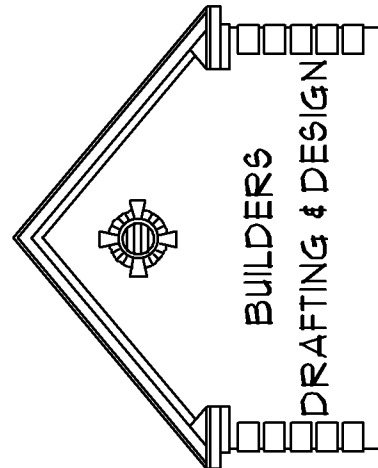

PAULA BURGIN

1341 CROOKED OAK DRIVE
PAULLEY ISLAND, SC 29585
C18431 978 - 5500
C18431 283 - 3113
BURGINPAULA@AOL.COM

