
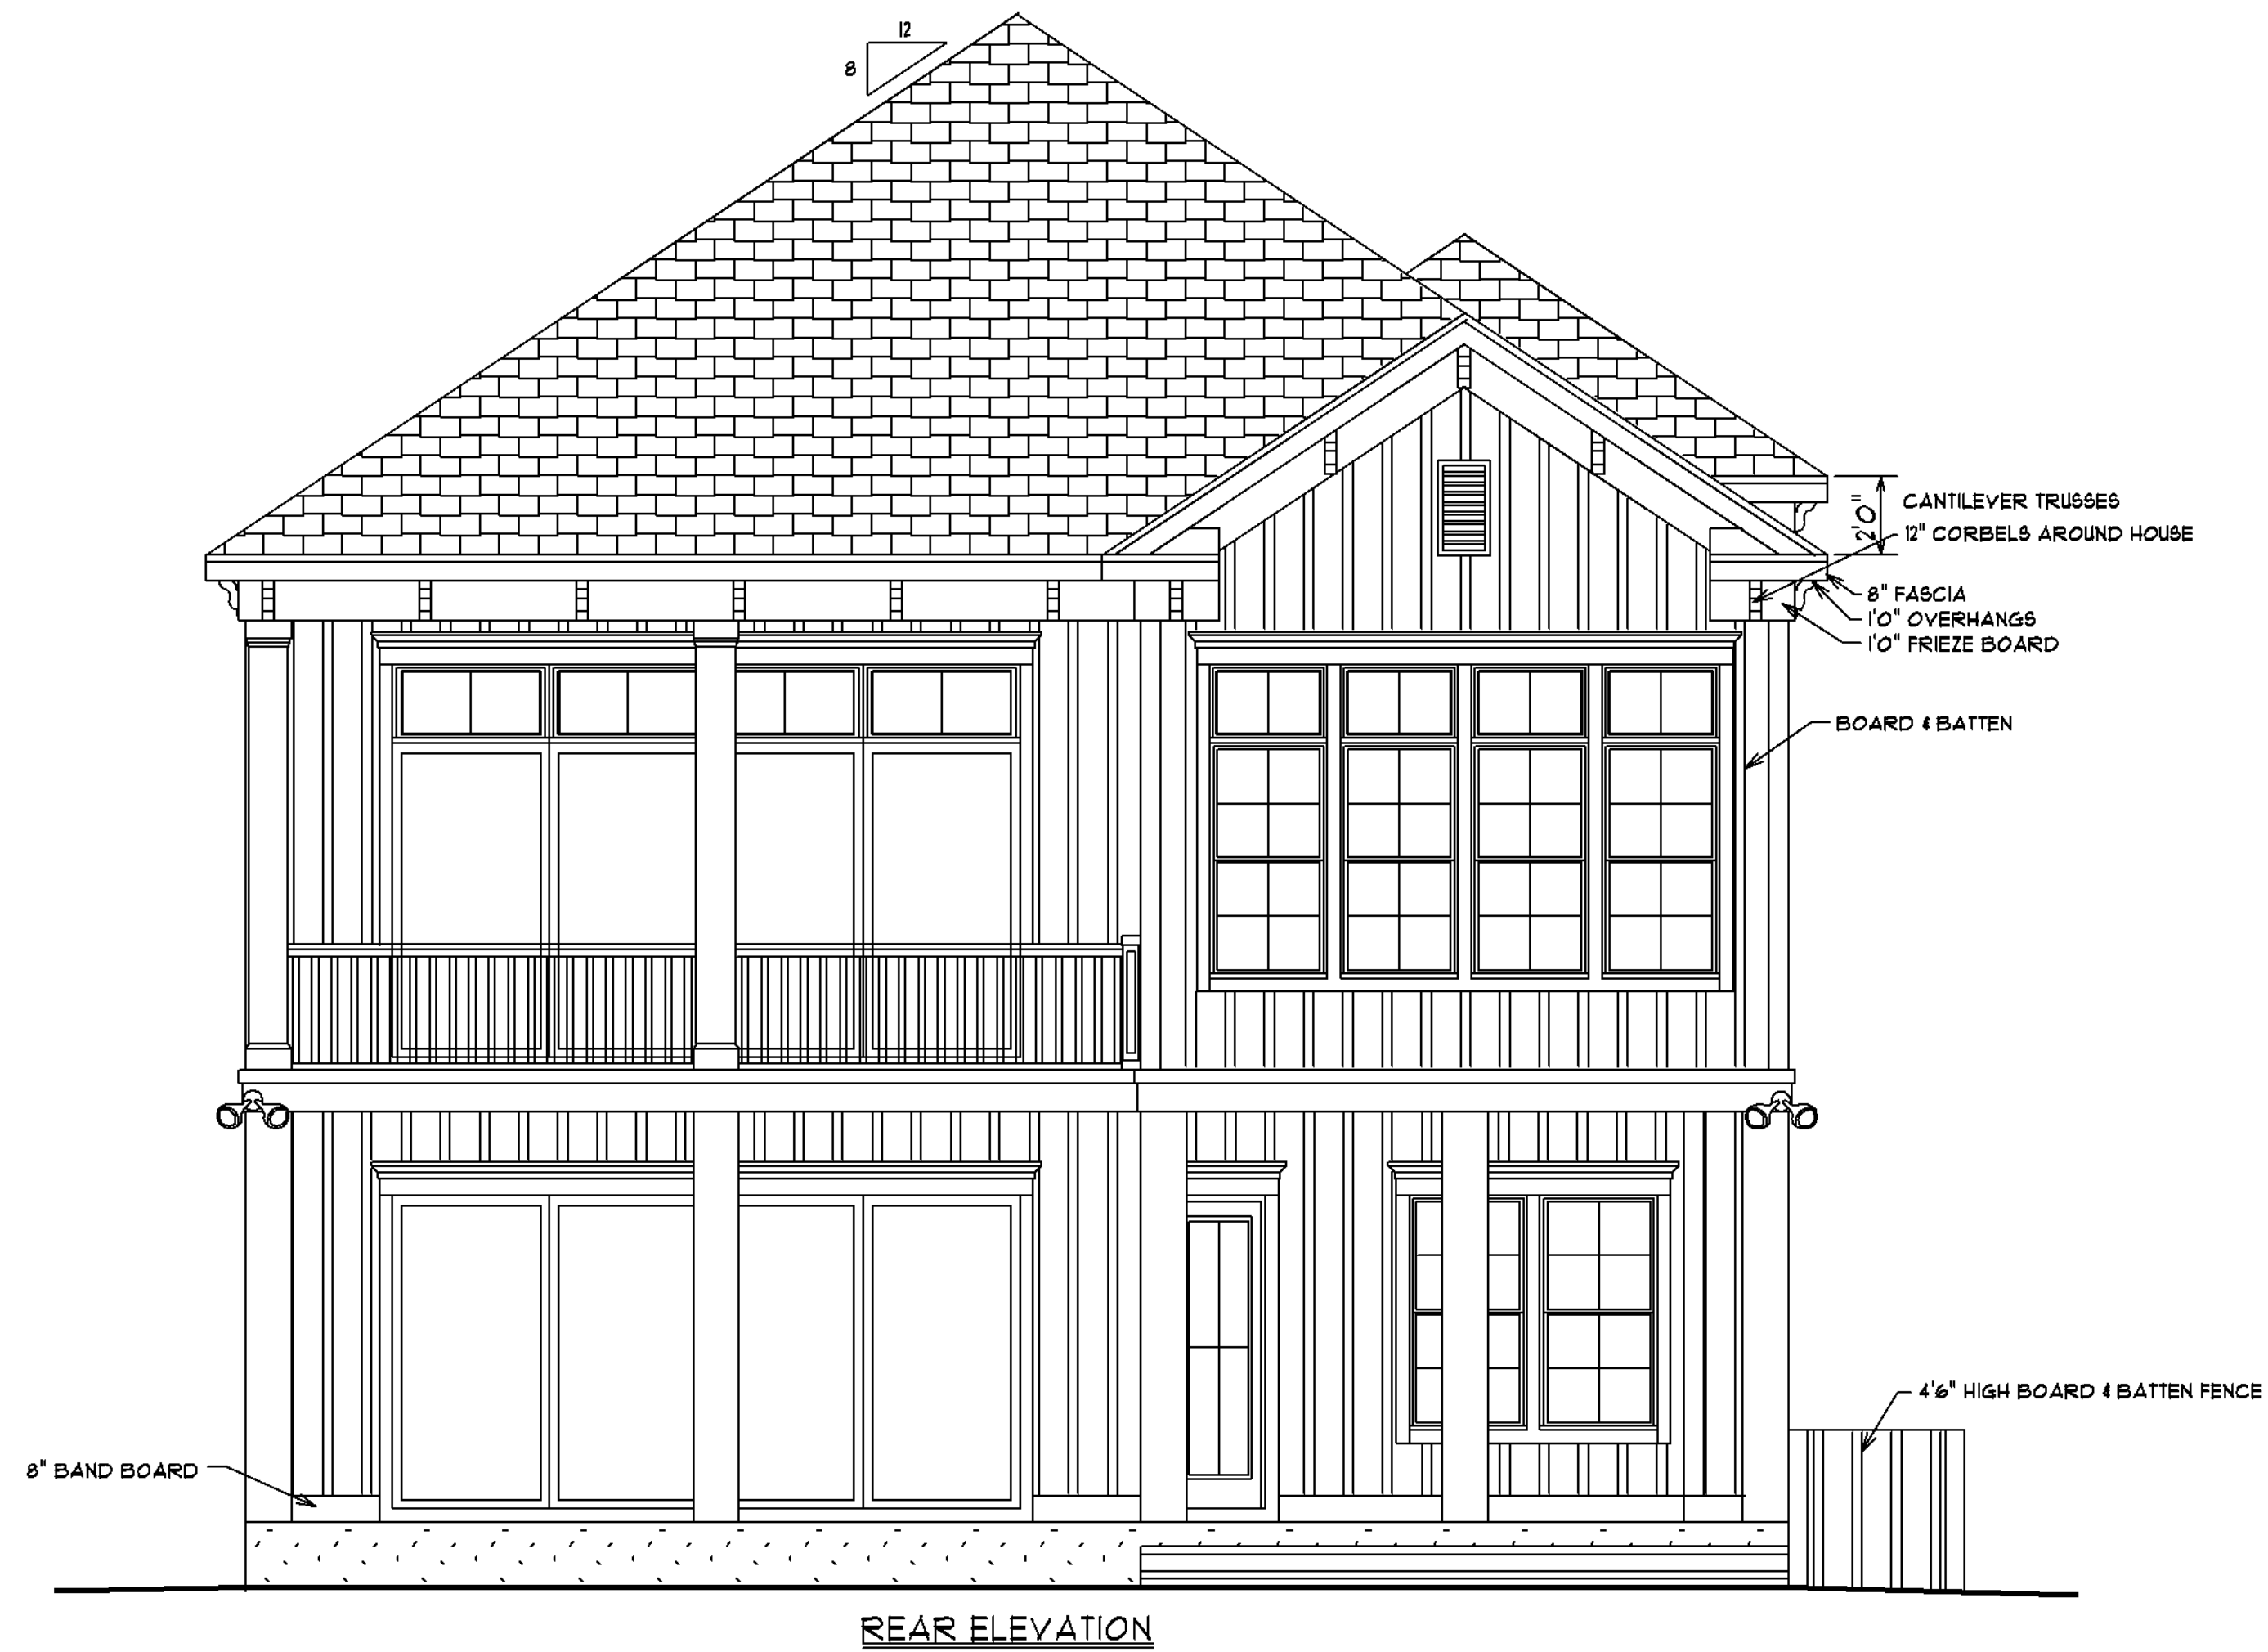


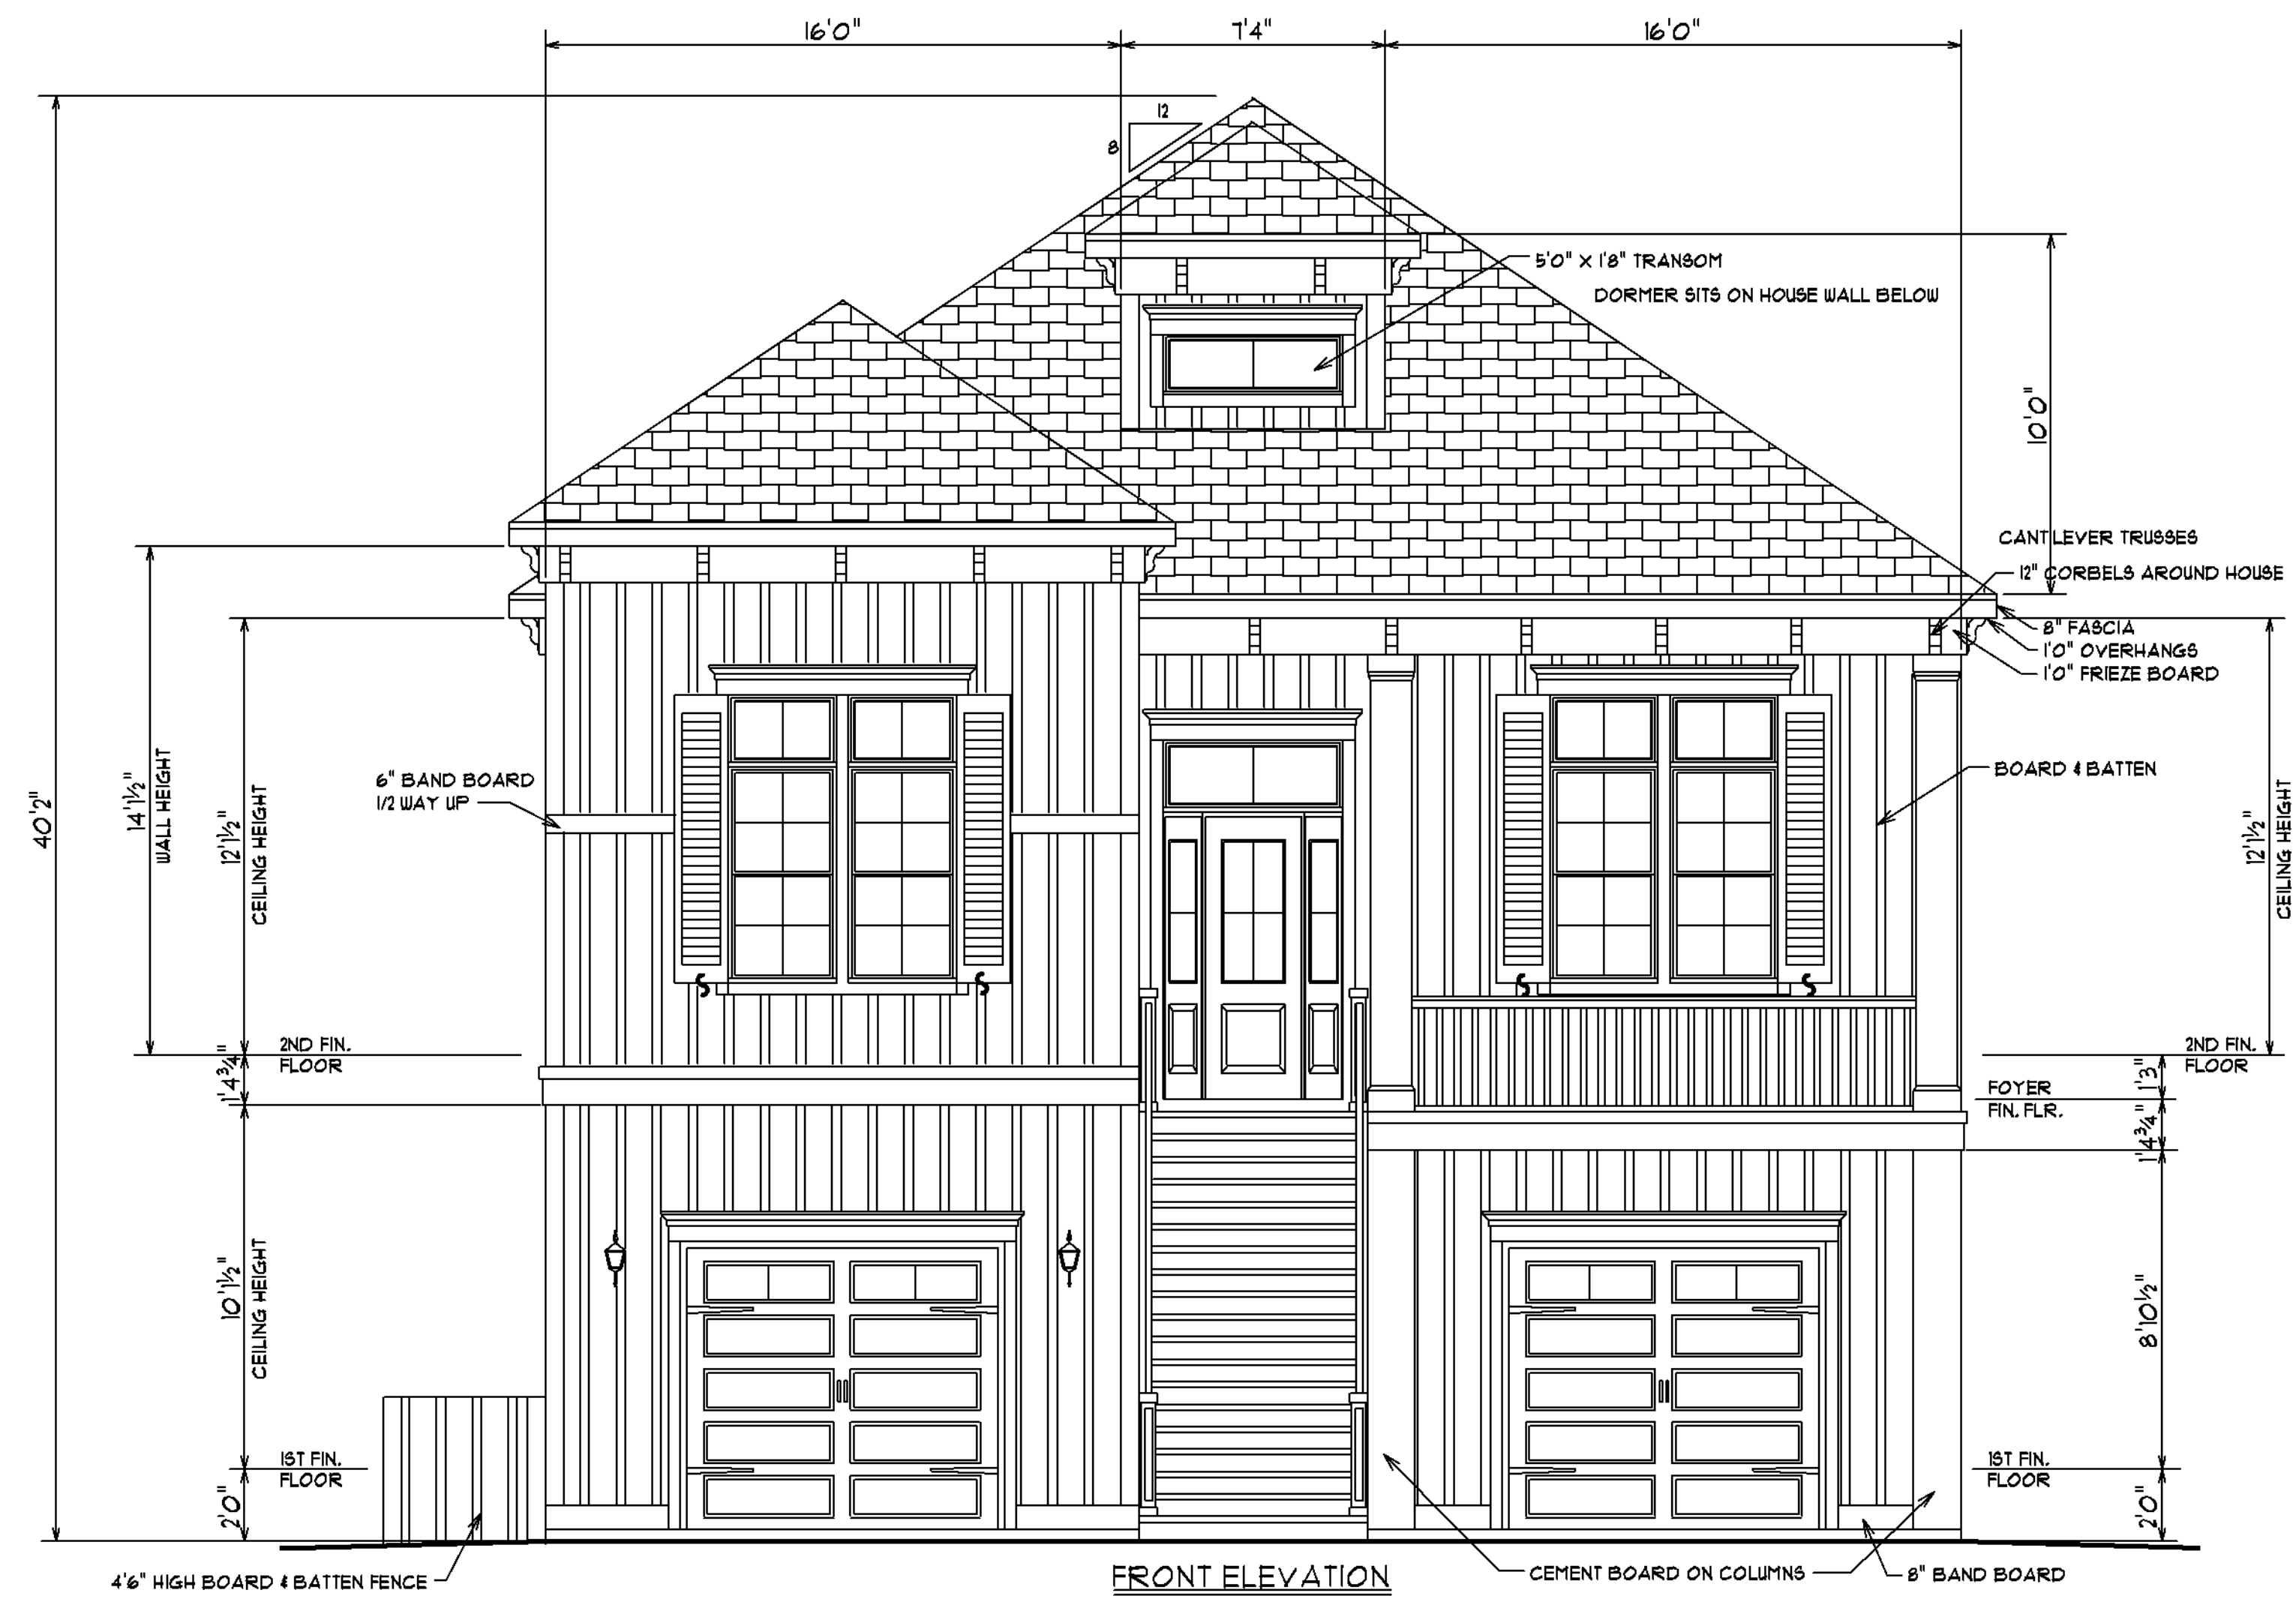

SCALE: 1/4" = 1'0"

DATE: 2/19/22

SHEET #1


ELEVATIONS

JOB LOCATION:
LOT 69 HARBOUR VIEW DRIVE
BOARDWALK ON THE WATERWAY
MYRTLE BEACH, SC


SQUARE FOOTAGE:	924
1ST FLOOR HEATED	2484
2ND FLOOR HEATED	3408
TOTAL HEATED SPACE	1253
GARAGE	183
COVERED AREA	654
COVERED PATIO	183
ENTRY PORCH	274
COVERED PORCH	5955
TOTAL UNDER ROOF	



LEFT ELEVATION

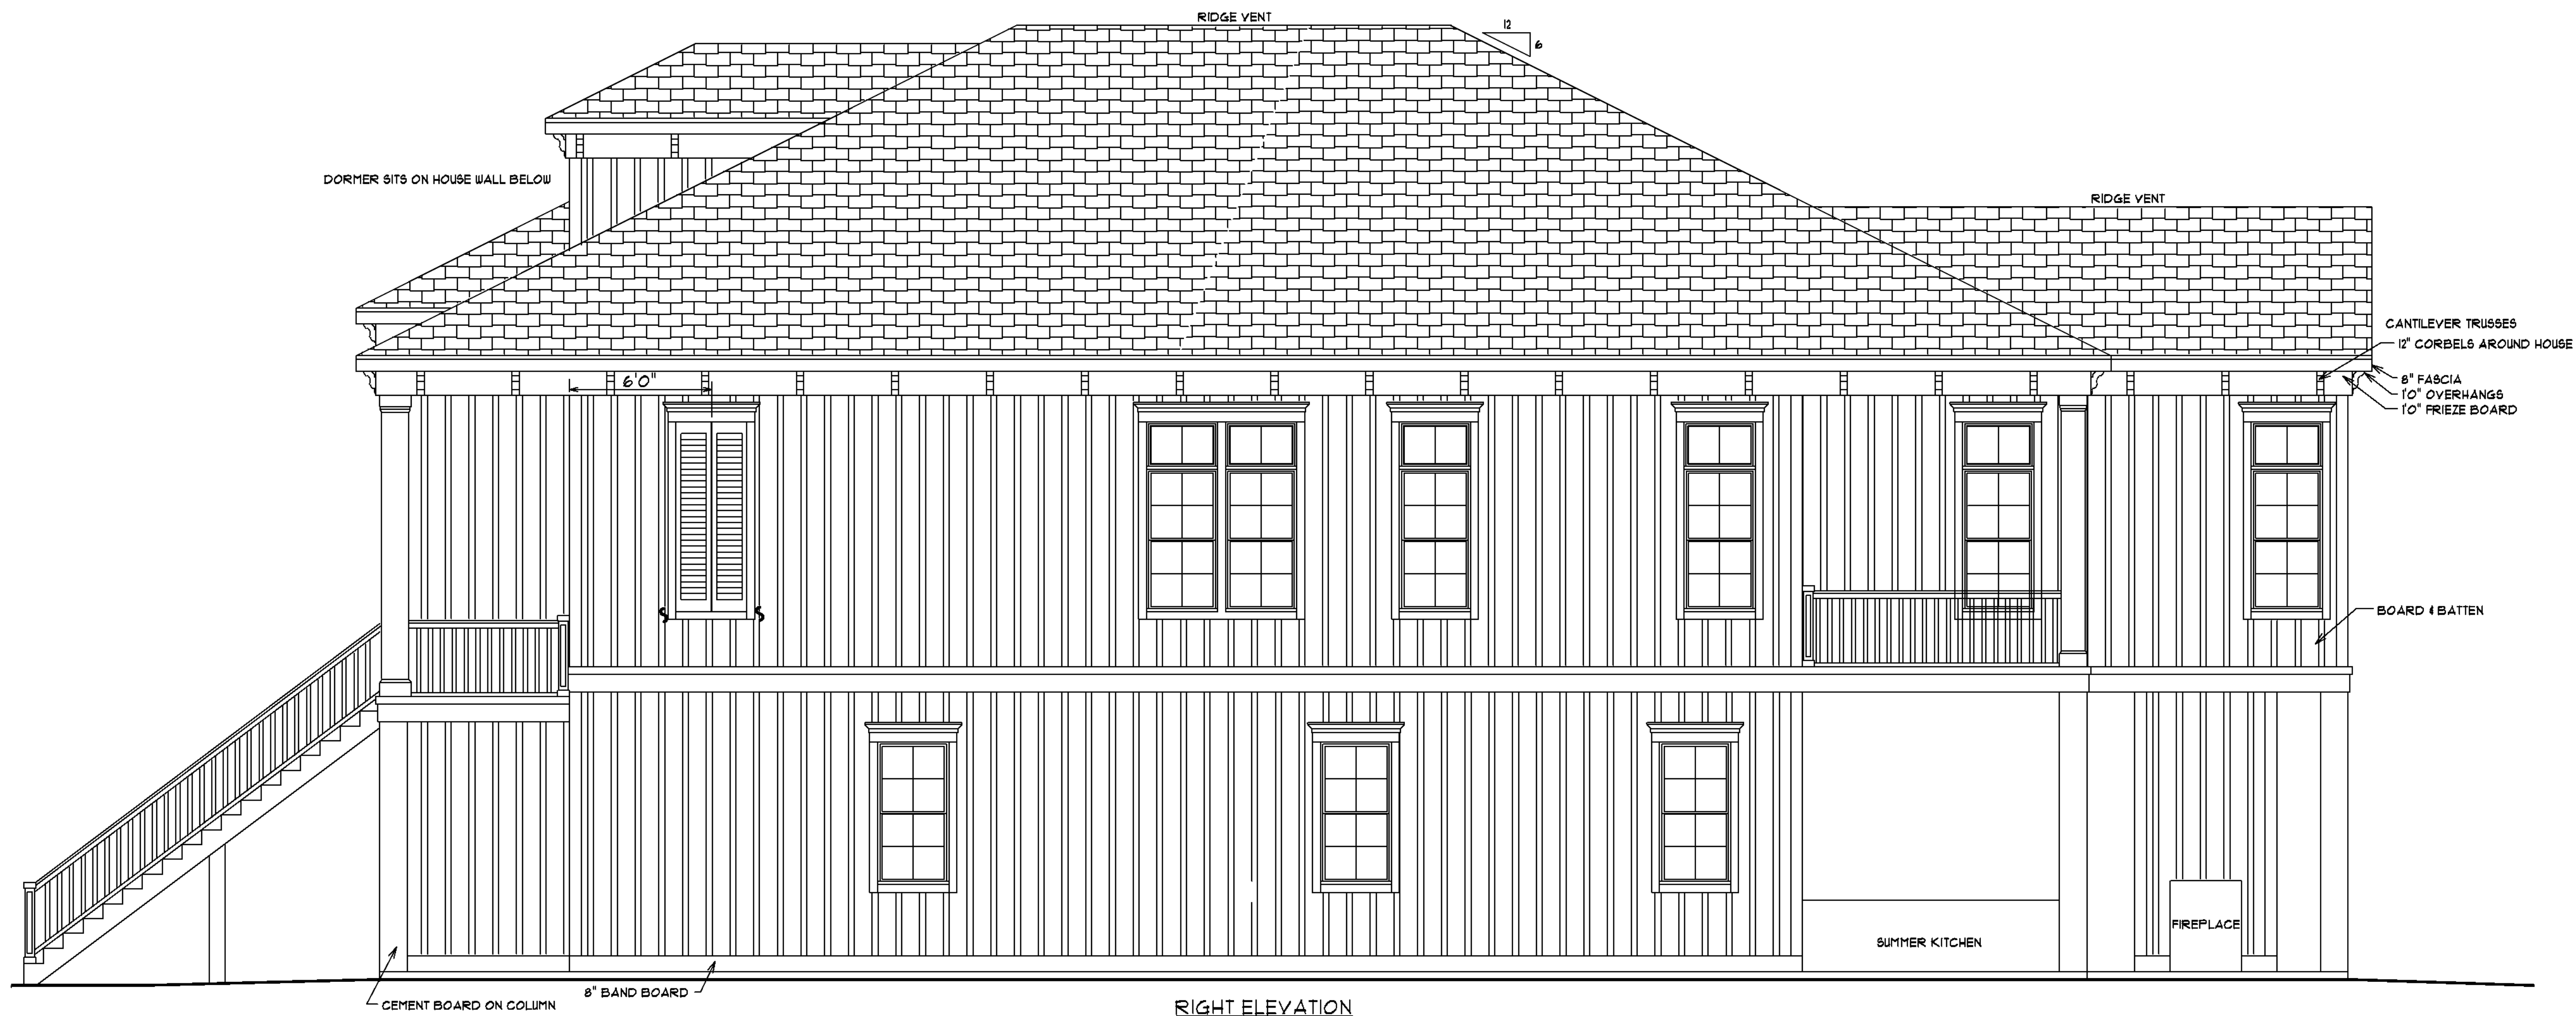

RIGHT ELEVATION

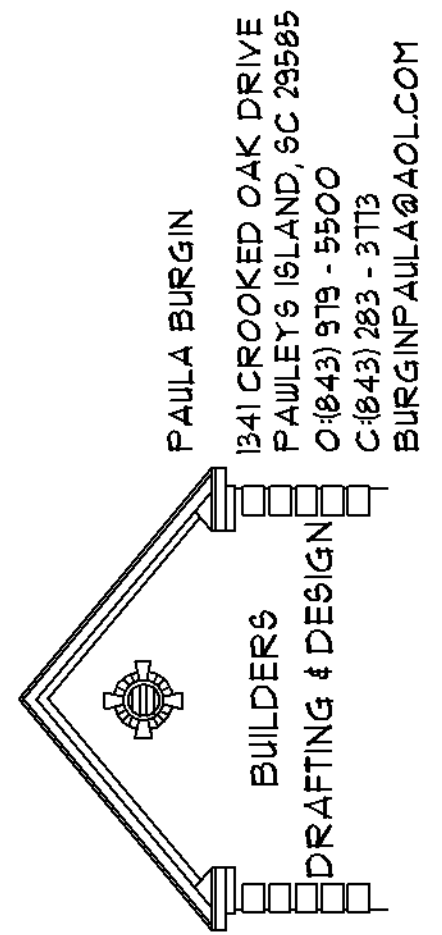

SCALE: 1/4" = 1'0"


DATE: 2/19/22


SHEET #2

ELEVATIONS

JOB LOCATION:
LOT 69 HARBOUR VIEW DRIVE
BOARDWALK ON THE WATERWAY
MYRTLE BEACH, SC

SQUARE FOOTAGE:	924
1ST FLOOR HEATED	2484
2ND FLOOR HEATED	3408
TOTAL HEATED SPACE	1253
GARAGE	183
COVERED AREA	654
COVERED PATIO	183
ENTRY PORCH	214
COVERED PORCH	5955
TOTAL UNDER ROOF	

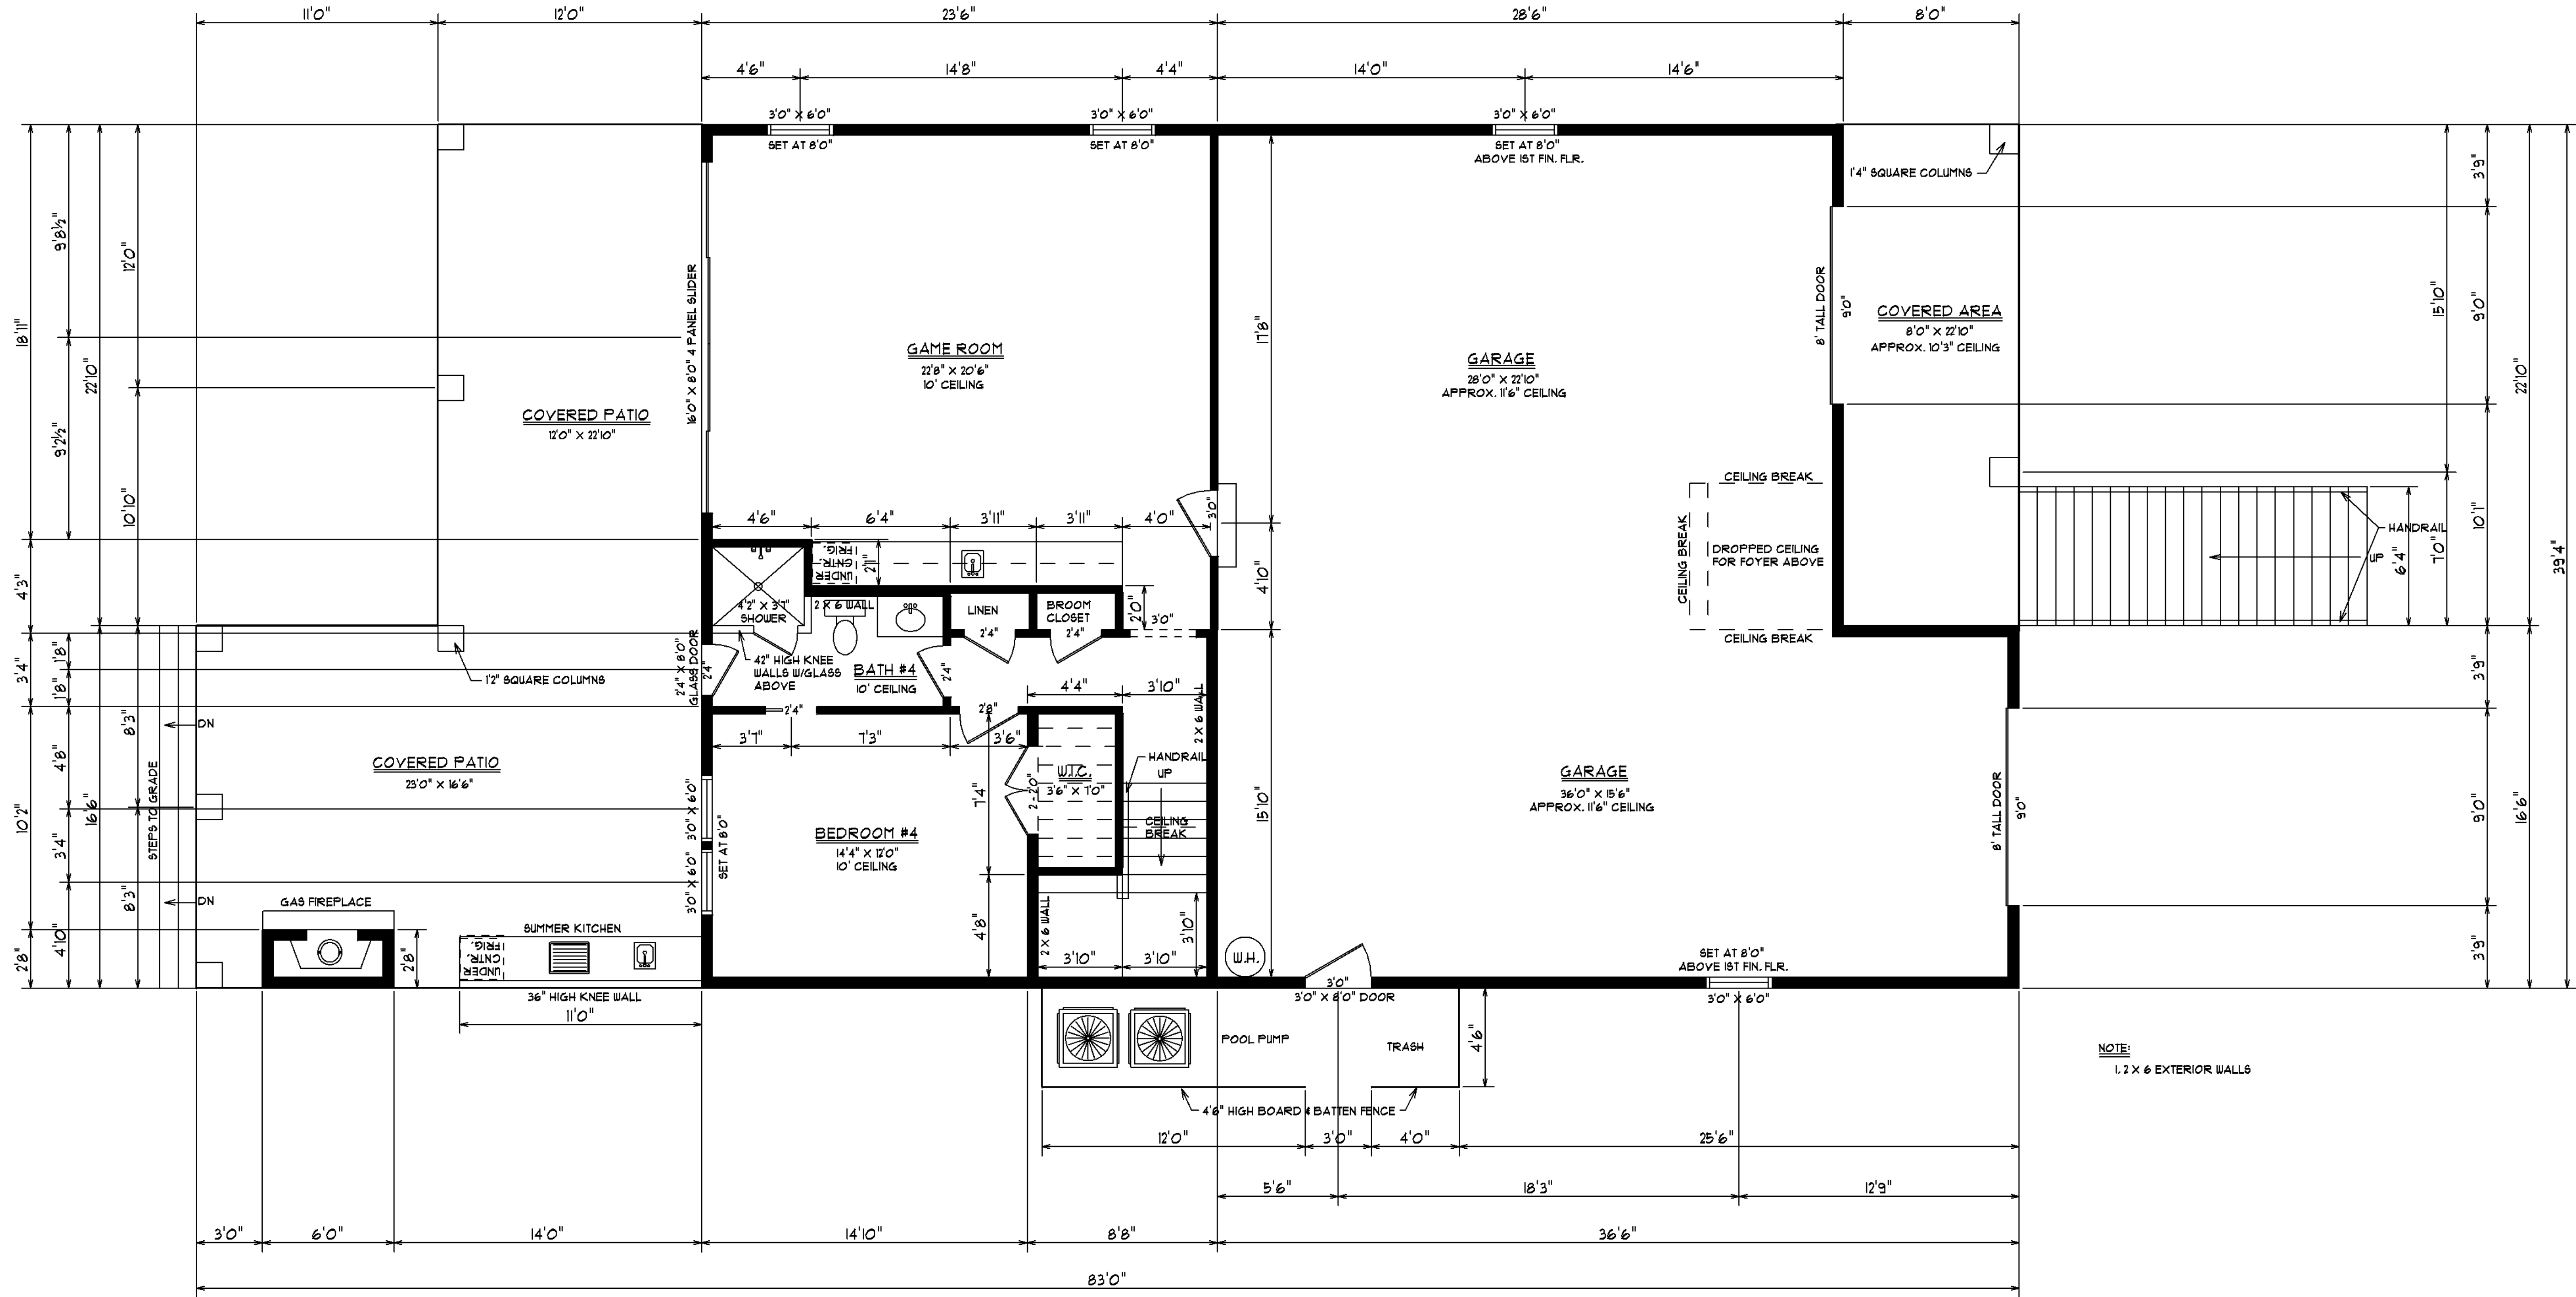

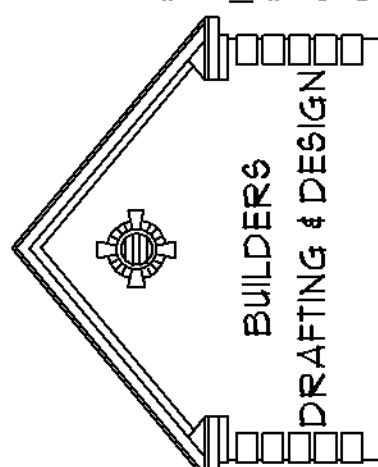

PAULA BURGIN

1341 CROOKED OAK DRIVE

PAULEY ISLAND, SC 29985

0843) 919 - 5500

0843) 283 - 3773

BURGINPAULA@AOL.COM


SCALE: 1/4" = 1'0"

DATE: 2/19/22

SHEET #3

FIRST FLOOR PLAN

JOB LOCATION:		LOT 69 HARBOUR VIEW DRIVE	
		BOARDWALK ON THE WATERWAY	
		MYRTLE BEACH, SC	
SQUARE FOOTAGE:	1ST FLOOR HEATED	924	
	2ND FLOOR HEATED	2484	
	TOTAL HEATED SPACE	3408	
	GARAGE	1253	
	COVERED AREA	183	
		654	
		183	
		274	
		5355	

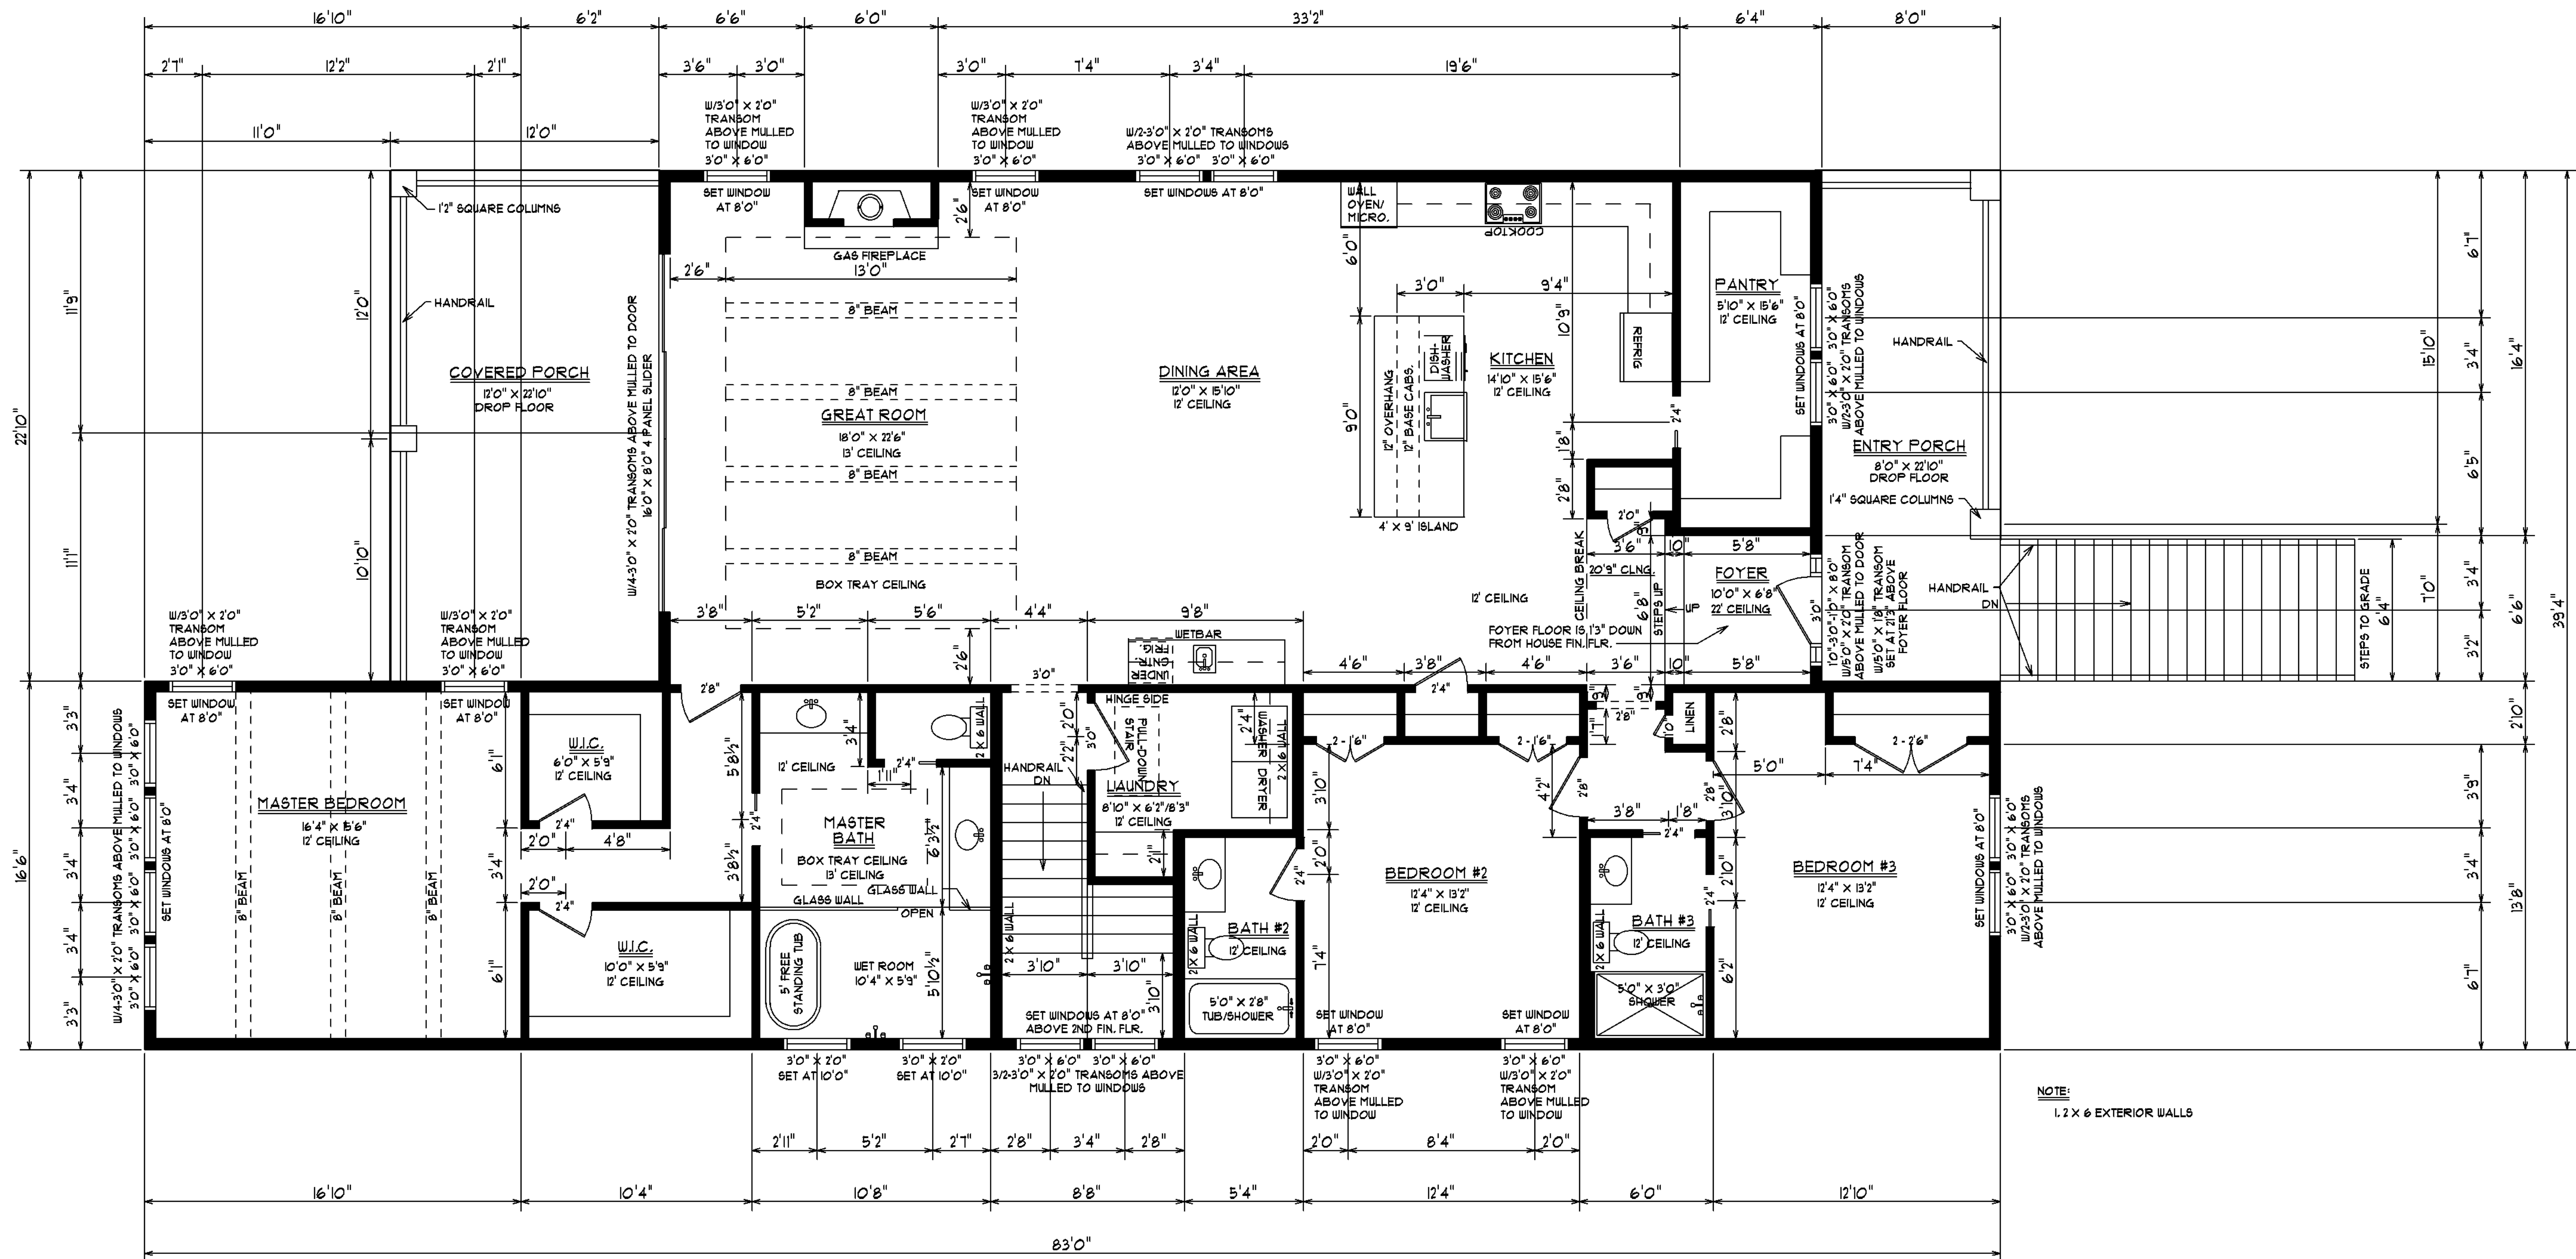

BURGINS BUILDERS
DRAWING & DESIGN

PAULA BURGINS
1341 CROOKED OAK DRIVE
PAULEY ISLAND, SC 29585
C18431919 - 5500
C18431283 - 3173
BURGINPAULA@AOL.COM


SCALE: 1/4" = 1'0"

DATE: 2/19/22

SHEET #4
SECOND FLOOR PLAN

JOB LOCATION:		LOT 69 HARBOUR VIEW DRIVE BOARDWALK ON THE WATERWAY MYRTLE BEACH, SC	
SQUARE FOOTAGE:	1ST FLOOR HEATED	924	
	2ND FLOOR HEATED	2484	
	TOTAL HEATED SPACE	3408	
	GARAGE	1253	
	COVERED AREA	183	
COVERED PATIO		654	
ENTRY PORCH		183	
COVERED PORCH		214	
TOTAL UNDER ROOF		5955	

ELECTRICAL LEGEND	
SYMBOL	DESCRIPTION
	LIGHT
	RECESSED CAN LIGHT
	SWITCH
	3-WAY SWITCH
	220 OUTLET
	110 OUTLET
	GROUND FAULT INTERRUPTER
	TELEVISION
	TELEPHONE
	BATH FAN/LIGHT
	BATH FAN ONLY
	GARBAGE DISPOSAL
	SPEAKER
	DOORBELL BUTTON
	SMOKE DETECTOR
	DOUBLE FLOOD LIGHT
	HOSE BIB
	PREWIRED FAN/LIGHT

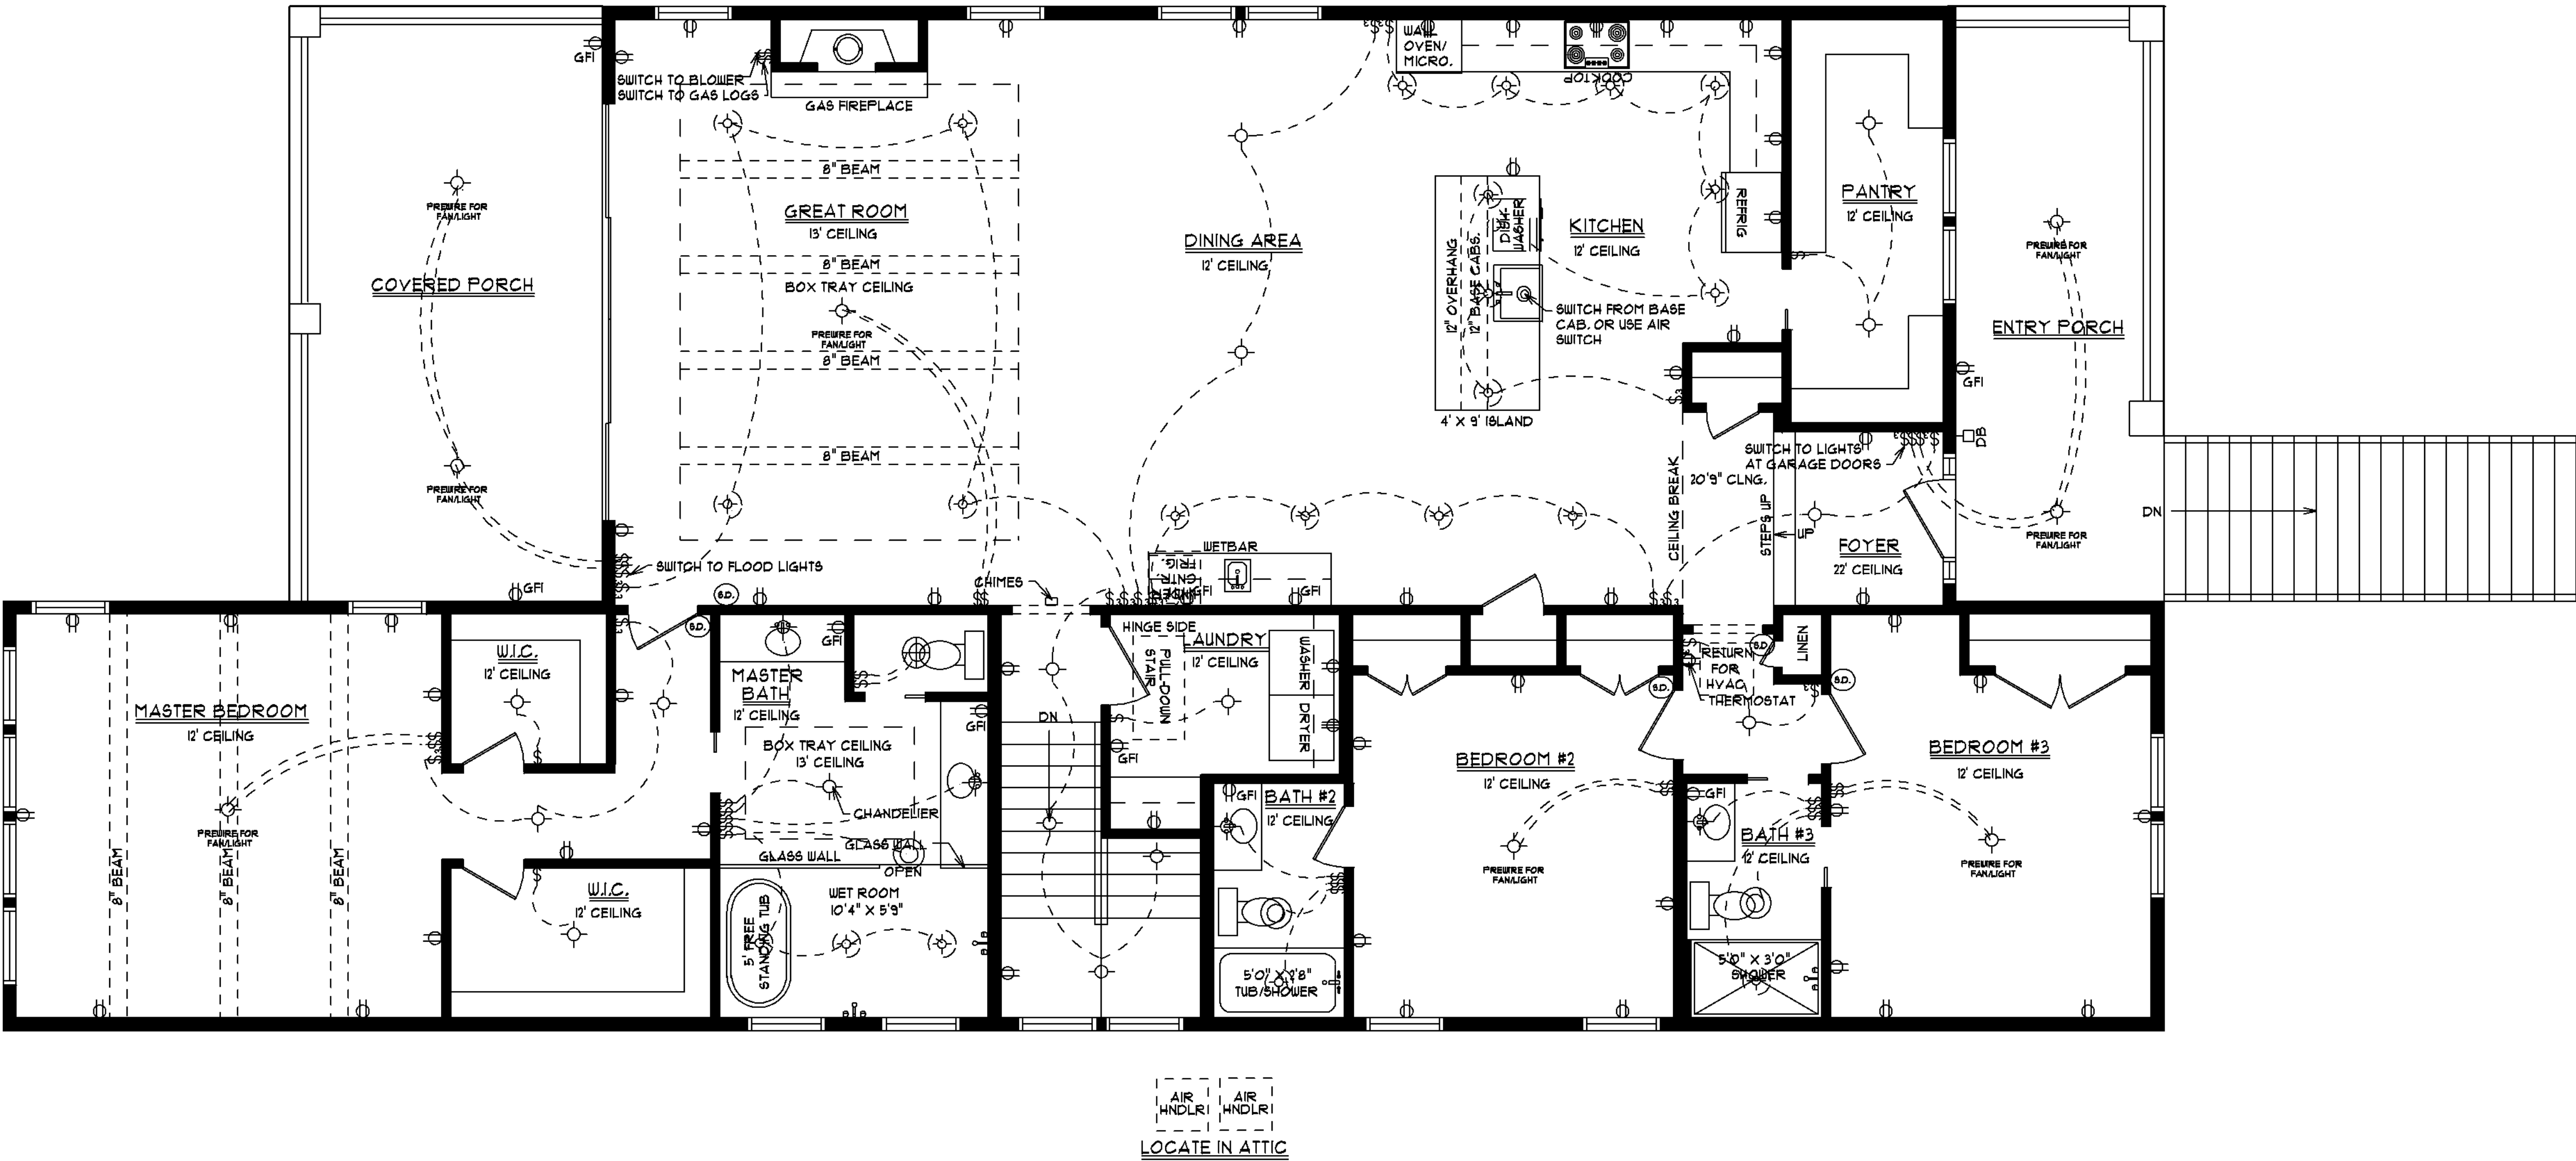

PAULA BURGIN
1341 CROOKED OAK DRIVE
PAULEY ISLAND, SC 29985
C(843) 919 - 5500
BURGINPAULA@AOL.COM

BUILDERS
DRAWING & DESIGN



SCALE: 1/4" = 1'0"

DATE: 2/19/22


SHEET #6
2ND FLOOR
ELECTRICAL

JOB LOCATION:
LOT 69 HARBOUR VIEW DRIVE
BOARDWALK ON THE WATERWAY
MYRTLE BEACH, SC

SQUARE FOOTAGE:	924
1ST FLOOR HEATED	2484
2ND FLOOR HEATED	3408
TOTAL HEATED SPACE	1253
GARAGE	654
COVERED AREA	183
COVERED PATIO	274
ENTRY PORCH	5955
COVERED PORCH	
TOTAL UNDER ROOF	

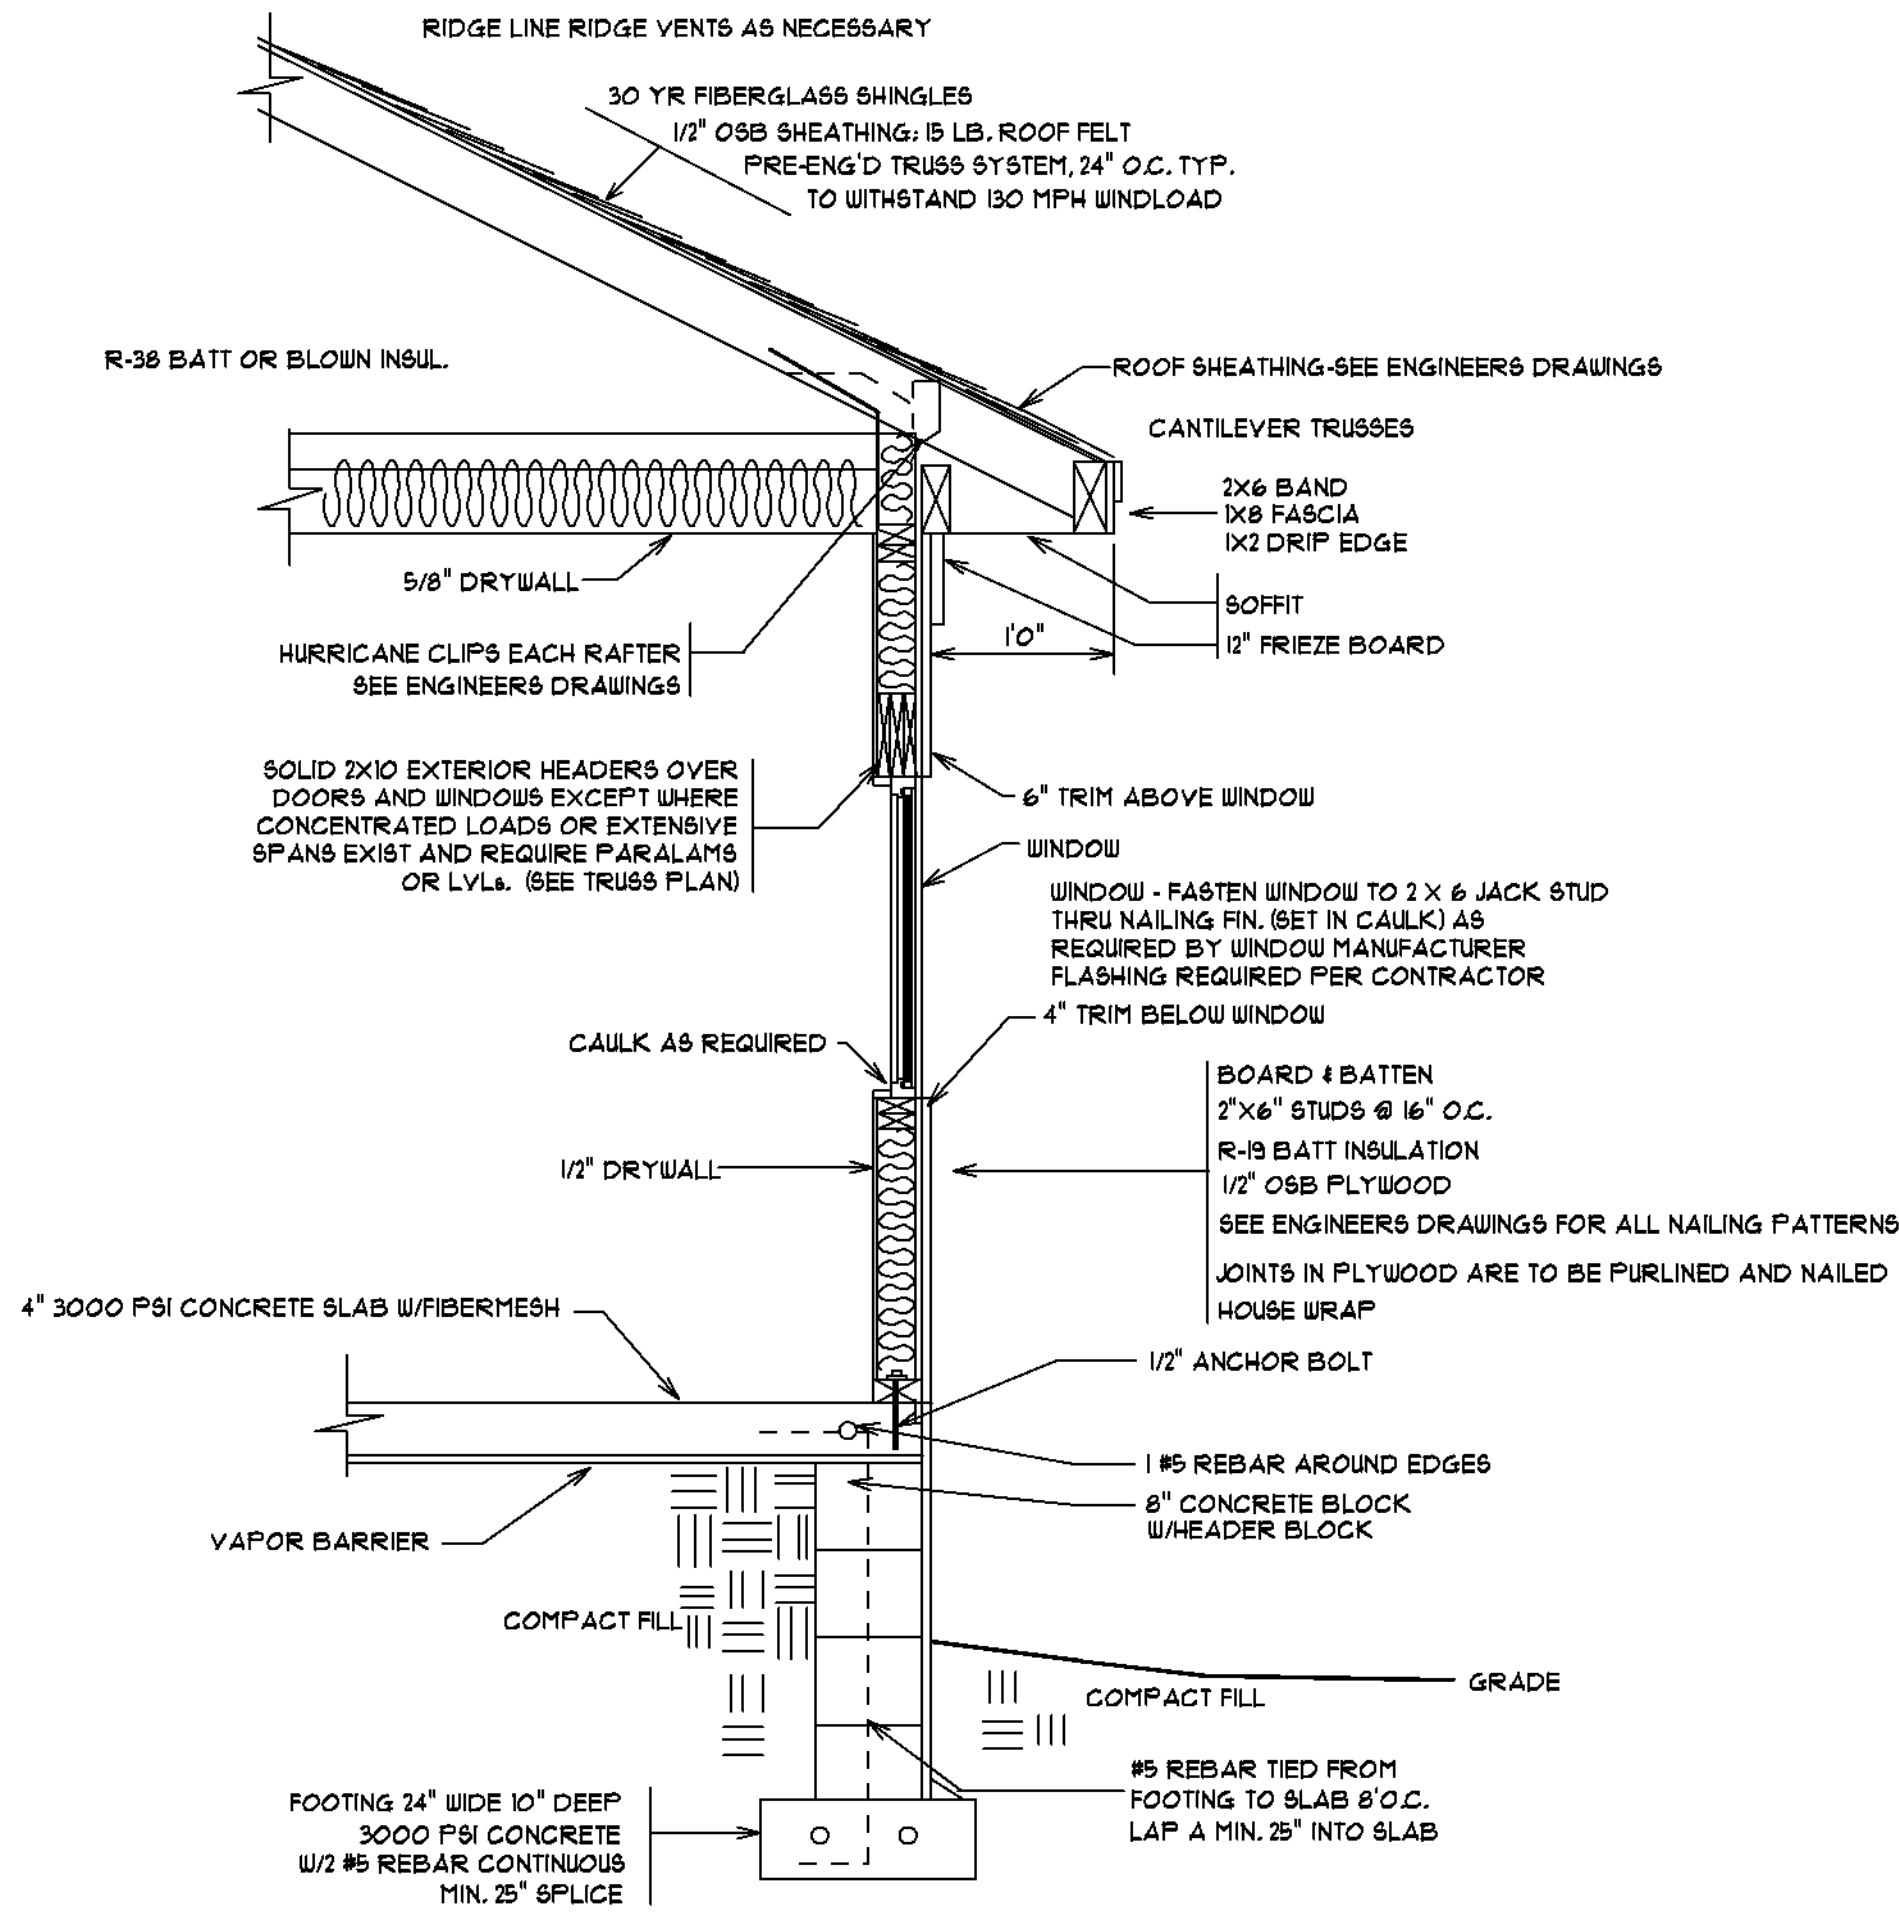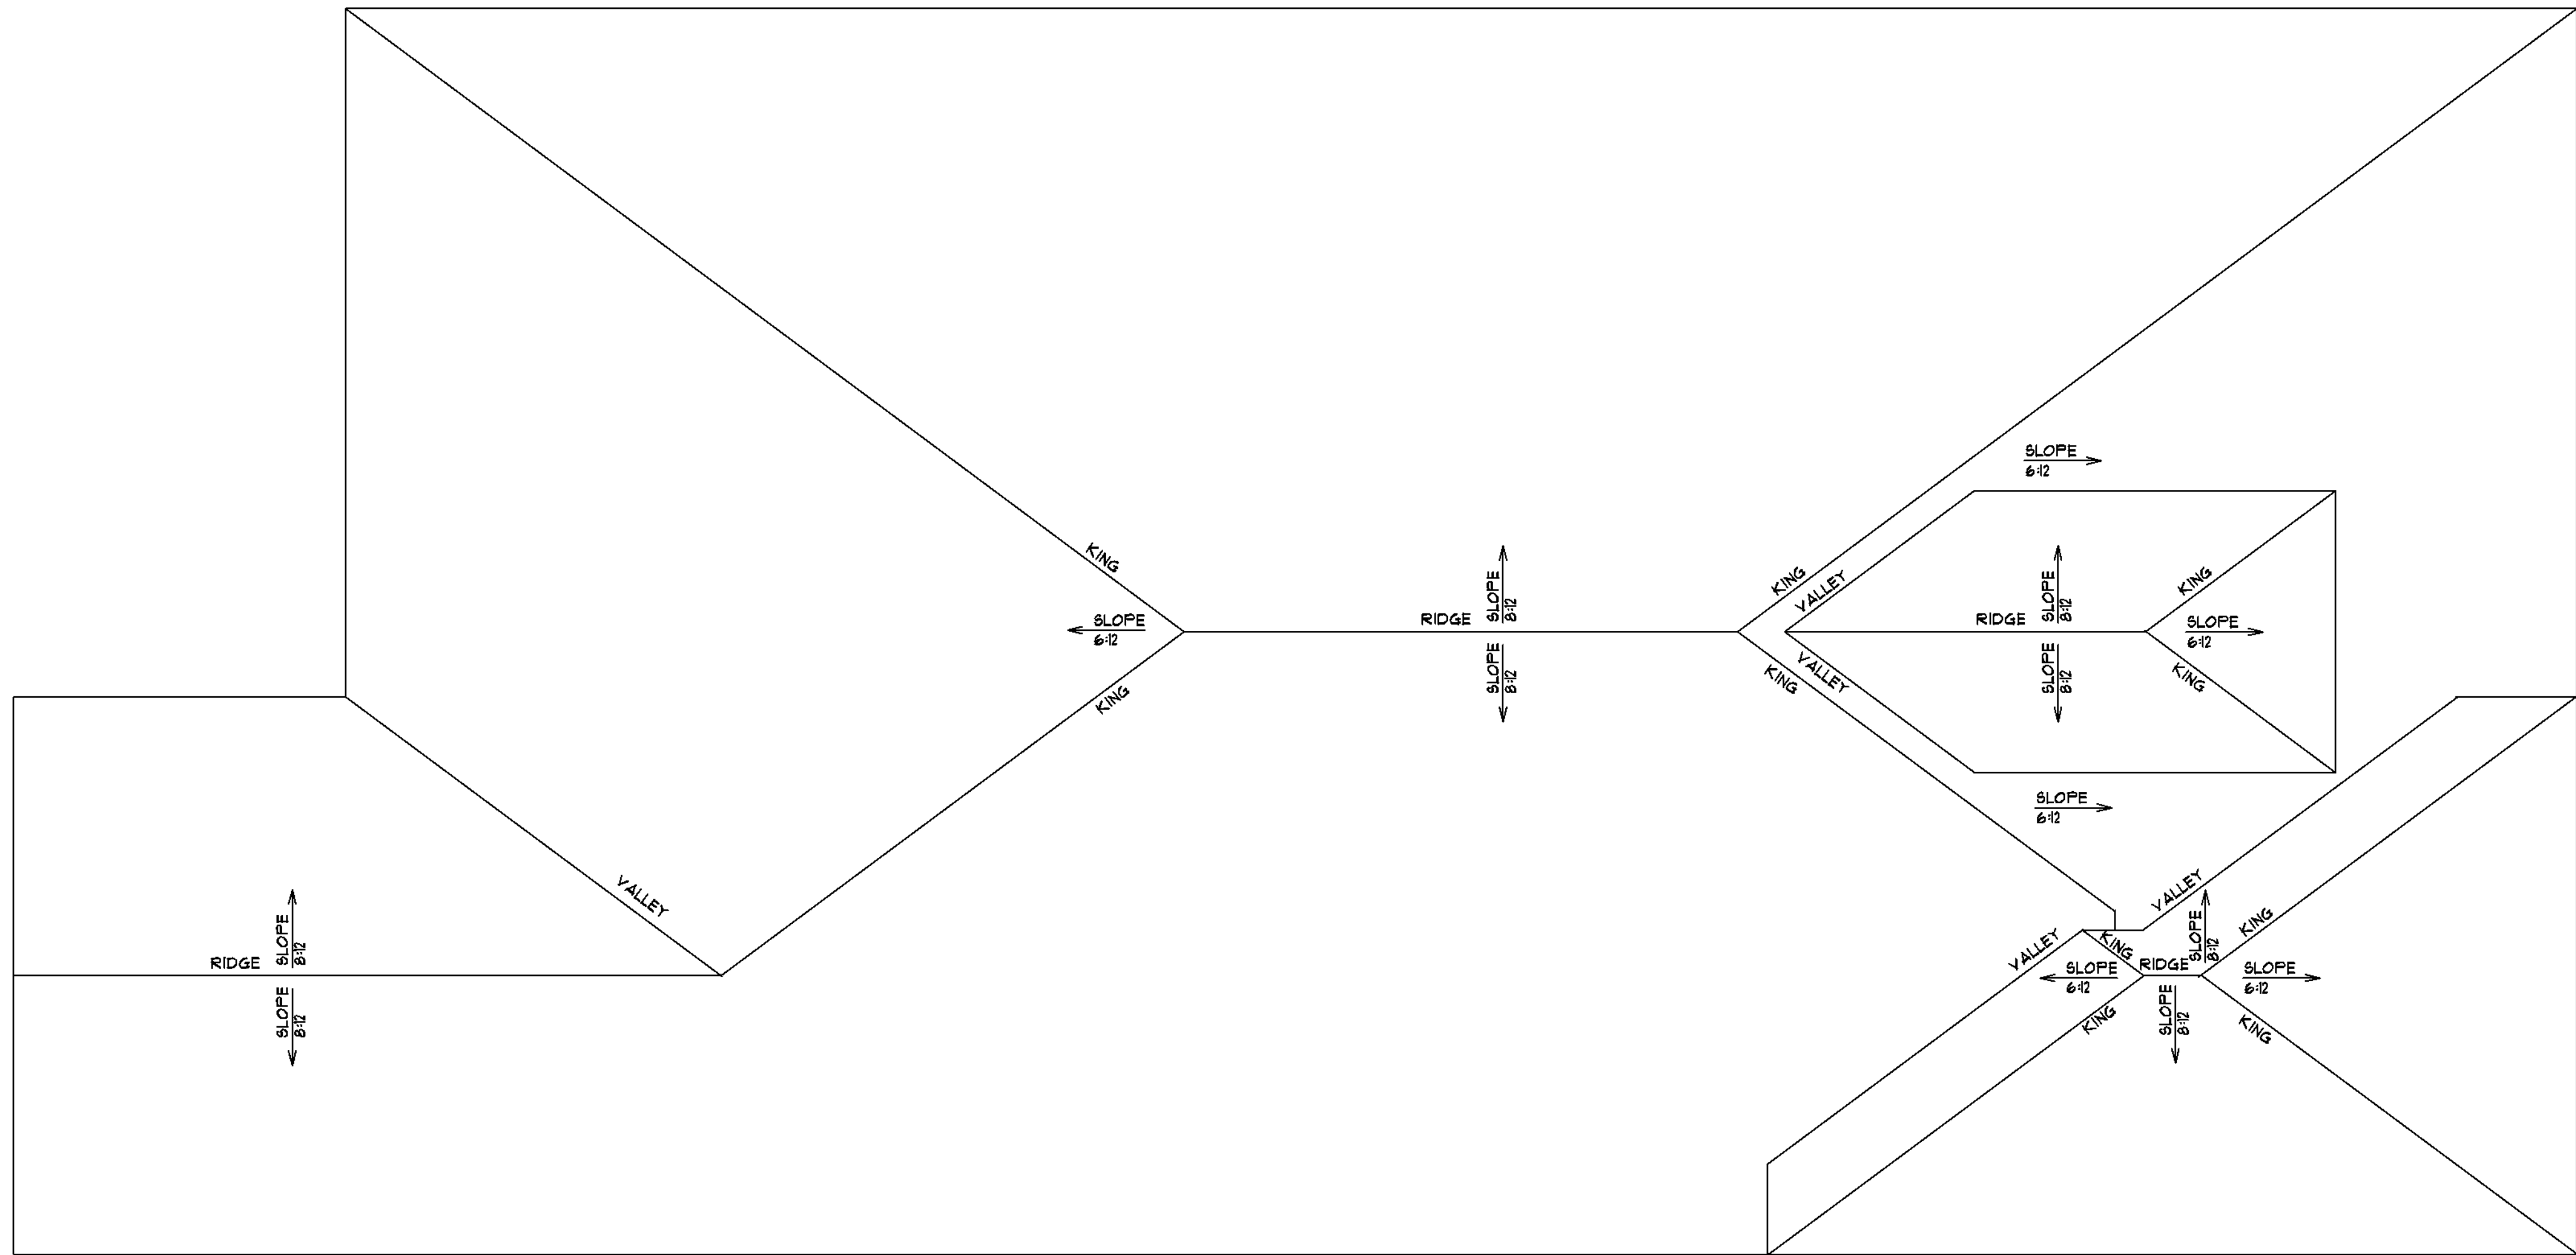

CROSS SECTION DETAIL
RAISED SLAB-BOARD & BATTEN
NOT TO SCALE

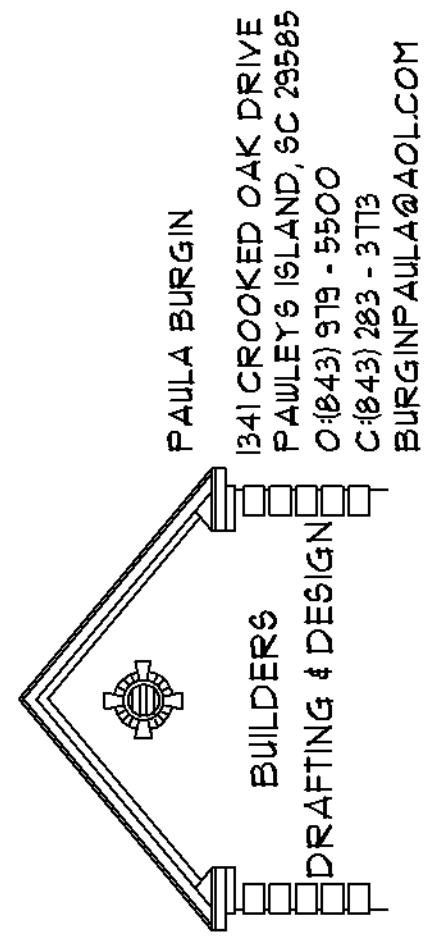


SCALE: 1/4" = 1'0"

DATE: 2/19/22


SHEET #7
ROOF PLAN/
DETAIL

JOB LOCATION:
LOT 69 HARBOUR VIEW DRIVE
BOARDWALK ON THE WATERWAY
MYRTLE BEACH, SC

SQUARE FOOTAGE:	924
1ST FLOOR HEATED	2484
2ND FLOOR HEATED	3408
TOTAL HEATED SPACE	1253
GARAGE	183
COVERED PATIO	654
ENTRY PORCH	183
COVERED PORCH	274
TOTAL UNDER ROOF	5355

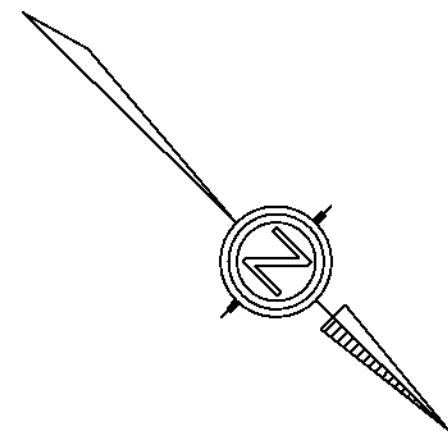

ATLANTIC INTRACOASTAL WATERWAY

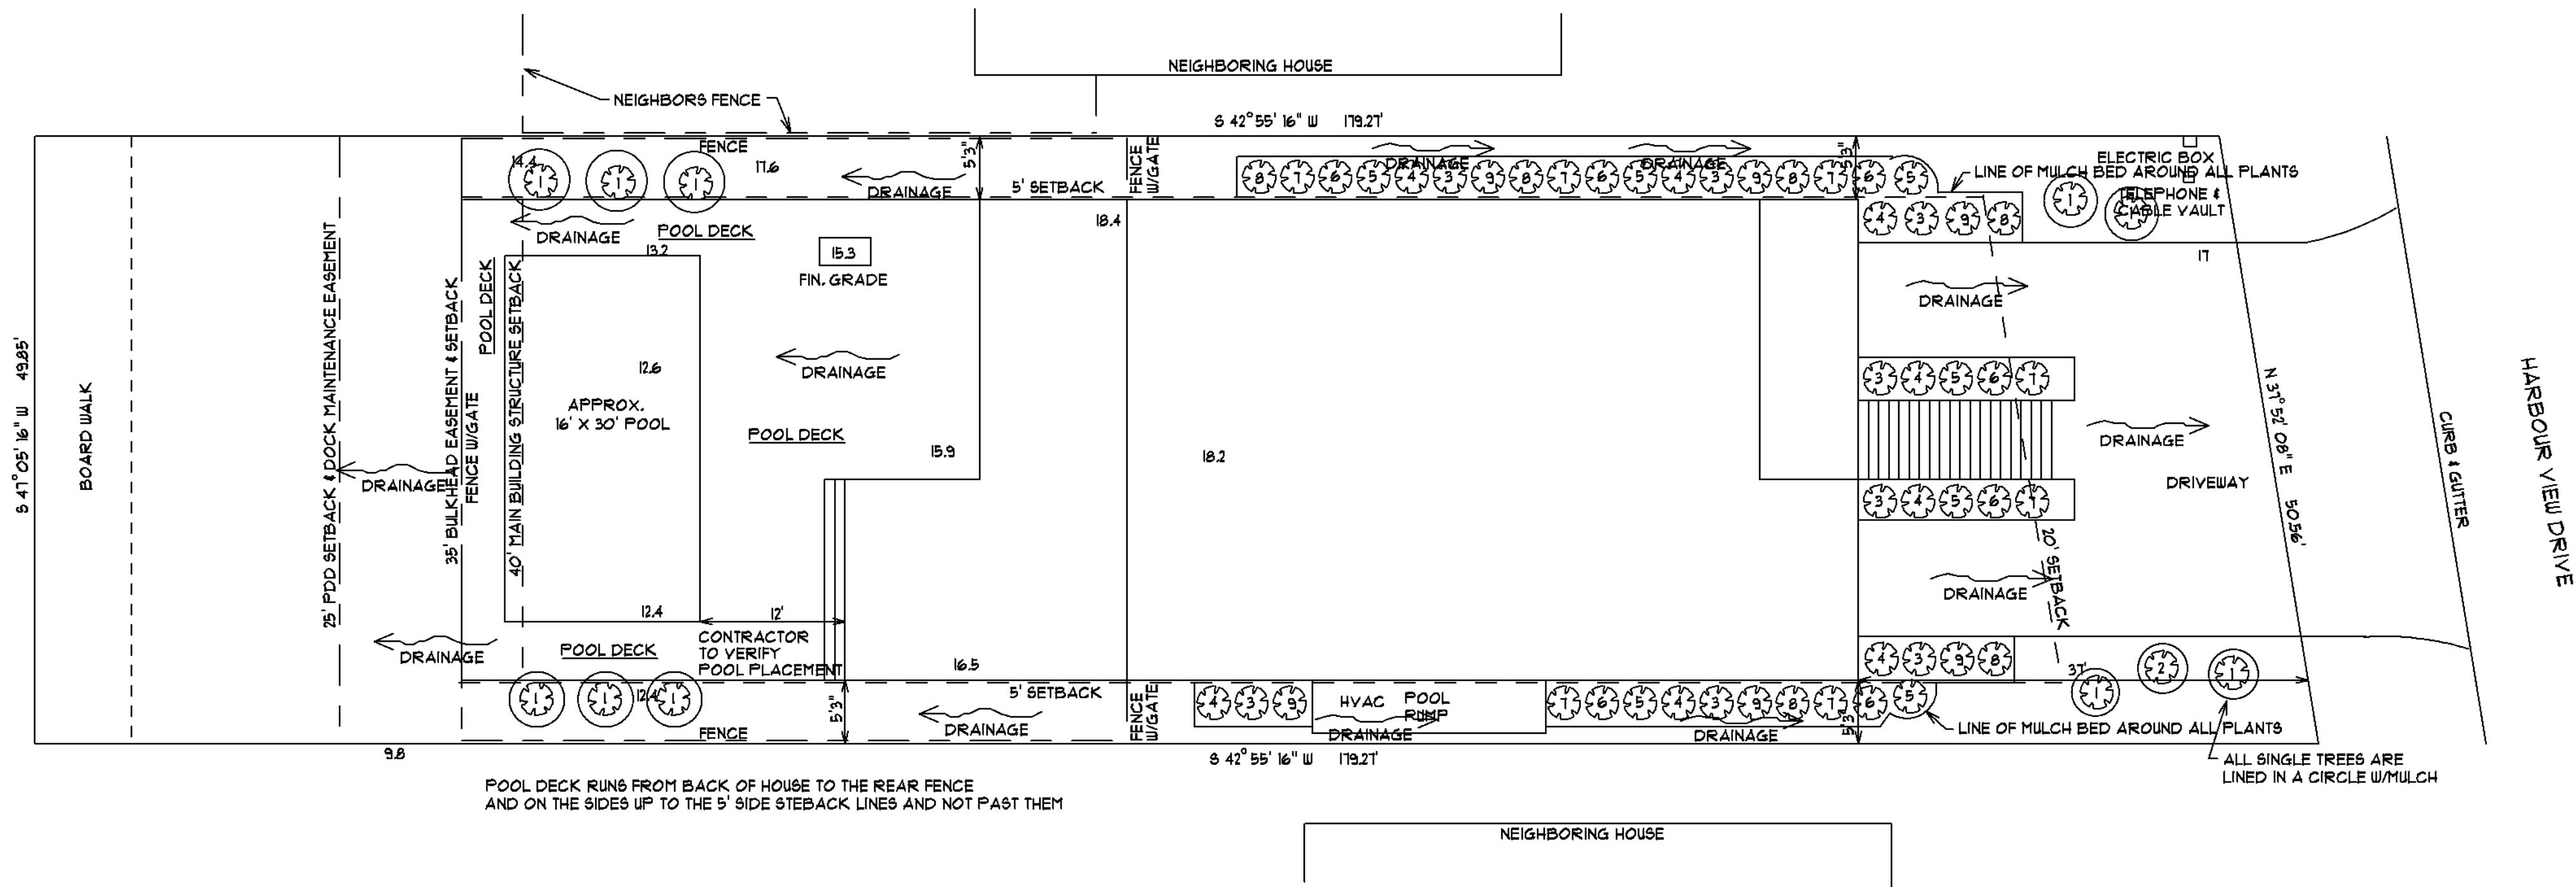

- PLANT LIST:
- TOTAL OF 10 - 1 FAN PALM
 - TOTAL OF 1 - 2 4" CALIFER LIVE OAK
 - TOTAL OF 8 - 3 3 GALLON OLEANDER
 - TOTAL OF 8 - 4 3 GALLON SWEET GRASS
 - TOTAL OF 1 - 5 1 GALLON MIN. AZALEA
 - TOTAL OF 1 - 6 3 GALLON BOXWOOD
 - TOTAL OF 1 - 7 1 GALLON MIN. KNOCK OUT ROSE
 - TOTAL OF 6 - 8 1 GALLON MIN. EVERGREEN
 - TOTAL OF 5 - 9 1 GALLON MIN. TEA OLIVE

- NOTES:
1. SURVEYOR TO VERIFY PLACEMENT OF HOUSE
 2. IRRIGATION SYSTEM W/AUTOMATIC TIMER TO BE INSTALLED TO PROVIDE FULL COVERAGE TO ALL GRASS AND PLANTS
 3. GRADE FROM BUILDING A MINIMUM OF 2% TO PREVENT WATER STANDING IN PLANT BEDS
 4. PLANT MATERIAL TO BE MULCHED W/BROWN MULCH
 5. CENTIPEDE GRASS WHOLE YARD
 6. ALL PLANTS ARE TO BE 24" TALL AT INSTALLATION AND 48" O.C.
 7. ALL UTILITIES ARE TO BE SCREENED

PAULA BURGIN
BUILDERS
DRAFTING & DESIGN
1341 CROOKED OAK DRIVE
PAULEY'S ISLAND, SC 29985
O (843) 919 - 5500
C (843) 283 - 3773
BURGINPAULA@AOL.COM

SCALE: 1" = 10'

DATE: 2/19/22

SHEET #8

PLOT PLAN

JOB LOCATION:
LOT 69 HARBOUR VIEW DRIVE
BOARDWALK ON THE WATERWAY
MYRTLE BEACH, SC

SQUARE FOOTAGE:	924
1ST FLOOR HEATED	2484
2ND FLOOR HEATED	3408
TOTAL HEATED SPACE	1253
GARAGE	183
COVERED AREA	654
COVERED PATIO	183
ENTRY PORCH	274
COVERED PORCH	5935
TOTAL UNDER ROOF	